



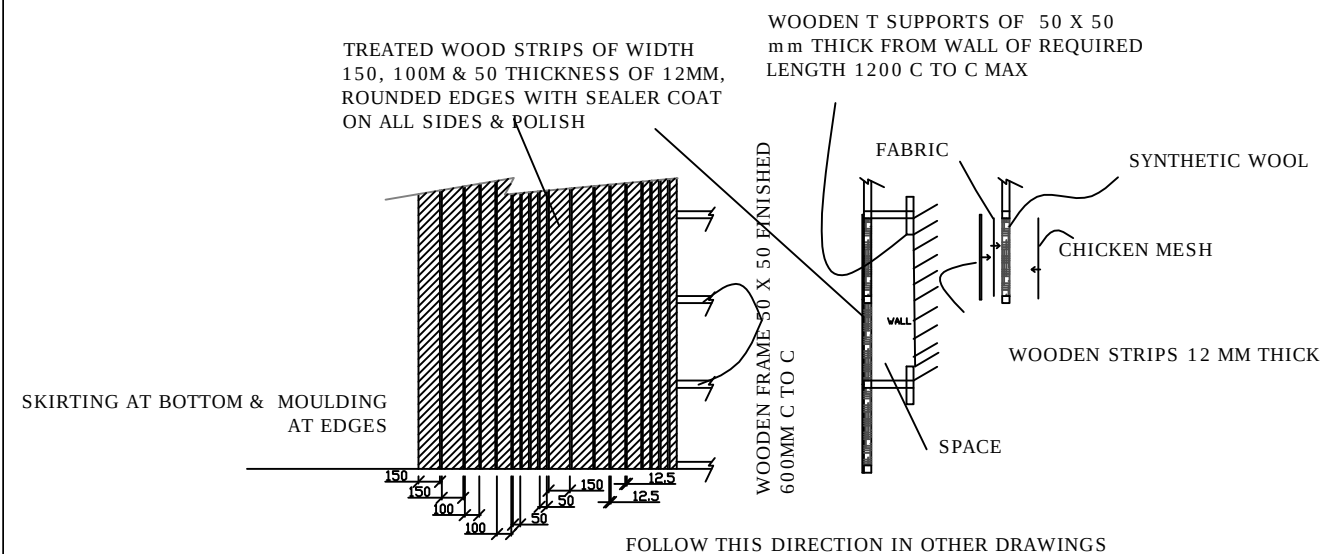


WALL PANELING WOODEN STRIPS

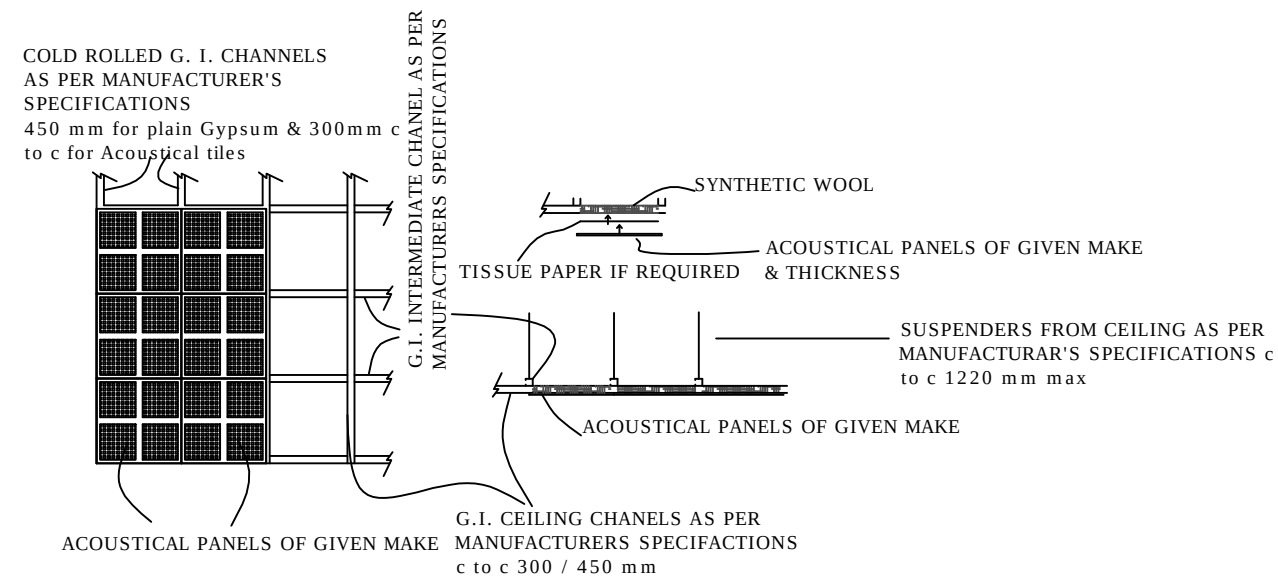



FOR G.I. FRAME & T GRID FOLLOW THE DETAILS OF MANUFACTURER

CEILING DETAILS

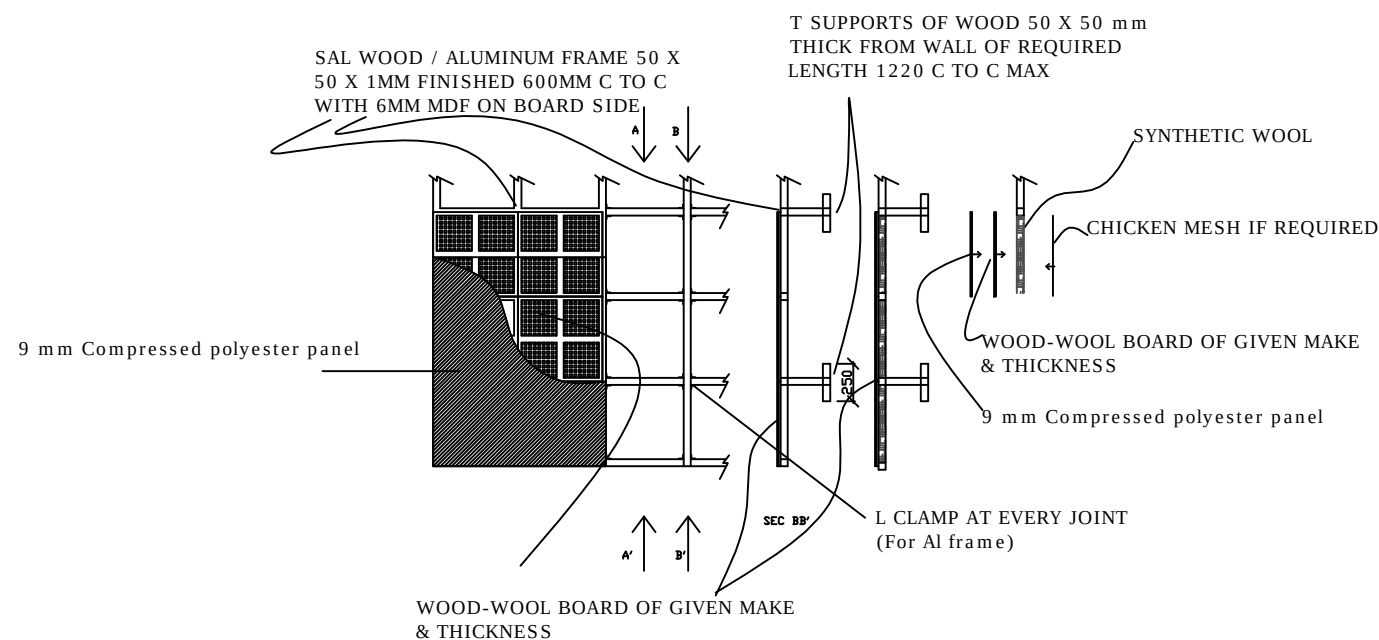

For fabric mounting follow the details of gripper manufacturer

WALL PANELING DETAILS

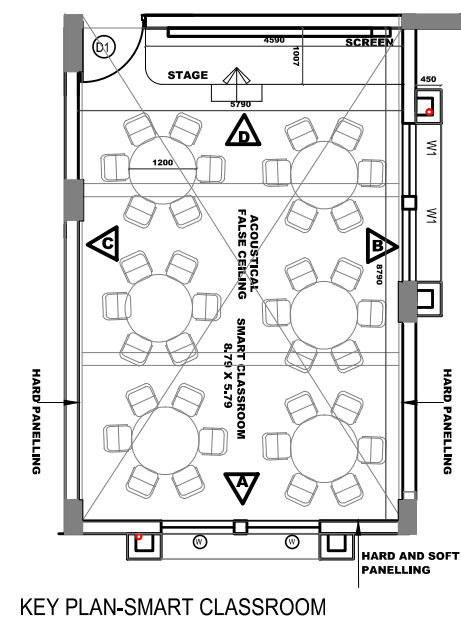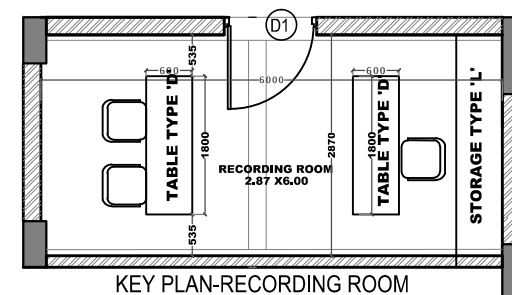

PROPOSED ACCOUSTICAL DETAILS FOR SMART CLASSROOM AND RECORDING ROOM

PROPOSED ACOUSTICAL DETAILS FOR TEACHERS LEARNING CENTER AT IUCAA CAMPUS,PUNE

NOTE:-
1) ALL DIMENSIONS ARE IN METERS UNLESS OTHERWISE SPECIFIED
2) CHECK ALL DIMENSIONS ON SITE.
3) DRAWING SHOULD NOT BE SCALED. ONLY WRITTEN DIMENSION SHOULD BE FOLLOWED.
4) IF ANY DISCREPANCY FOUND IN THIS DRAWING SAME SHOULD BE BROUGHT TO THE NOTICE OF THE ARCHITECT.

REVISION	DETAIL	DATE

SMART CLASSROOM AND RECORDING ROOM

Tender Drawing Acoustical Mounting Details

20.1.2020
Drawing No: IUCAA/TLC/ACC/500
Consultant:
V. N. PURANDARE & ASSOCIATES
124 Shaniware Peth, Pune
Cell: 98909 22712
E-mail: vijaypurandare@gmail.com
www.AuditoriumAcoustics.com


NOTE:-

- 1) ALL DIMENSIONS ARE IN METERS UNLESS OTHERWISE SPECIFIED
- 2) CHECK ALL DIMENSIONS ON SITE.
- 3) DRAWING SHOULD NOT BE SCALED. ONLY WRITTEN DIMENSION SHOULD BE FOLLOWED.
- 4) IF ANY DISCREPANCY FOUND IN THIS DRAWING SAME SHOULD BE BROUGHT TO THE NOTICE OF THE ARCHITECT.






25 JUNE 2019
Drawing No:CIDCO/ BHP/INT/ 13






Auditorium Consultant:
V. N. PURANDARE & ASSOCIATES
124 Shaniware Peth, Pune
Cell: 98909 22712
E-mail: vijaypurandare@gmail.com
www.AuditoriumAcoustics.com

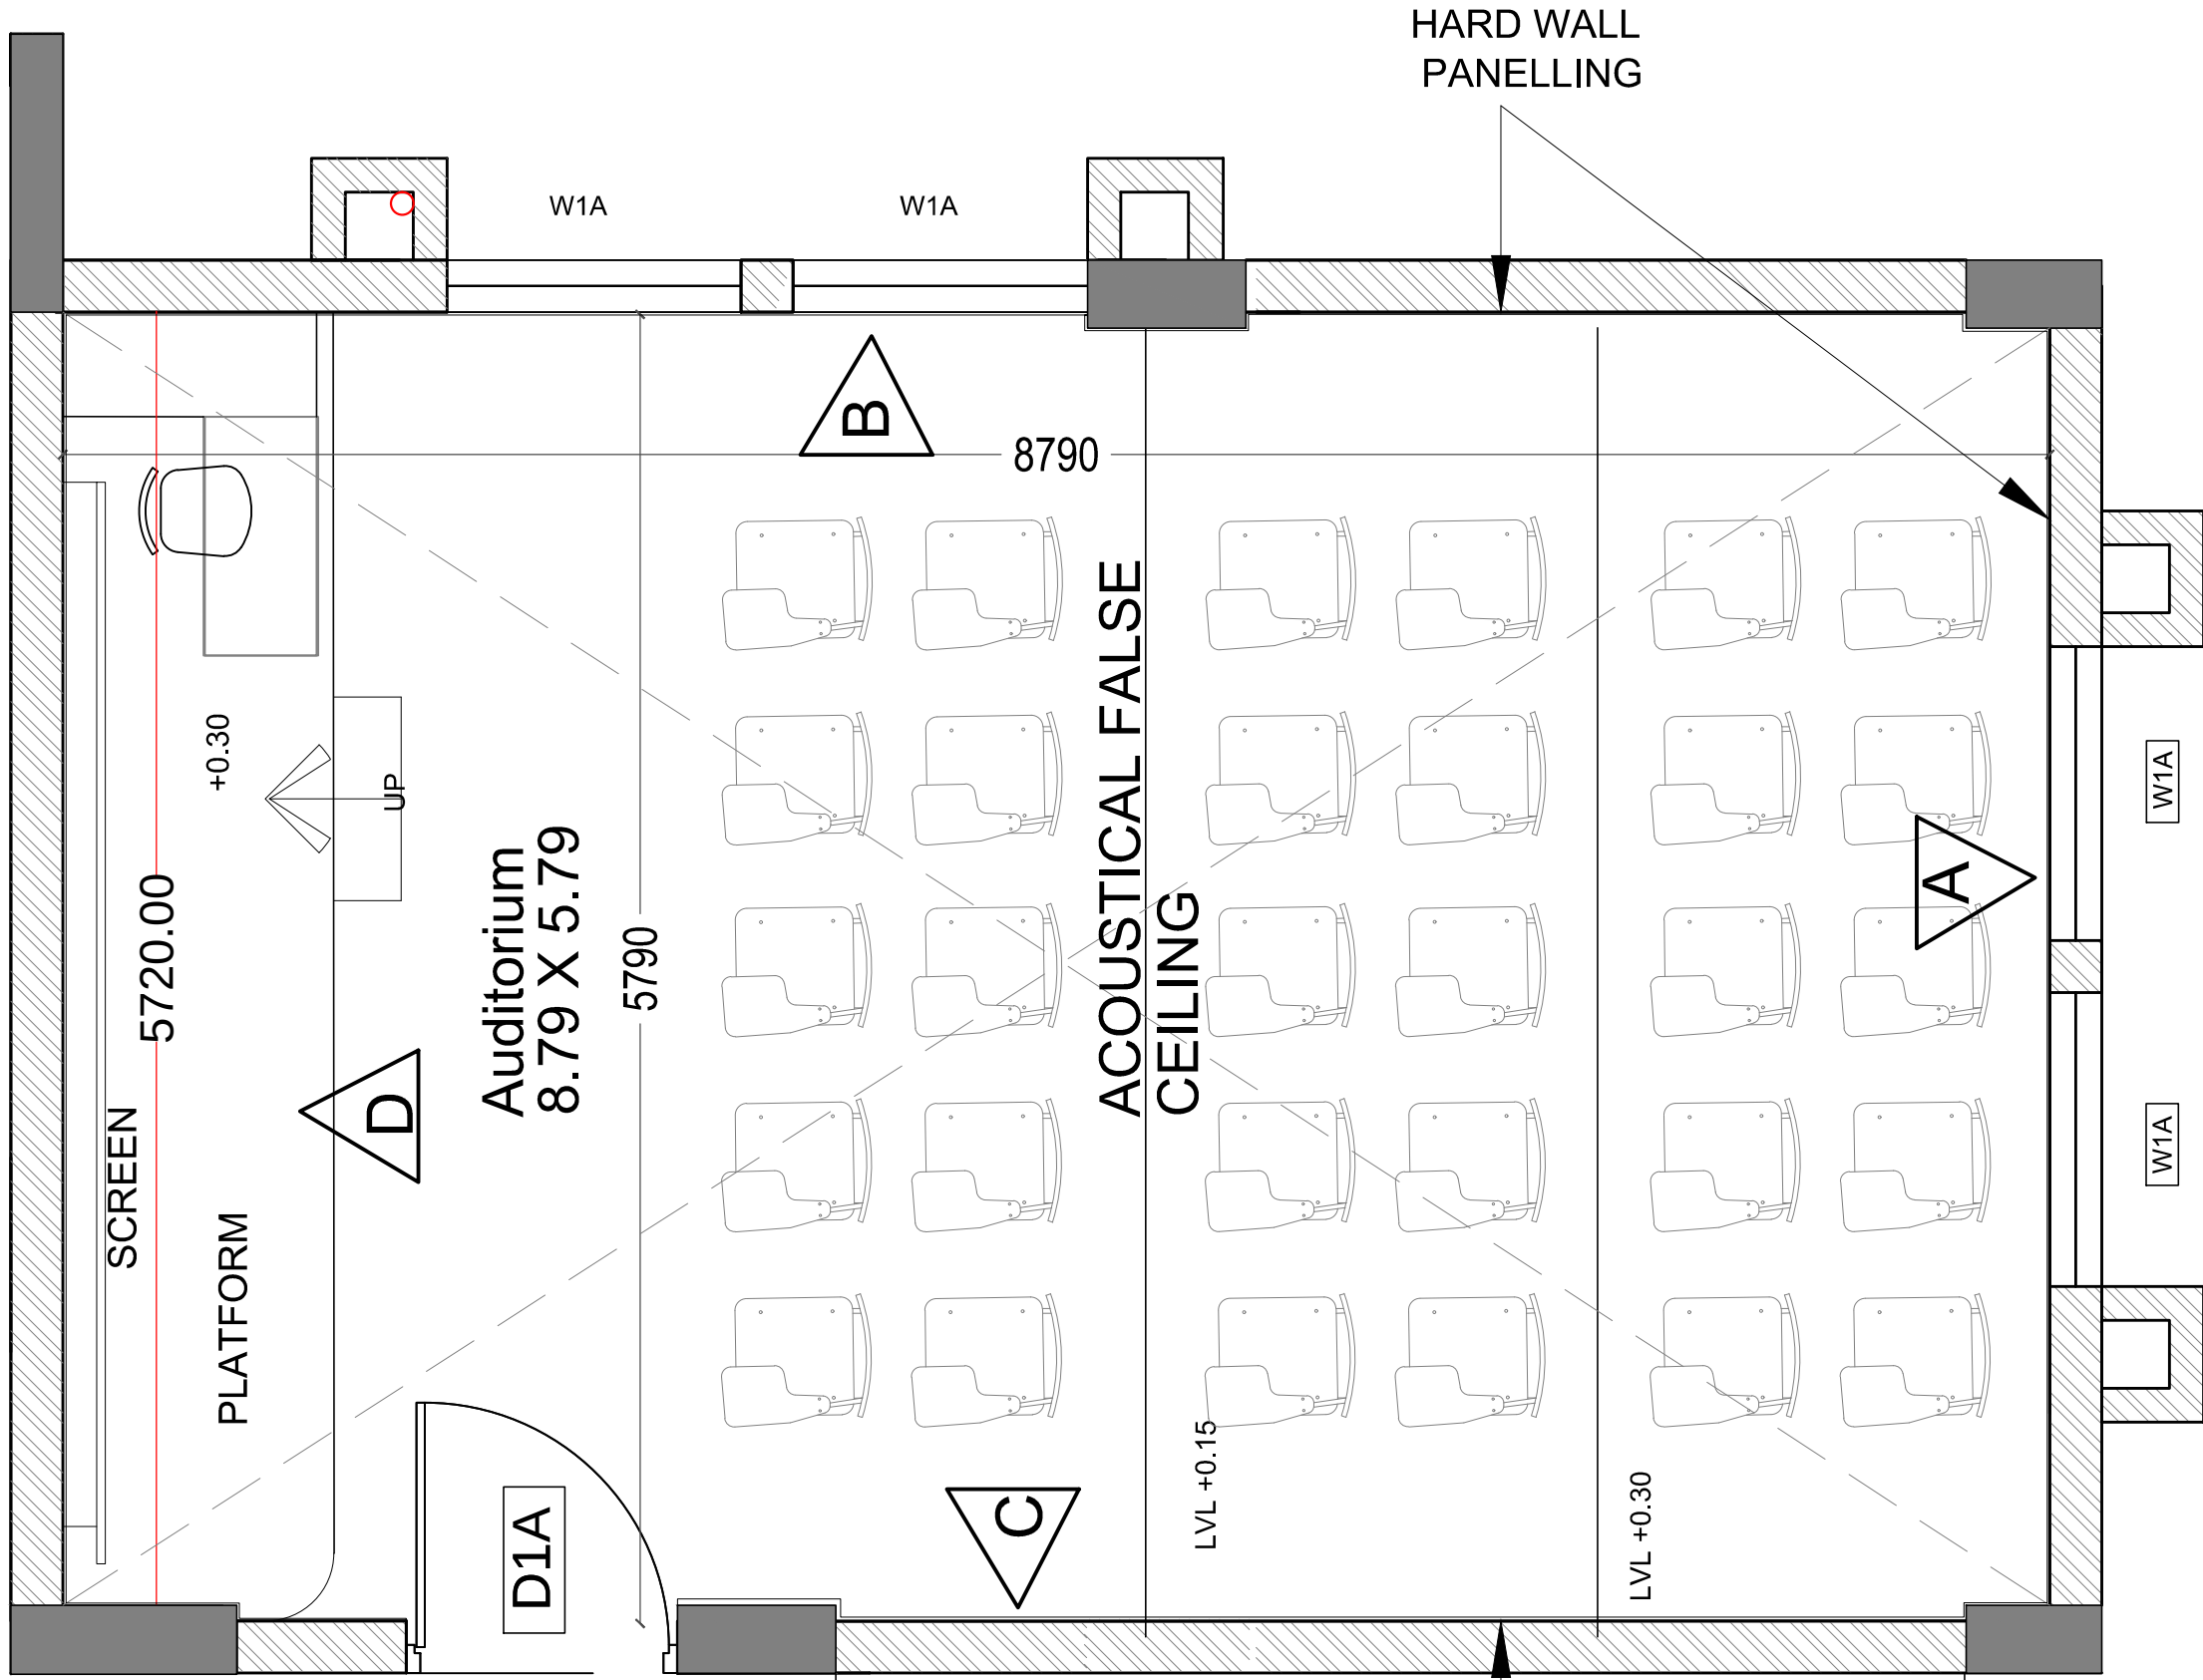

AUDITORIUM
LAYOUT -GROUND FLOOR







THE DRAWING IS THE PROPERTY OF MS RAJEEV VISHWASRAO ARCHITECTS (PUNE) & NOT TO BE COPIED OR USED WITHOUT THEIR WRITTEN PERMISSION. © MansipC/Edasasay/LCAUDITORIUM AND SHARAT LAYOUT 20.1.2020/09	NO REVISIONS	ALL DIMENSIONS SHALL BE CHECKED & CO-RELATED WITH STRUCTURAL / WORKING DRAWINGS & ACCURACY SHALL BE IMMEDIATELY BROUGHT TO THE NOTICE OF THE ARCHITECTS BEFORE ITS EXECUTION. THIS DRAWING SHOULD NOT BE SCALED & ONLY WRITTEN DIMENSIONS TO BE FOLLOWED. ALL DIMENSIONS ARE IN METER UNLESS OTHERWISE SPECIFIED.	ARCHITECT RAJEEV VISHWASRAO ARCHITECTS & PLANNERS SANSKRITI 3RD FLOOR PLOT NO. 2, SADASHIV PETH, PUNE - 411 001. TEL. NO. : 020 24530006, 24532008	TITLE : AUDITORIUM ROOM LAYOUT	DRG. NO.
				PROJECT : TEACHER'S LEARNING CENTRE AT IUCAA CAMPUS	IU/TLC/IN/121
				CLIENT : THE DIRECTOR IUCAA	DATE :
				SCALE : NTS DATE : 31.08.18 DESIGN : KAVITA	17.1.2020

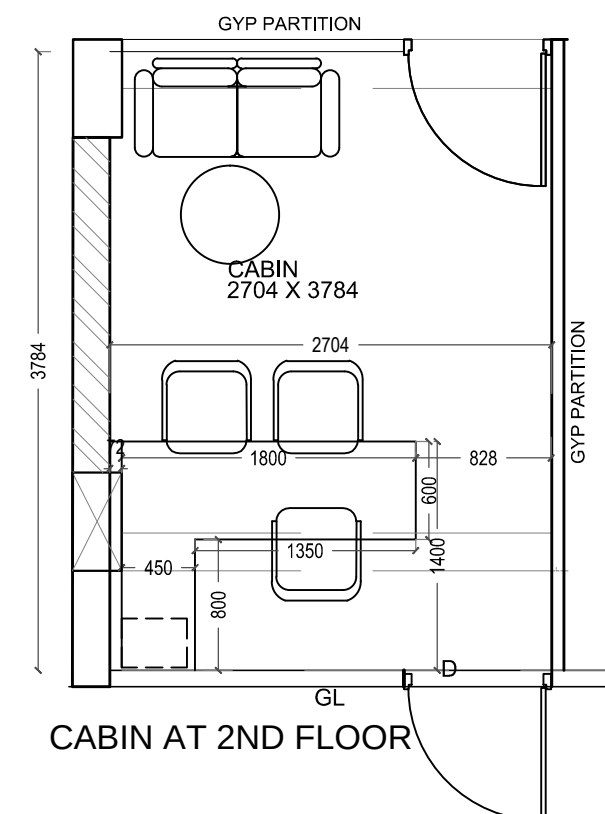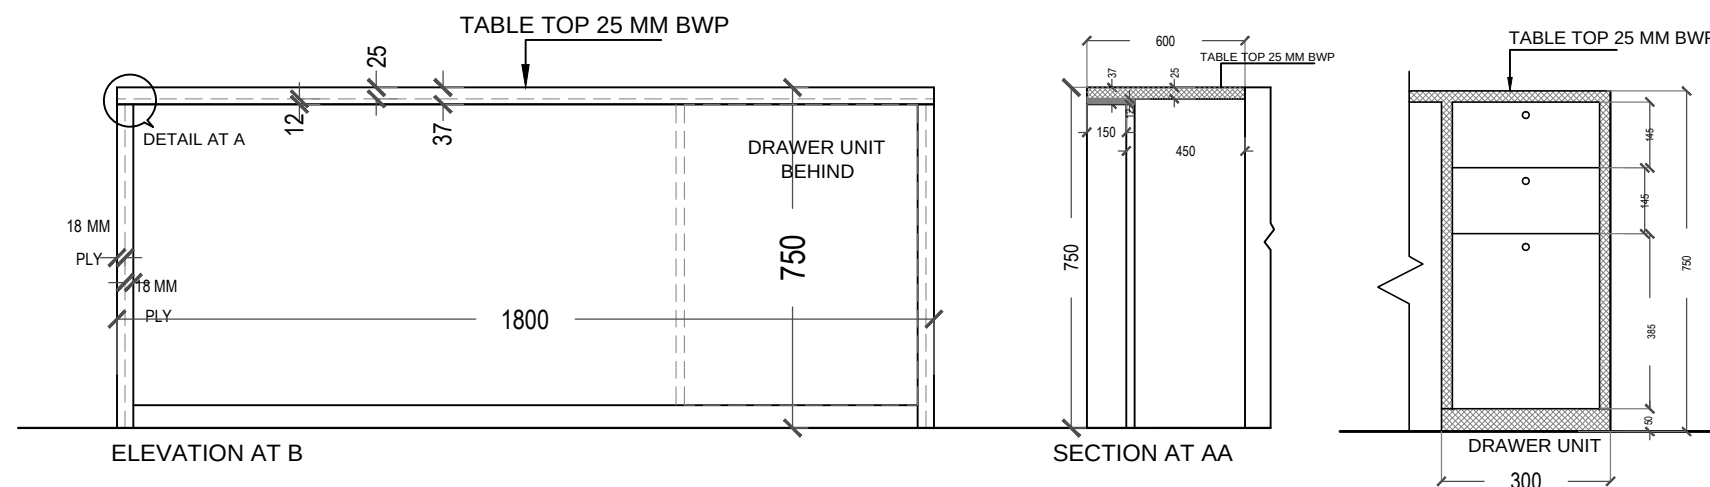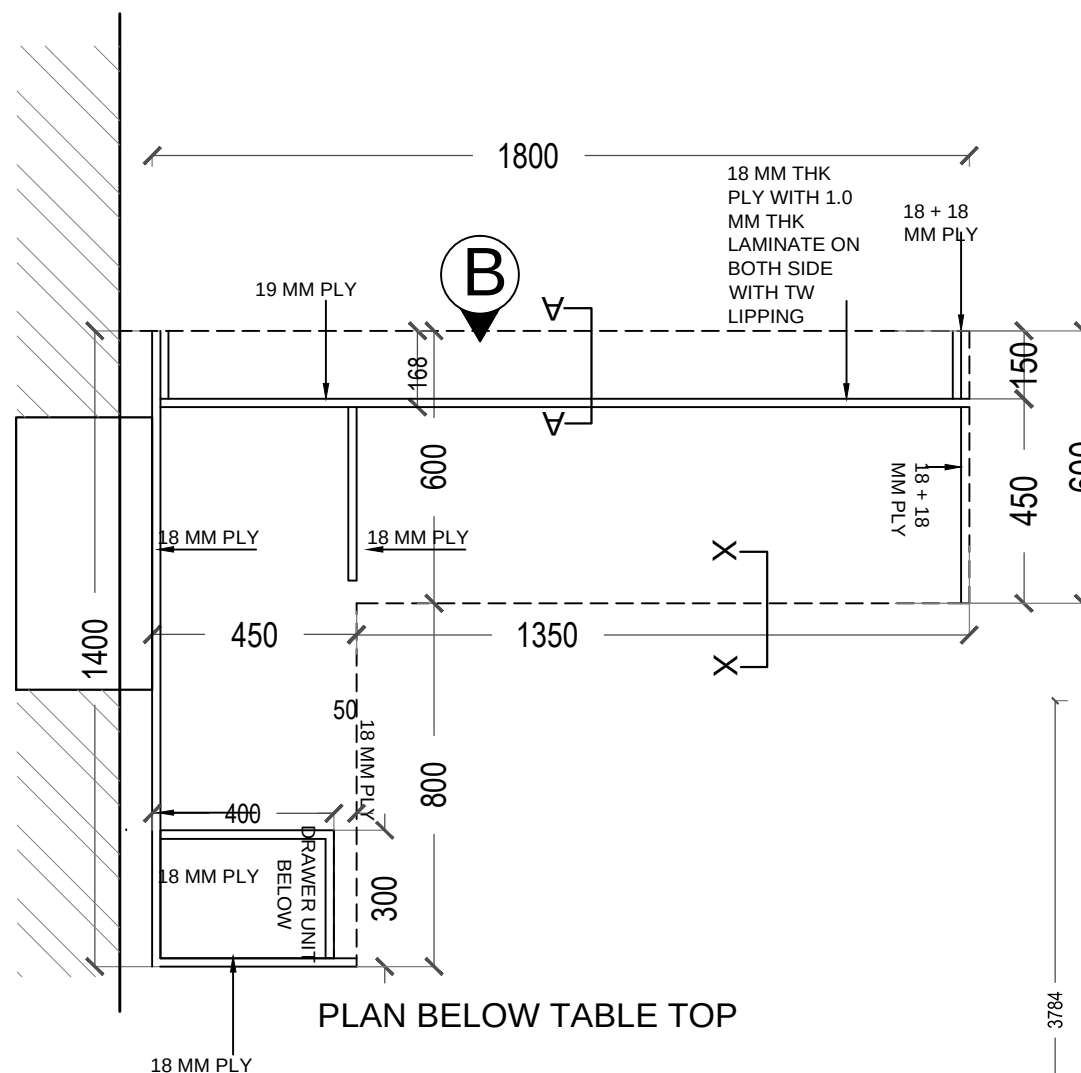

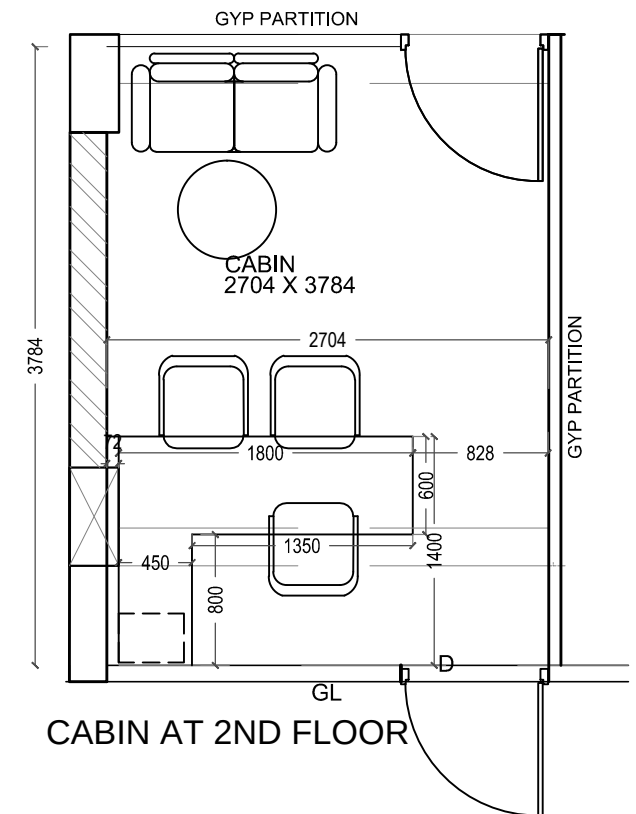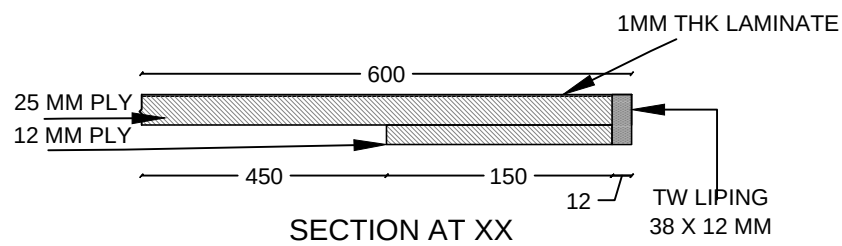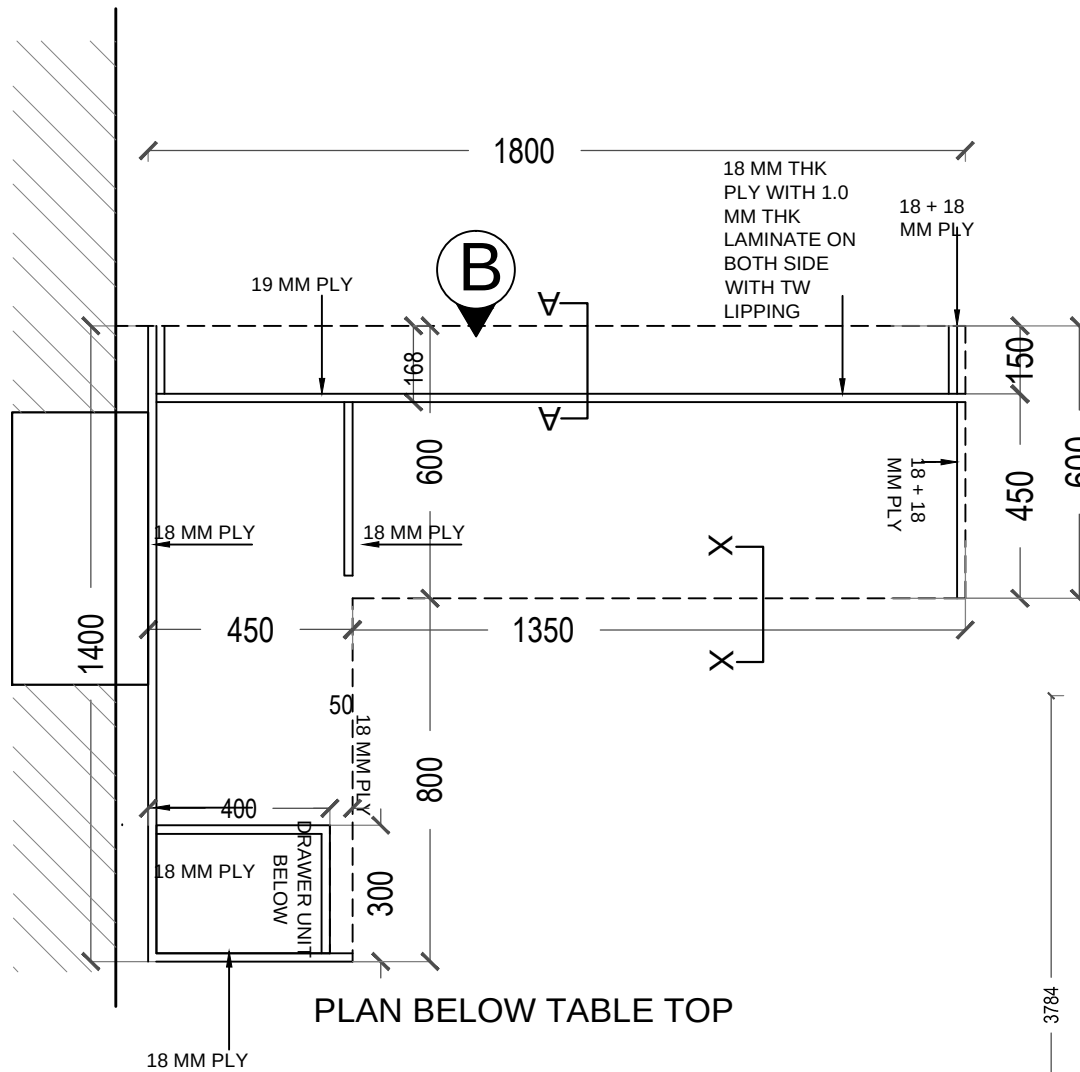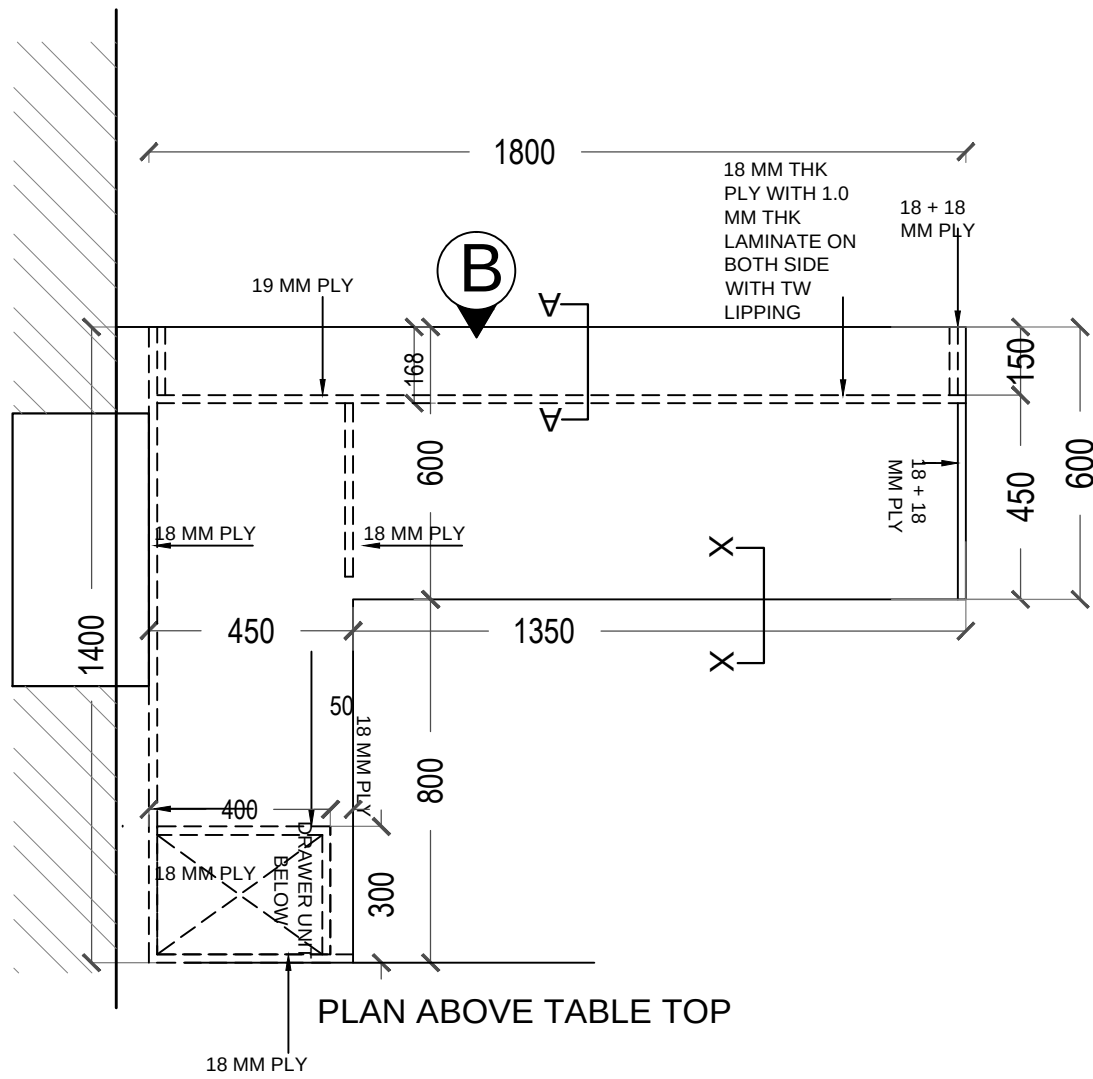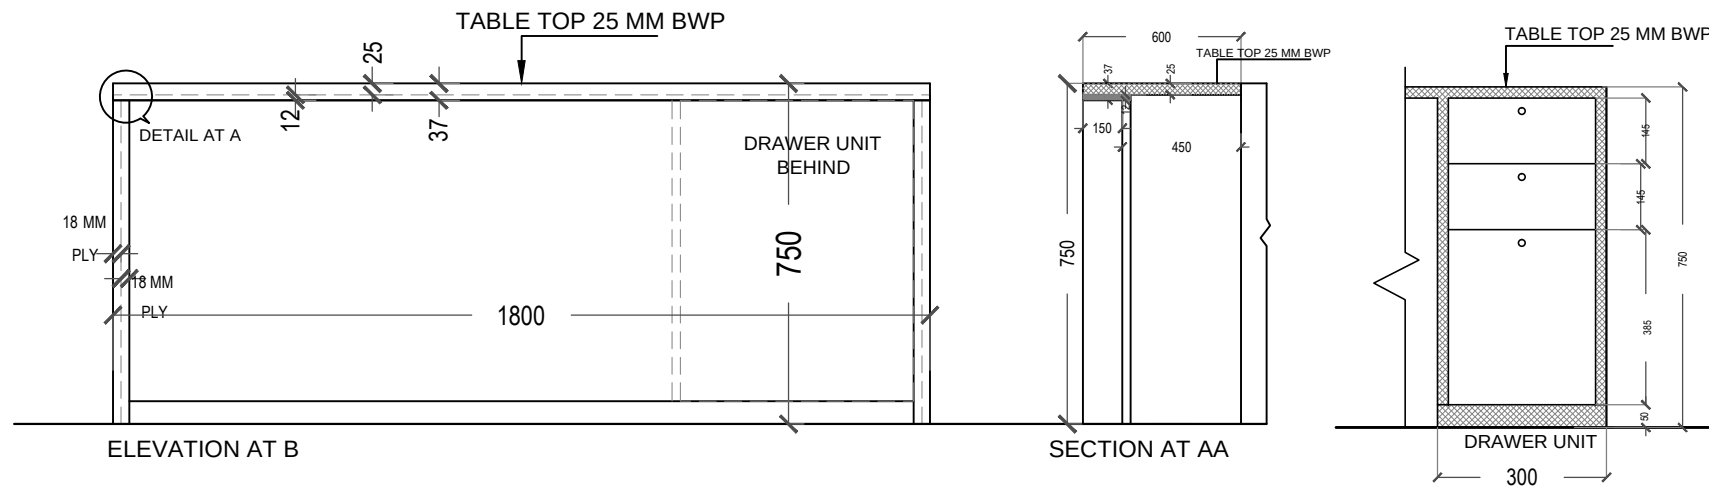


CABIN TABLE 'B' DETAILS

[illegible]

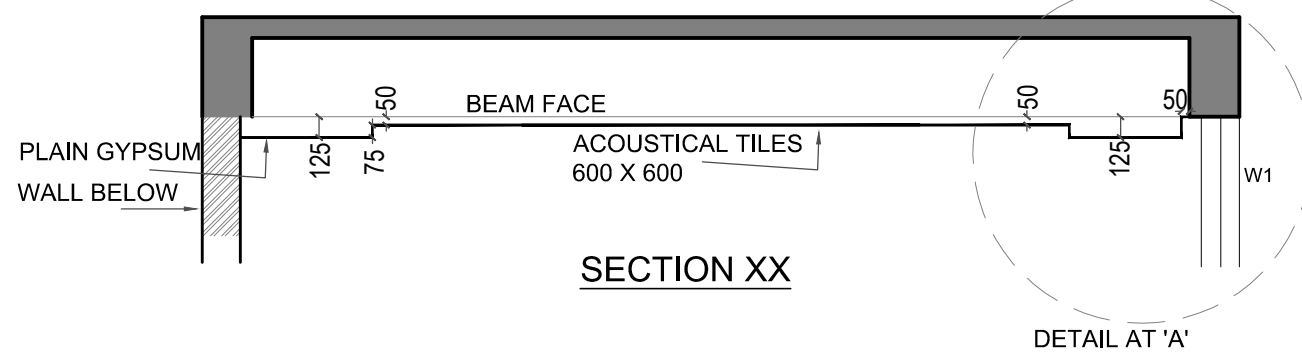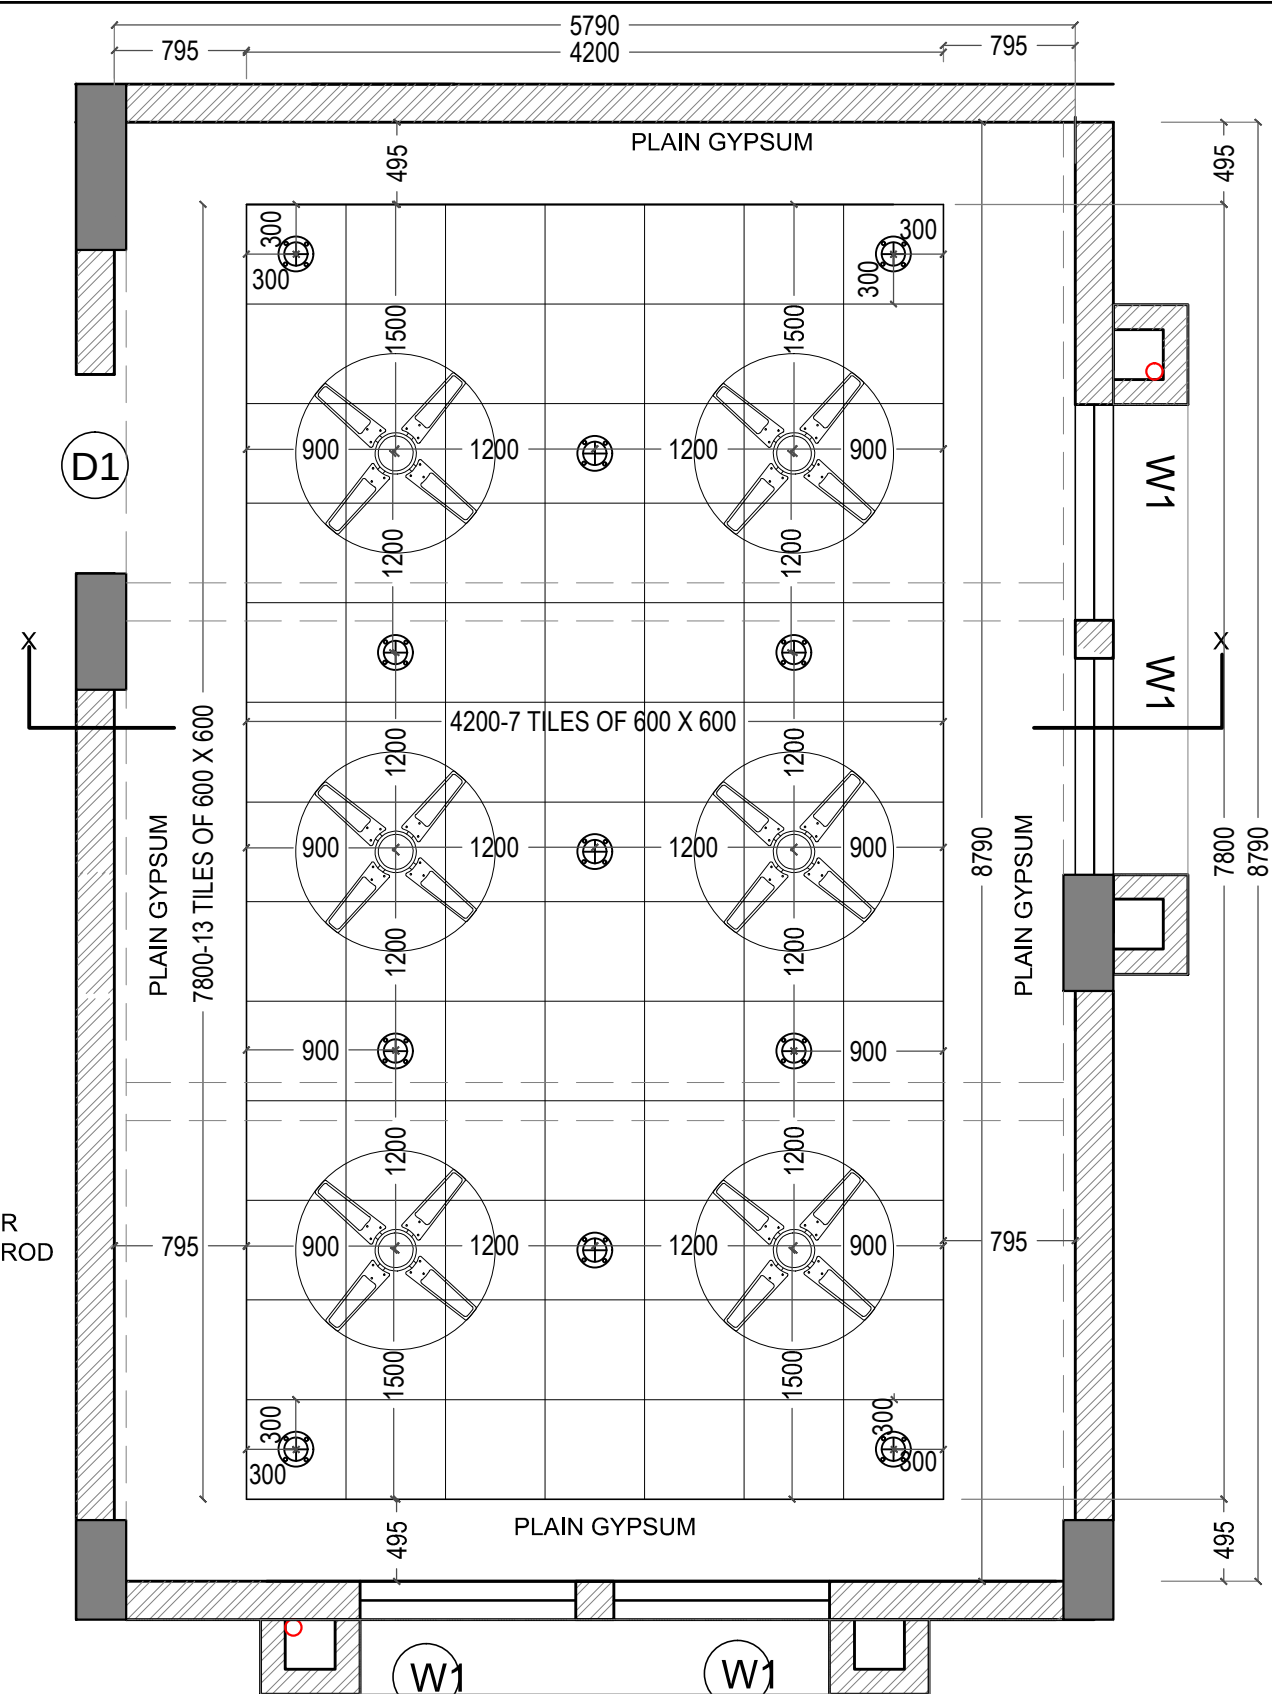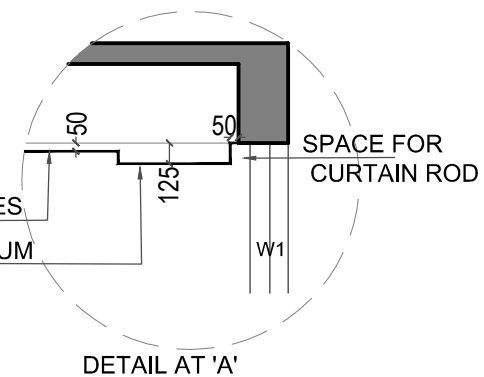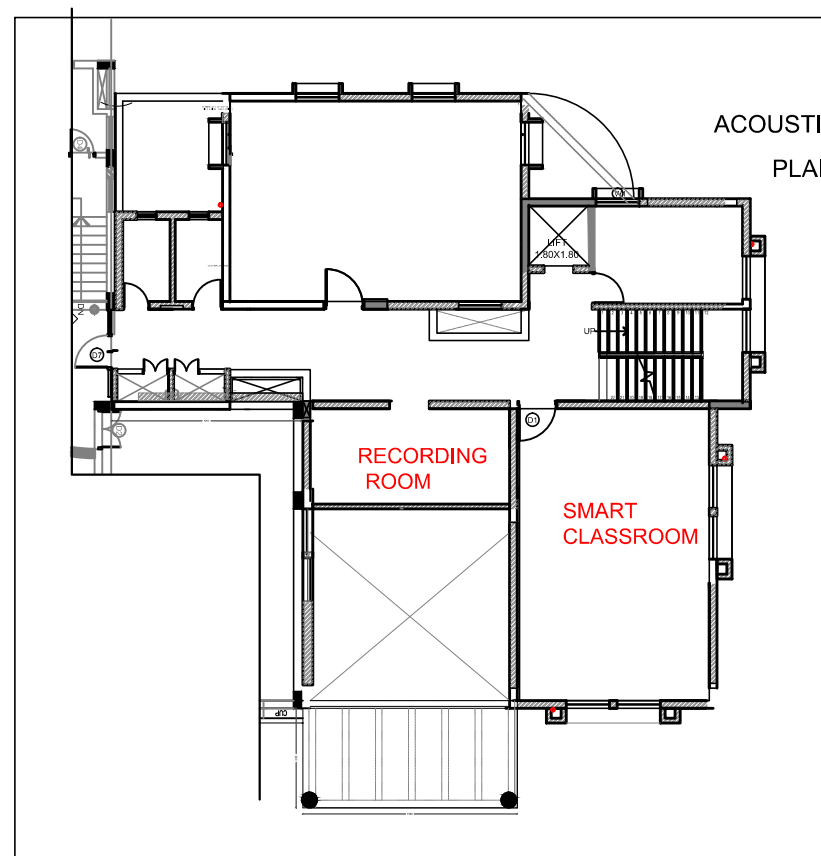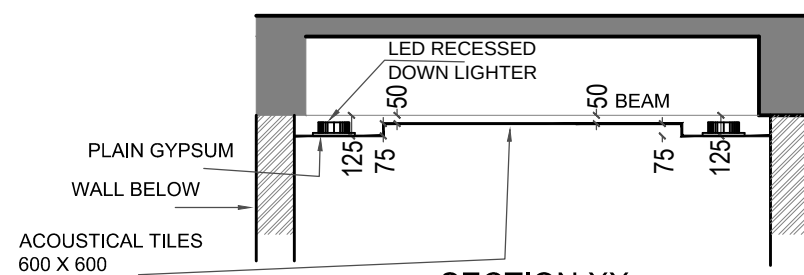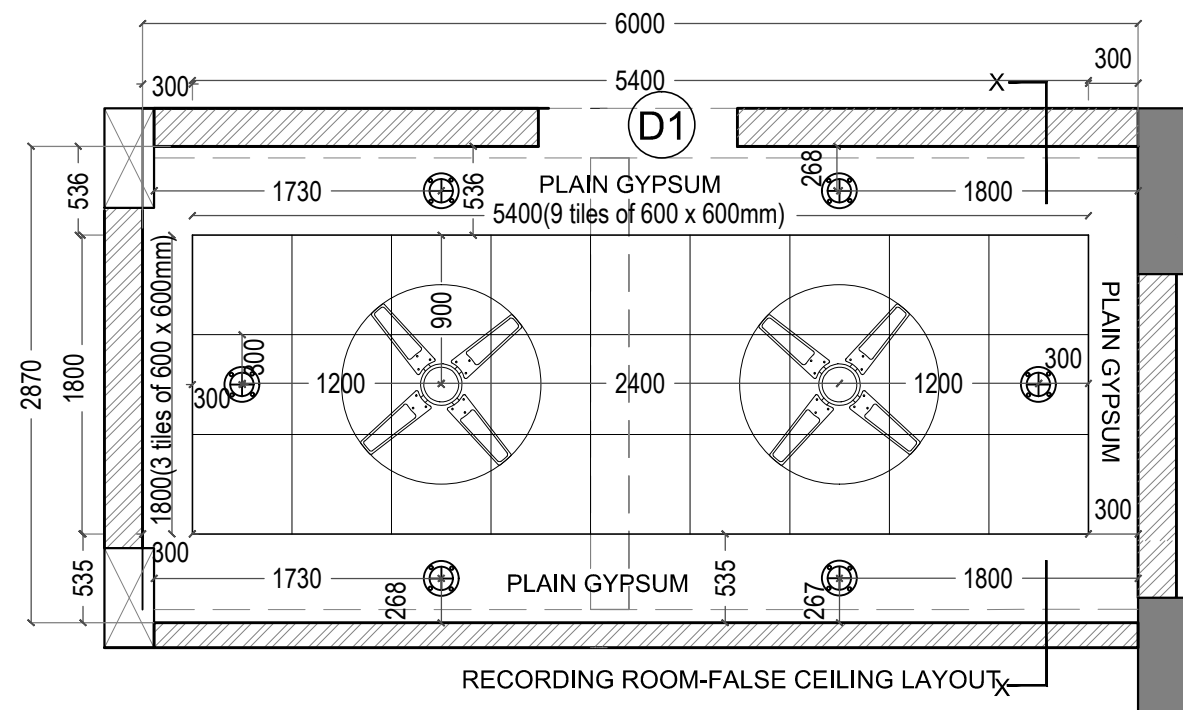

THIS DRAWING IS THE PROPERTY OF RAMESH VISHWASRAO ARCHITECTS (PUNE) & NOT TO BE COPIED OR USED WITHOUT THEIR WRITTEN PERMISSION. © RAMESH VISHWASRAO ARCHITECTS, PUNE. ALL RIGHTS RESERVED. PUNE, INDIA. TEL: +91 20 25500000. FAX: +91 20 25500001.	ALL DIMENSIONS SHALL BE CHECKED & CO-RELATED WITH STRUCTURAL / WORKING DRAWINGS & AMBIGUITY SHALL BE IMMEDIATELY BROUGHT TO THE NOTICE OF THE ARCHITECTS BEFORE ITS EXECUTION. THIS DRAWING SHOULD NOT BE SCALED & ONLY WRITTEN DIMENSIONS SHALL BE USED. ALL DIMENSIONS ARE IN METERS UNLESS OTHERWISE SPECIFIED.	NO. REVISIONS	ARCHITECT RAJEEV VISHWASRAO ARCHITECTS & PLANNERS 'SANSKRUT 3RD FLOOR, PLOT NO. 2, SADASHIV PETH, PUNE - 411 004. TEL. NO. - 020 25500008, 24550008	TITLE : FALSE CEILING LAYOUT-ACCOUSTICAL TILES		DRG. NO.
				PROJECT : TEACHER'S LEARNING CENTRE AT IUCAA CAMPUS		IU/TLC/IN/233
				CLIENT : THE DIRECTOR, IUCAA		DATE :
				SCALE : NTS	DATE : 31.08.18	DESIGN : SAI


EXISTING BUILDING

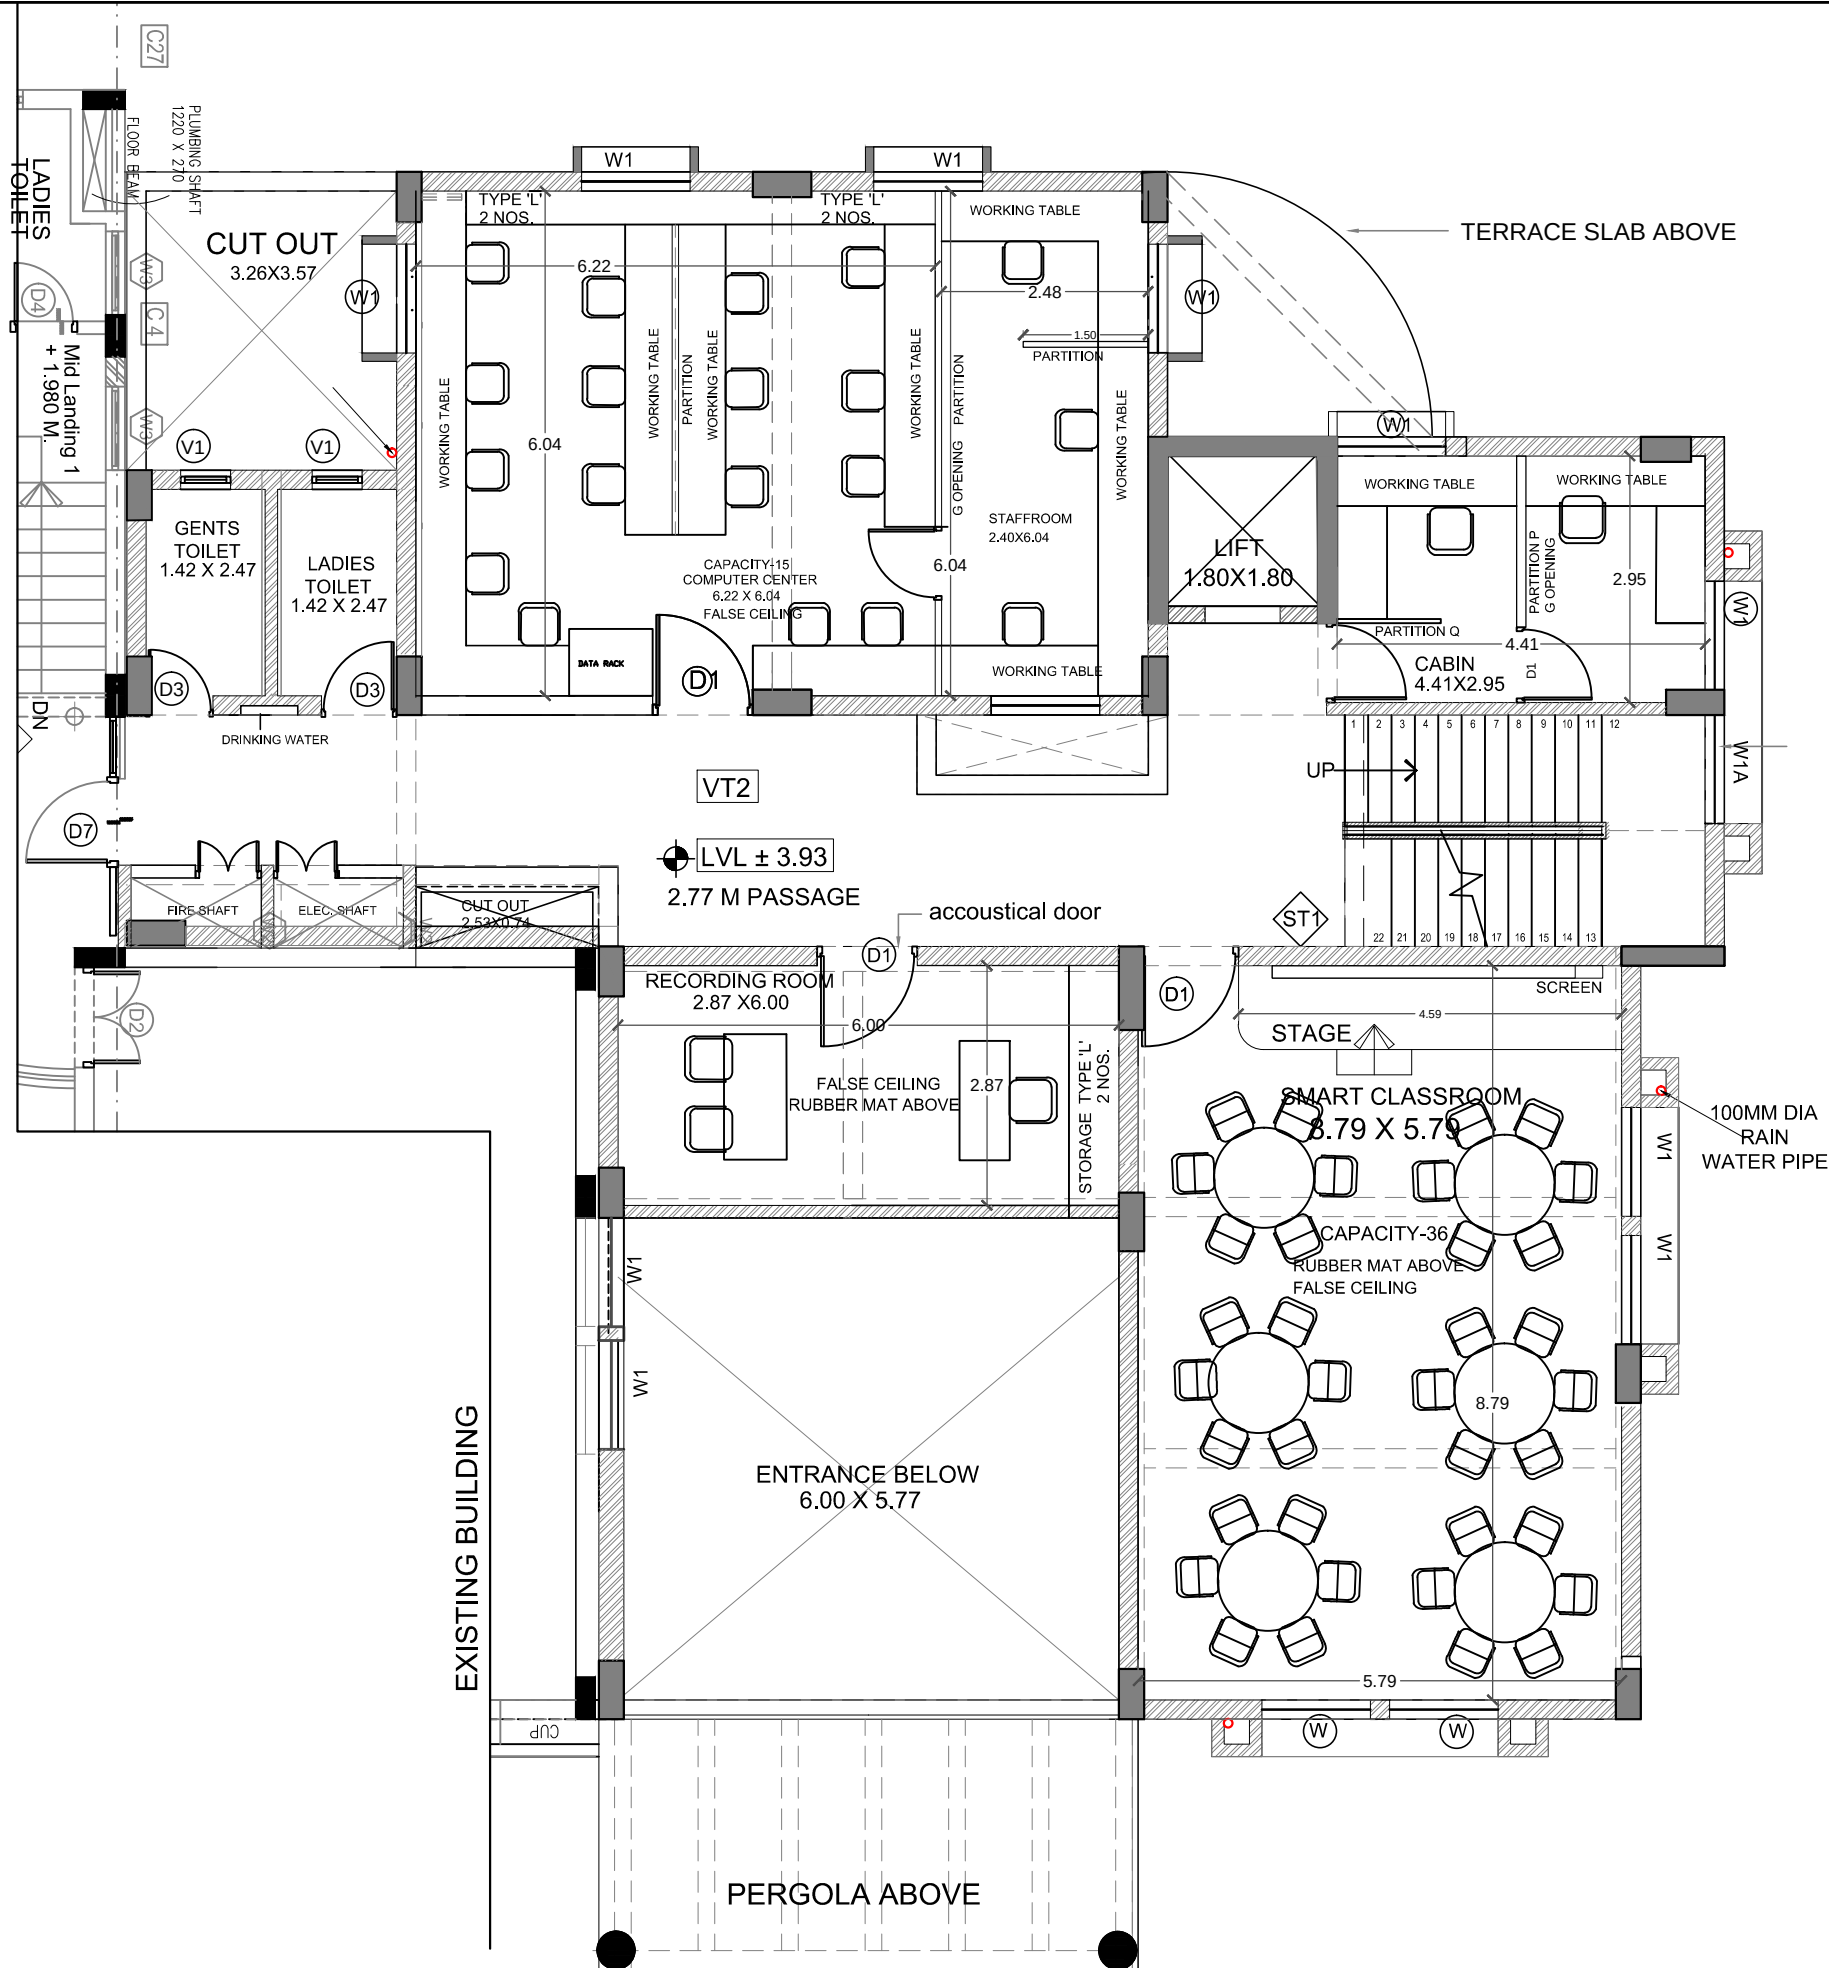

FIRST FLOOR PLAN

FIRST FLOOR
FURNITURE LAYOUT


THIS DRAWING IS THE PROPERTY OF M/S RAJEEV VISHWASRAO ARCHITECTS (PUNE) & NOT TO BE REPRODUCED OR COPIED WITHOUT THEIR WRITTEN PERMISSION. C:\Users\pvc\Desktop\ATL\IUCAA - TLC - FLOOR PLANS - REVISION.dwg	NO REVISIONS	ALL DIMENSIONS SHALL BE CHECKED & CO-RELATED WITH STRUCTURAL / WORKING DRAWINGS & AMBIGUITY SHALL BE IMMEDIATELY BROUGHT TO THE ATTENTION OF THE ARCHITECT. THIS DRAWING SHOULD NOT BE SCALED & ONLY WRITTEN DIMENSIONS TO BE FOLLOWED. ALL DIMENSIONS ARE IN METERS UNLESS OTHERWISE SPECIFIED.	ARCHITECT RAJEEV VISHWASRAO ARCHITECTS & PLANNERS 'SANSKRITI' 3RD FLOOR, PLOT NO. 2, SARASWATI PETH, PUNE - 411 030. TEL. NO. - 020 24530009, 24530008	TITLE : FIRST FLOOR-FURNITURE LAYOUT PROJECT : TEACHER'S LEARNING CENTRE AT IUCAA CAMPUS CLIENT : THE DIRECTOR IUCAA SCALE : NTS DATE : 31.08.18 DESIGN : KAVITA	DRG. NO.
					IU/TLC/IN/200
					DATE :
					17.1.2020

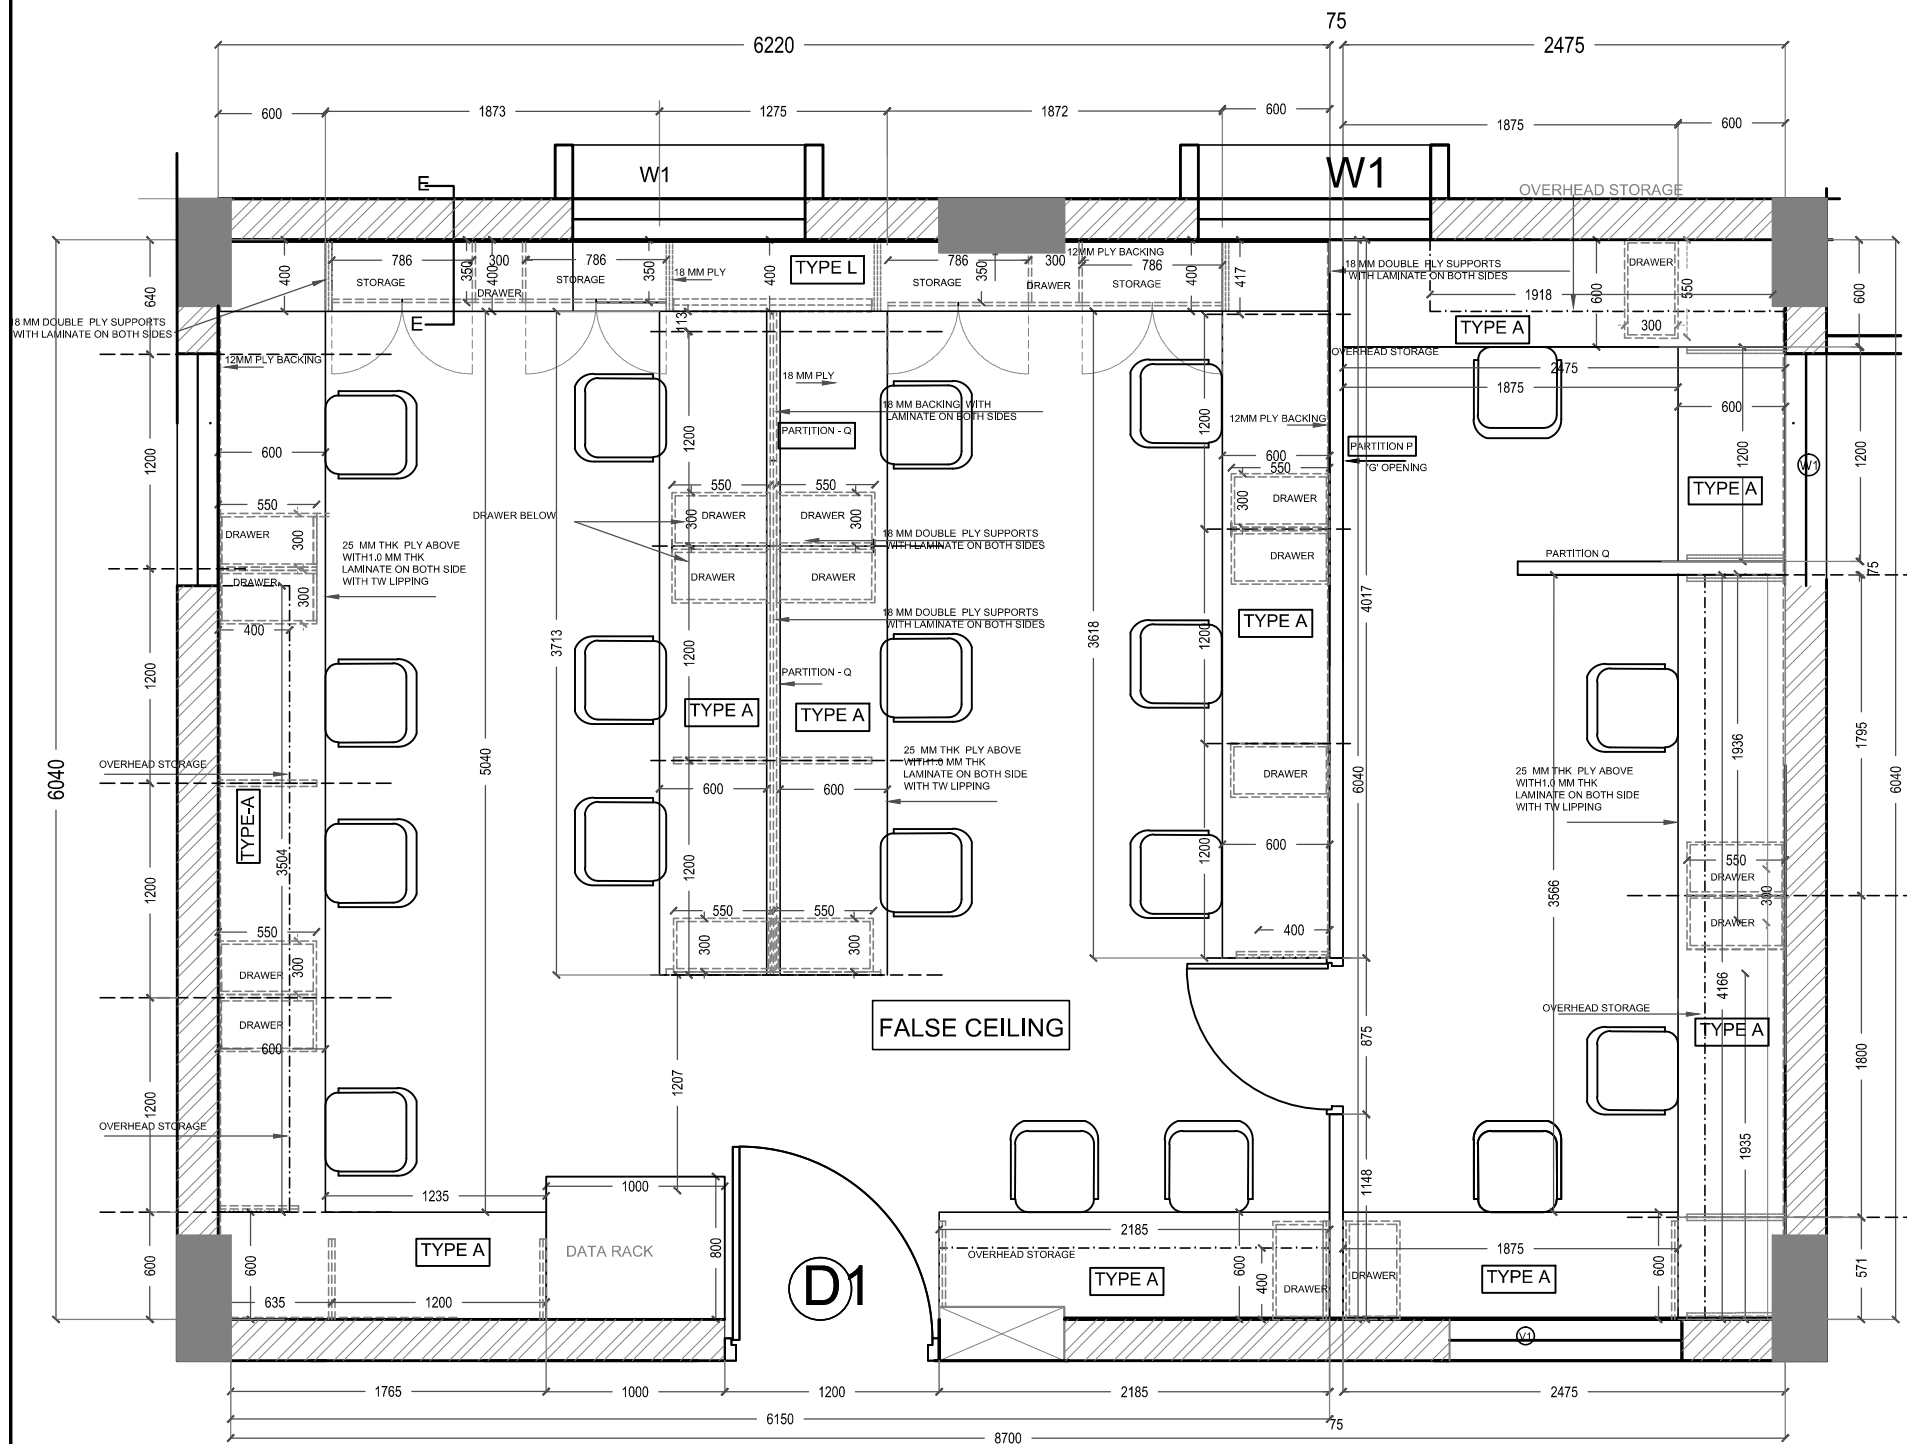


ROOM 3- COMPUTER LAB

PARTITION	
TYPE	HEIGHT
P	2200 MM
Q	1500 MM
R	1500 MM
S	2955 MM
T	3390 MM
U	3390 MM

TYPE	FURNITURE TYPE	SIZE
A	TABLE	1200 X 600 MM
A	TABLE	1500 X 600 MM
A	TABLE	1800 X 600 MM
F	STORAGE CABINET	3435 X 600 MM
L	LAB TABLE	IUCAA

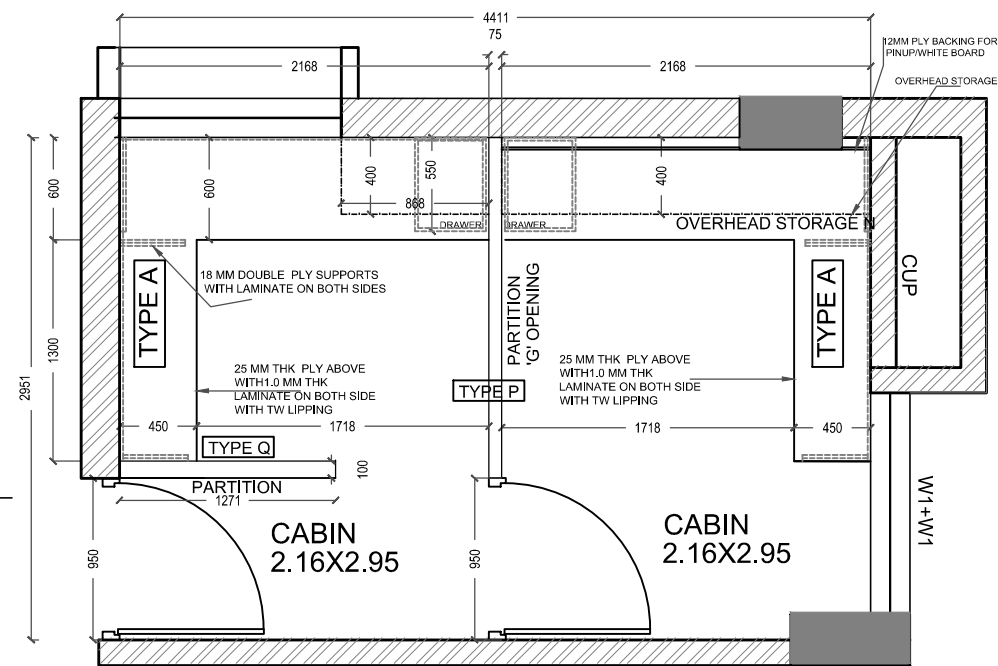

ROOM 4 - CABIN

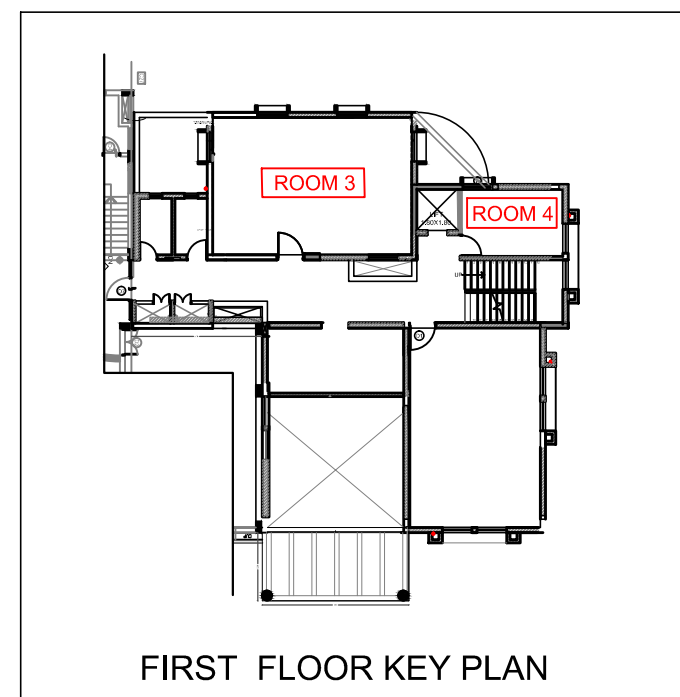

FIRST FLOOR KEY PLAN

THIS DRAWING IS THE PROPERTY OF
M/S RAJEEV VISHWASRAO ARCHITECTS,(PUNE)
& NOT TO BE COPIED OR USED WITHOUT
THEIR WRITTEN PERMISSION.


ALL DIMENSIONS SHALL BE CHECKED & CO-RELATED WITH STRUCTURAL /
WORKING DRAWINGS & AMBIGUITY SHALL BE IMMEDIATELY BROUGHT
TO THE NOTICE OF THE ARCHITECTS BEFORE ITS EXECUTION.
THIS DRAWING SHOULD NOT BE SCALED & ONLY WRITTEN
DIMENSIONS TO BE FOLLOWED.
ALL DIMENSIONS ARE IN METER UNLESS OTHERWISE SPECIFIED.

NO.	REVISIONS

ARCHITECT
RAJEEV VISHWASRAO
ARCHITECTS & PLANNERS
"SANSKRUTI" 3RD FLOOR, PLOT NO. 2, SADASHIV PETH,
PUNE - 411 030. TEL. NO. - 020 24530008, 24532008

TITLE : FIRST FLOOR FURNITURE DETAIL LAYOUT		
PROJECT : TEACHER'S LEARNING CENTRE AT IUCAA CAMPUS		
CLIENT :THE DIRECTOR ,IUCAA		
SCALE : NTS	DATE : 31.08.18	DESIGN : KAVITA


DRG. NO.
IU/TLC/N/210
DATE : 09.12.19

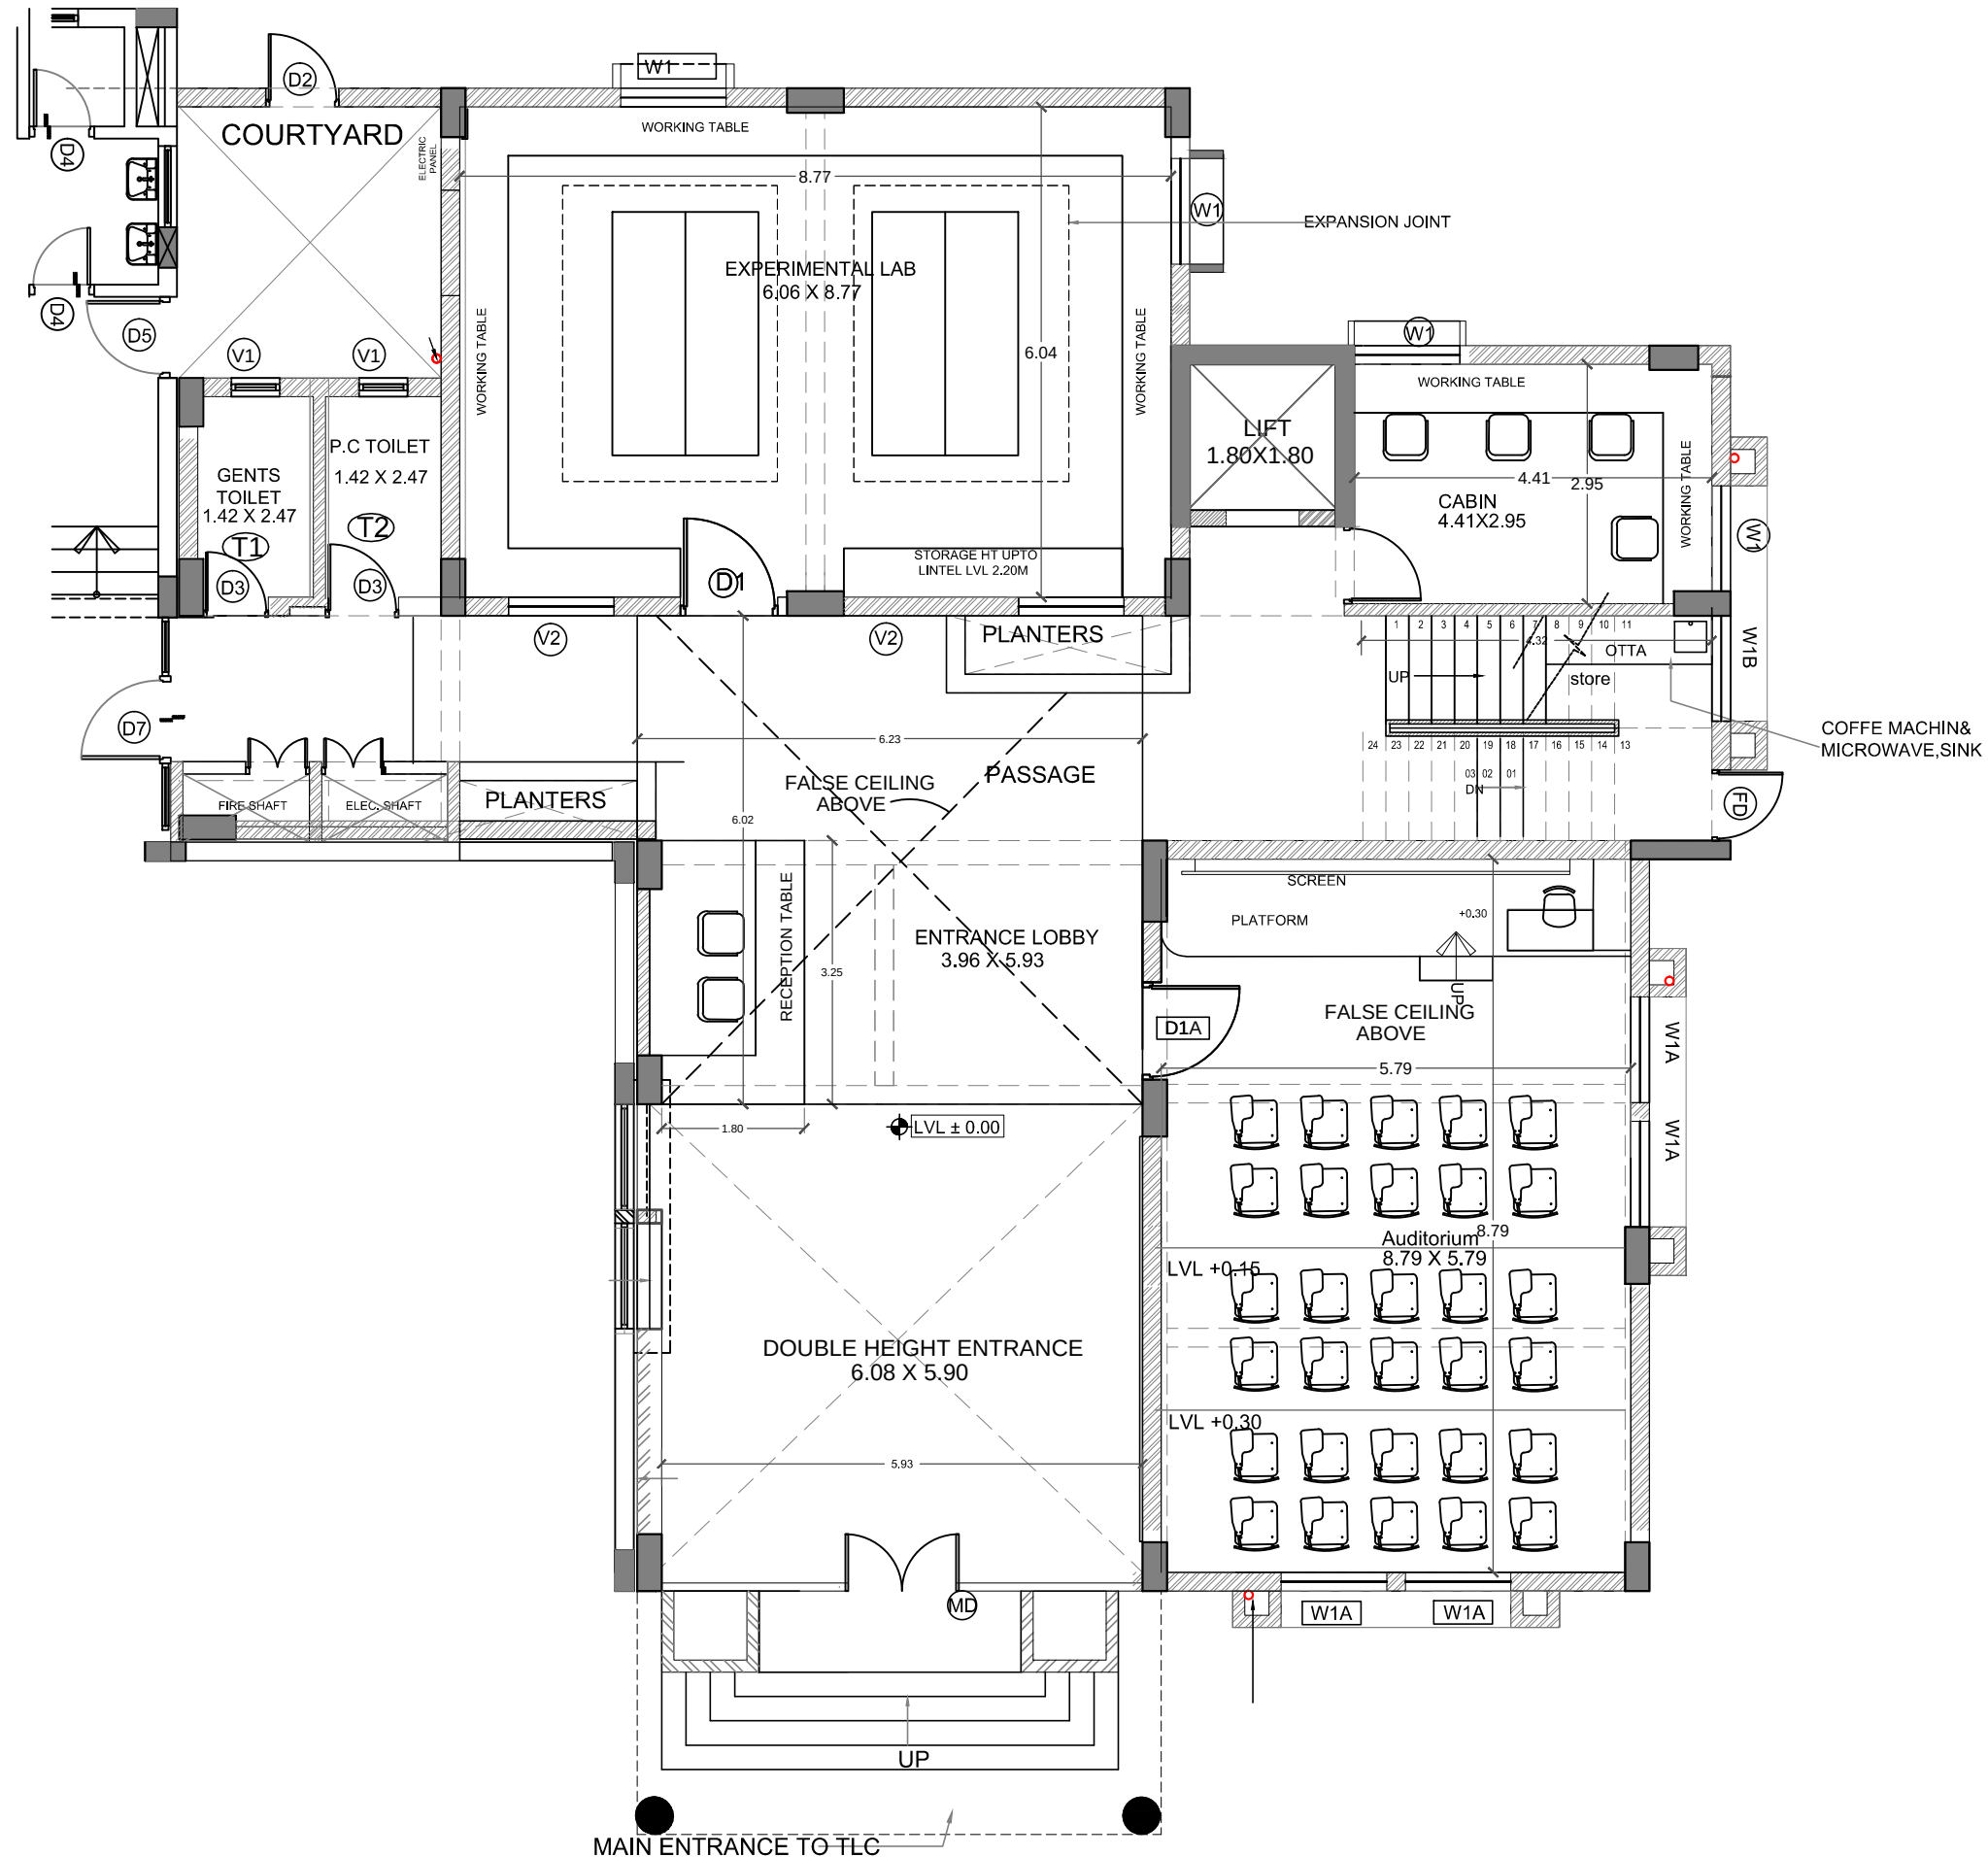


GROUND FLOOR PLAN

GROUND FLOOR FURNITURE LAYOUT

THIS DRAWING IS THE PROPERTY OF MS RAJEEV VISHWASRAO ARCHITECTS (PUNE) IT IS TO BE USED ONLY FOR THE PROJECT FOR WHICH IT WAS PREPARED. IT IS NOT TO BE REPRODUCED OR COPIED WITHOUT THE WRITTEN PERMISSION. © Ms. Rajeev Vishwasrao Architects (Pune) - 2020 FLOOR PLANS - REVISIONS	NO REVISIONS	ALL DIMENSIONS SHALL BE CHECKED & CO-RELATED WITH STRUCTURAL / WORKING DRAWINGS & AMBIGUITY SHALL BE IMMEDIATELY BROUGHT TO THE ATTENTION OF THE ARCHITECT. THIS DRAWING SHOULD NOT BE SCALED & ONLY WRITTEN DIMENSIONS TO BE FOLLOWED. ALL DIMENSIONS ARE IN METERS UNLESS OTHERWISE SPECIFIED.	ARCHITECT RAJEEV VISHWASRAO ARCHITECTS & PLANNERS 'SANSKRITI' 3RD FLOOR, PLOT NO. 2, SARASWATI PETH, PUNE - 411 030. TEL. NO. - 020 24330089, 2433009	TITLE : GROUND FLOOR-FURNITURE LAYOUT PROJECT : TEACHER'S LEARNING CENTRE AT IUCAA CAMPUS CLIENT : THE DIRECTOR IUCAA SCALE : NTS DATE : 31.08.18 DESIGN : KAVITA	DRG. NO. IU/TLC/IN/100 DATE : 17.1.2020

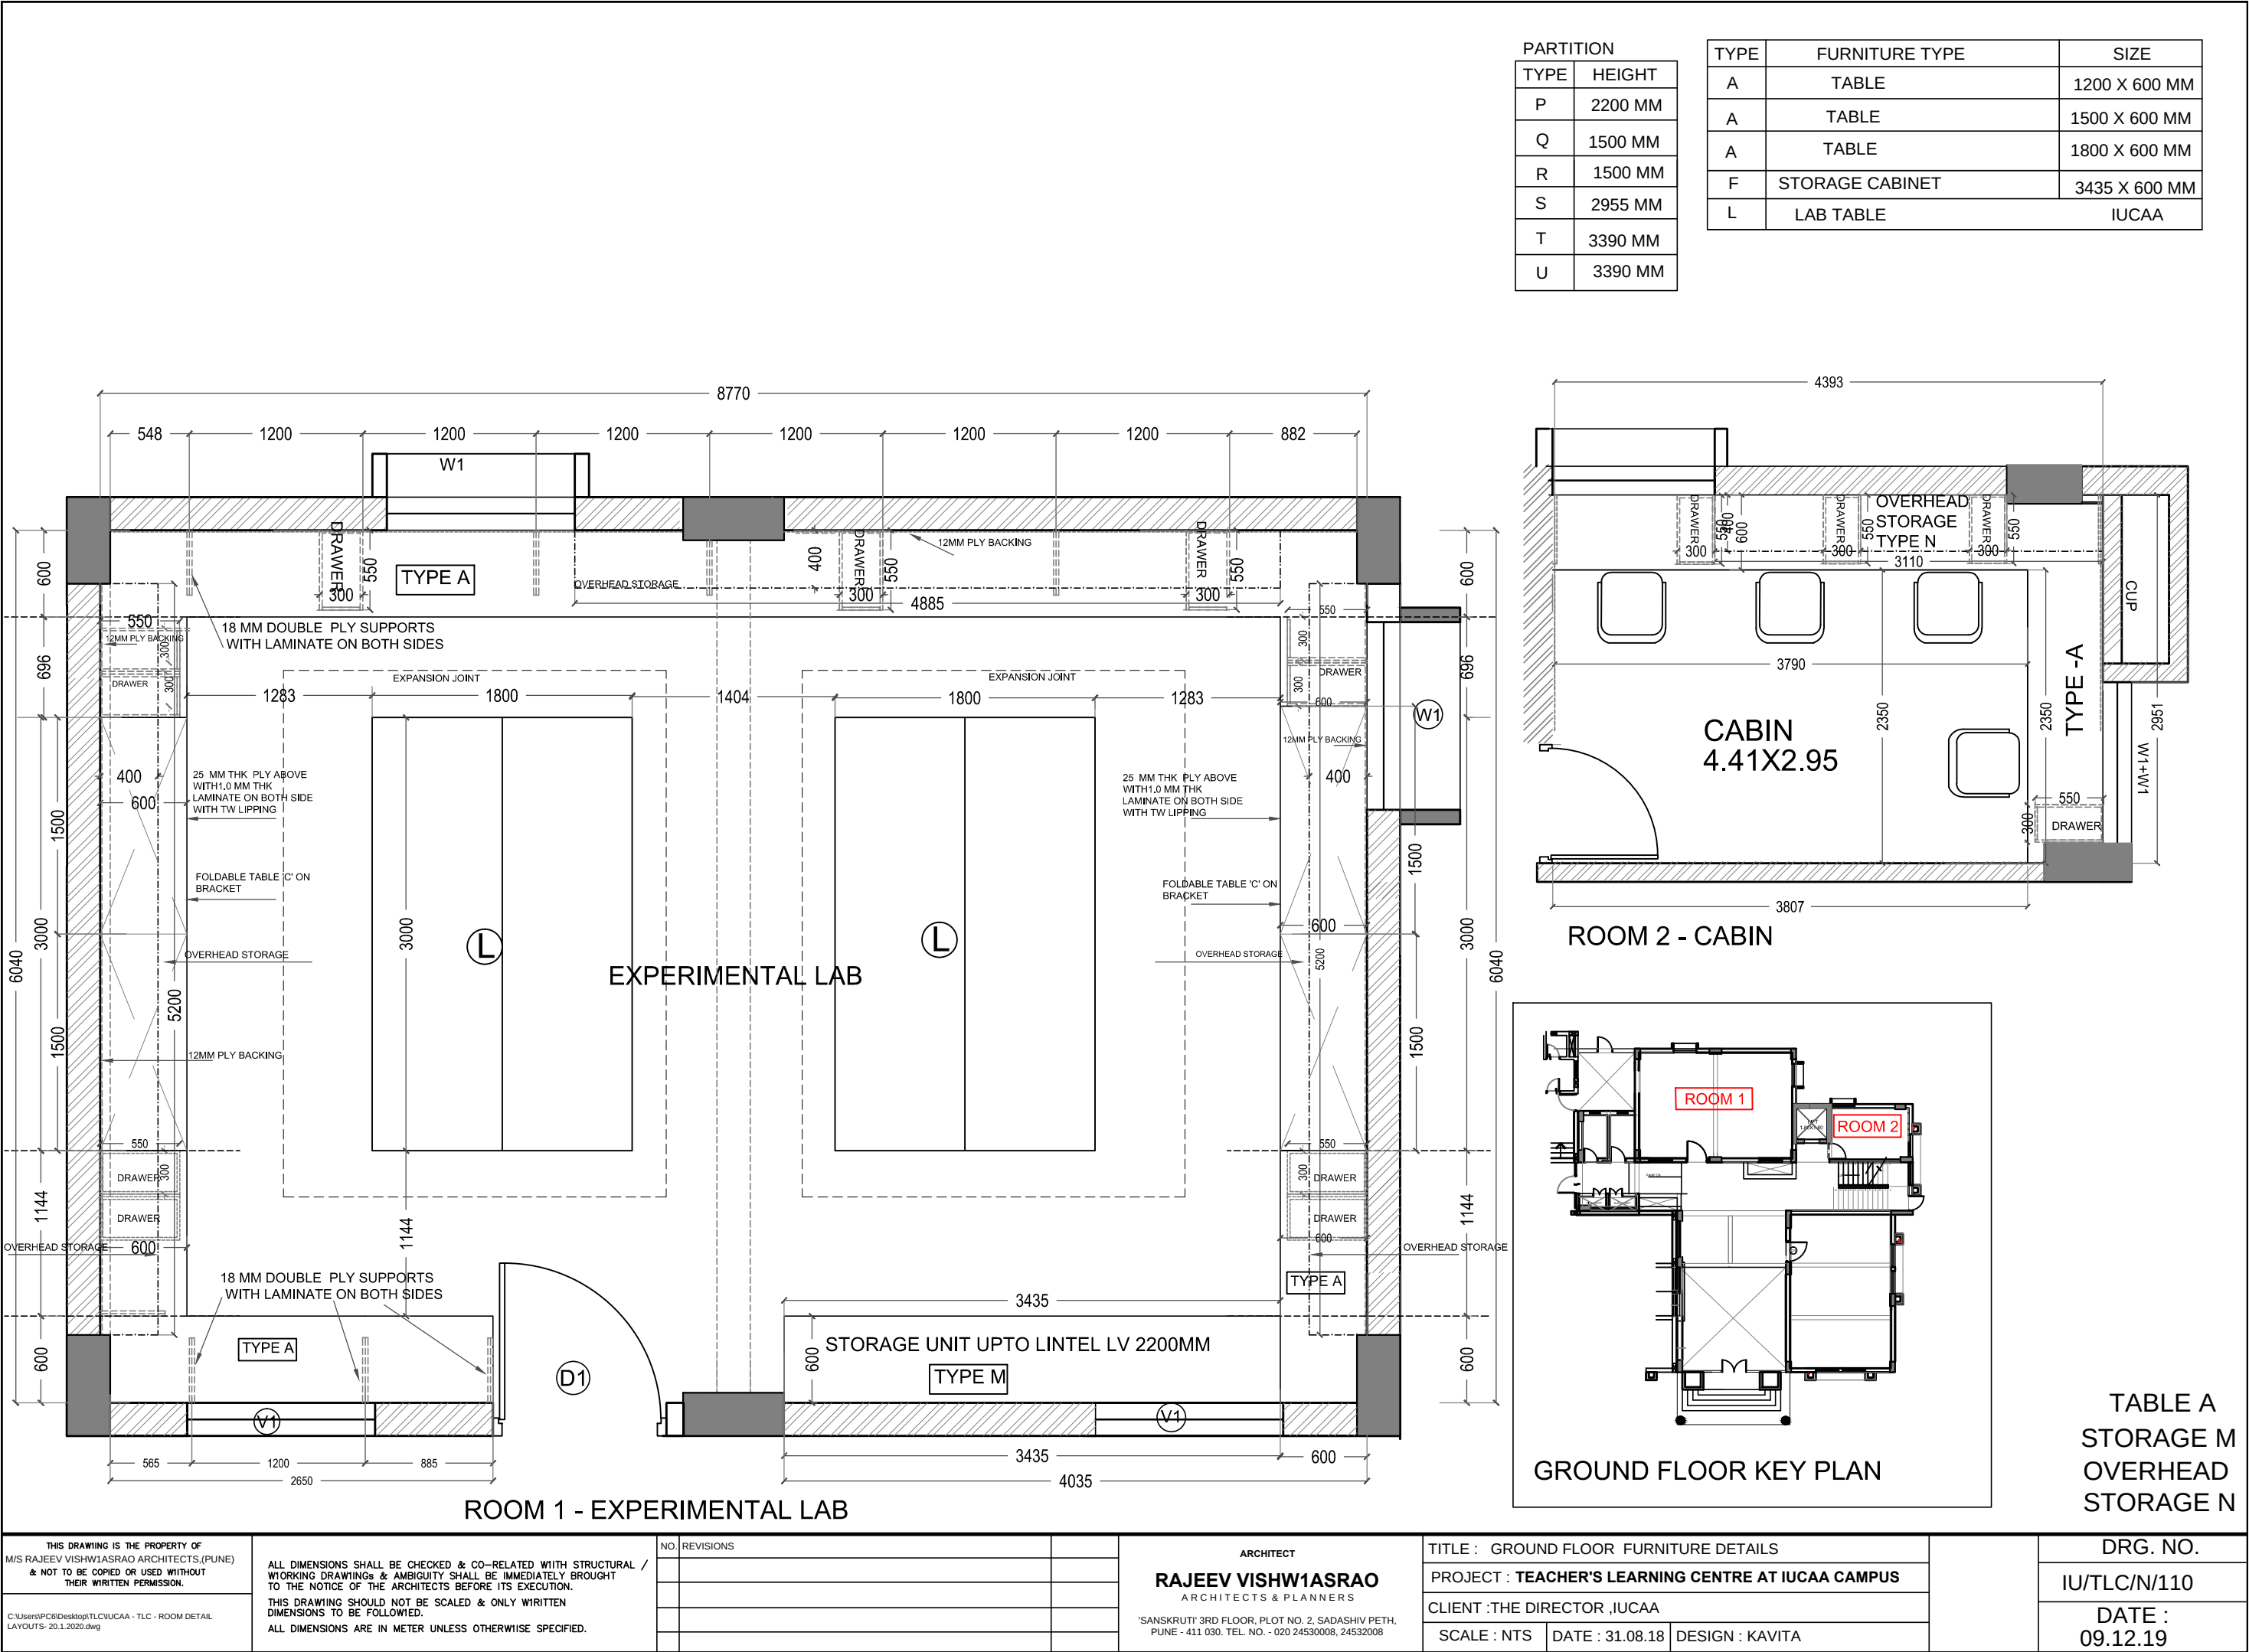


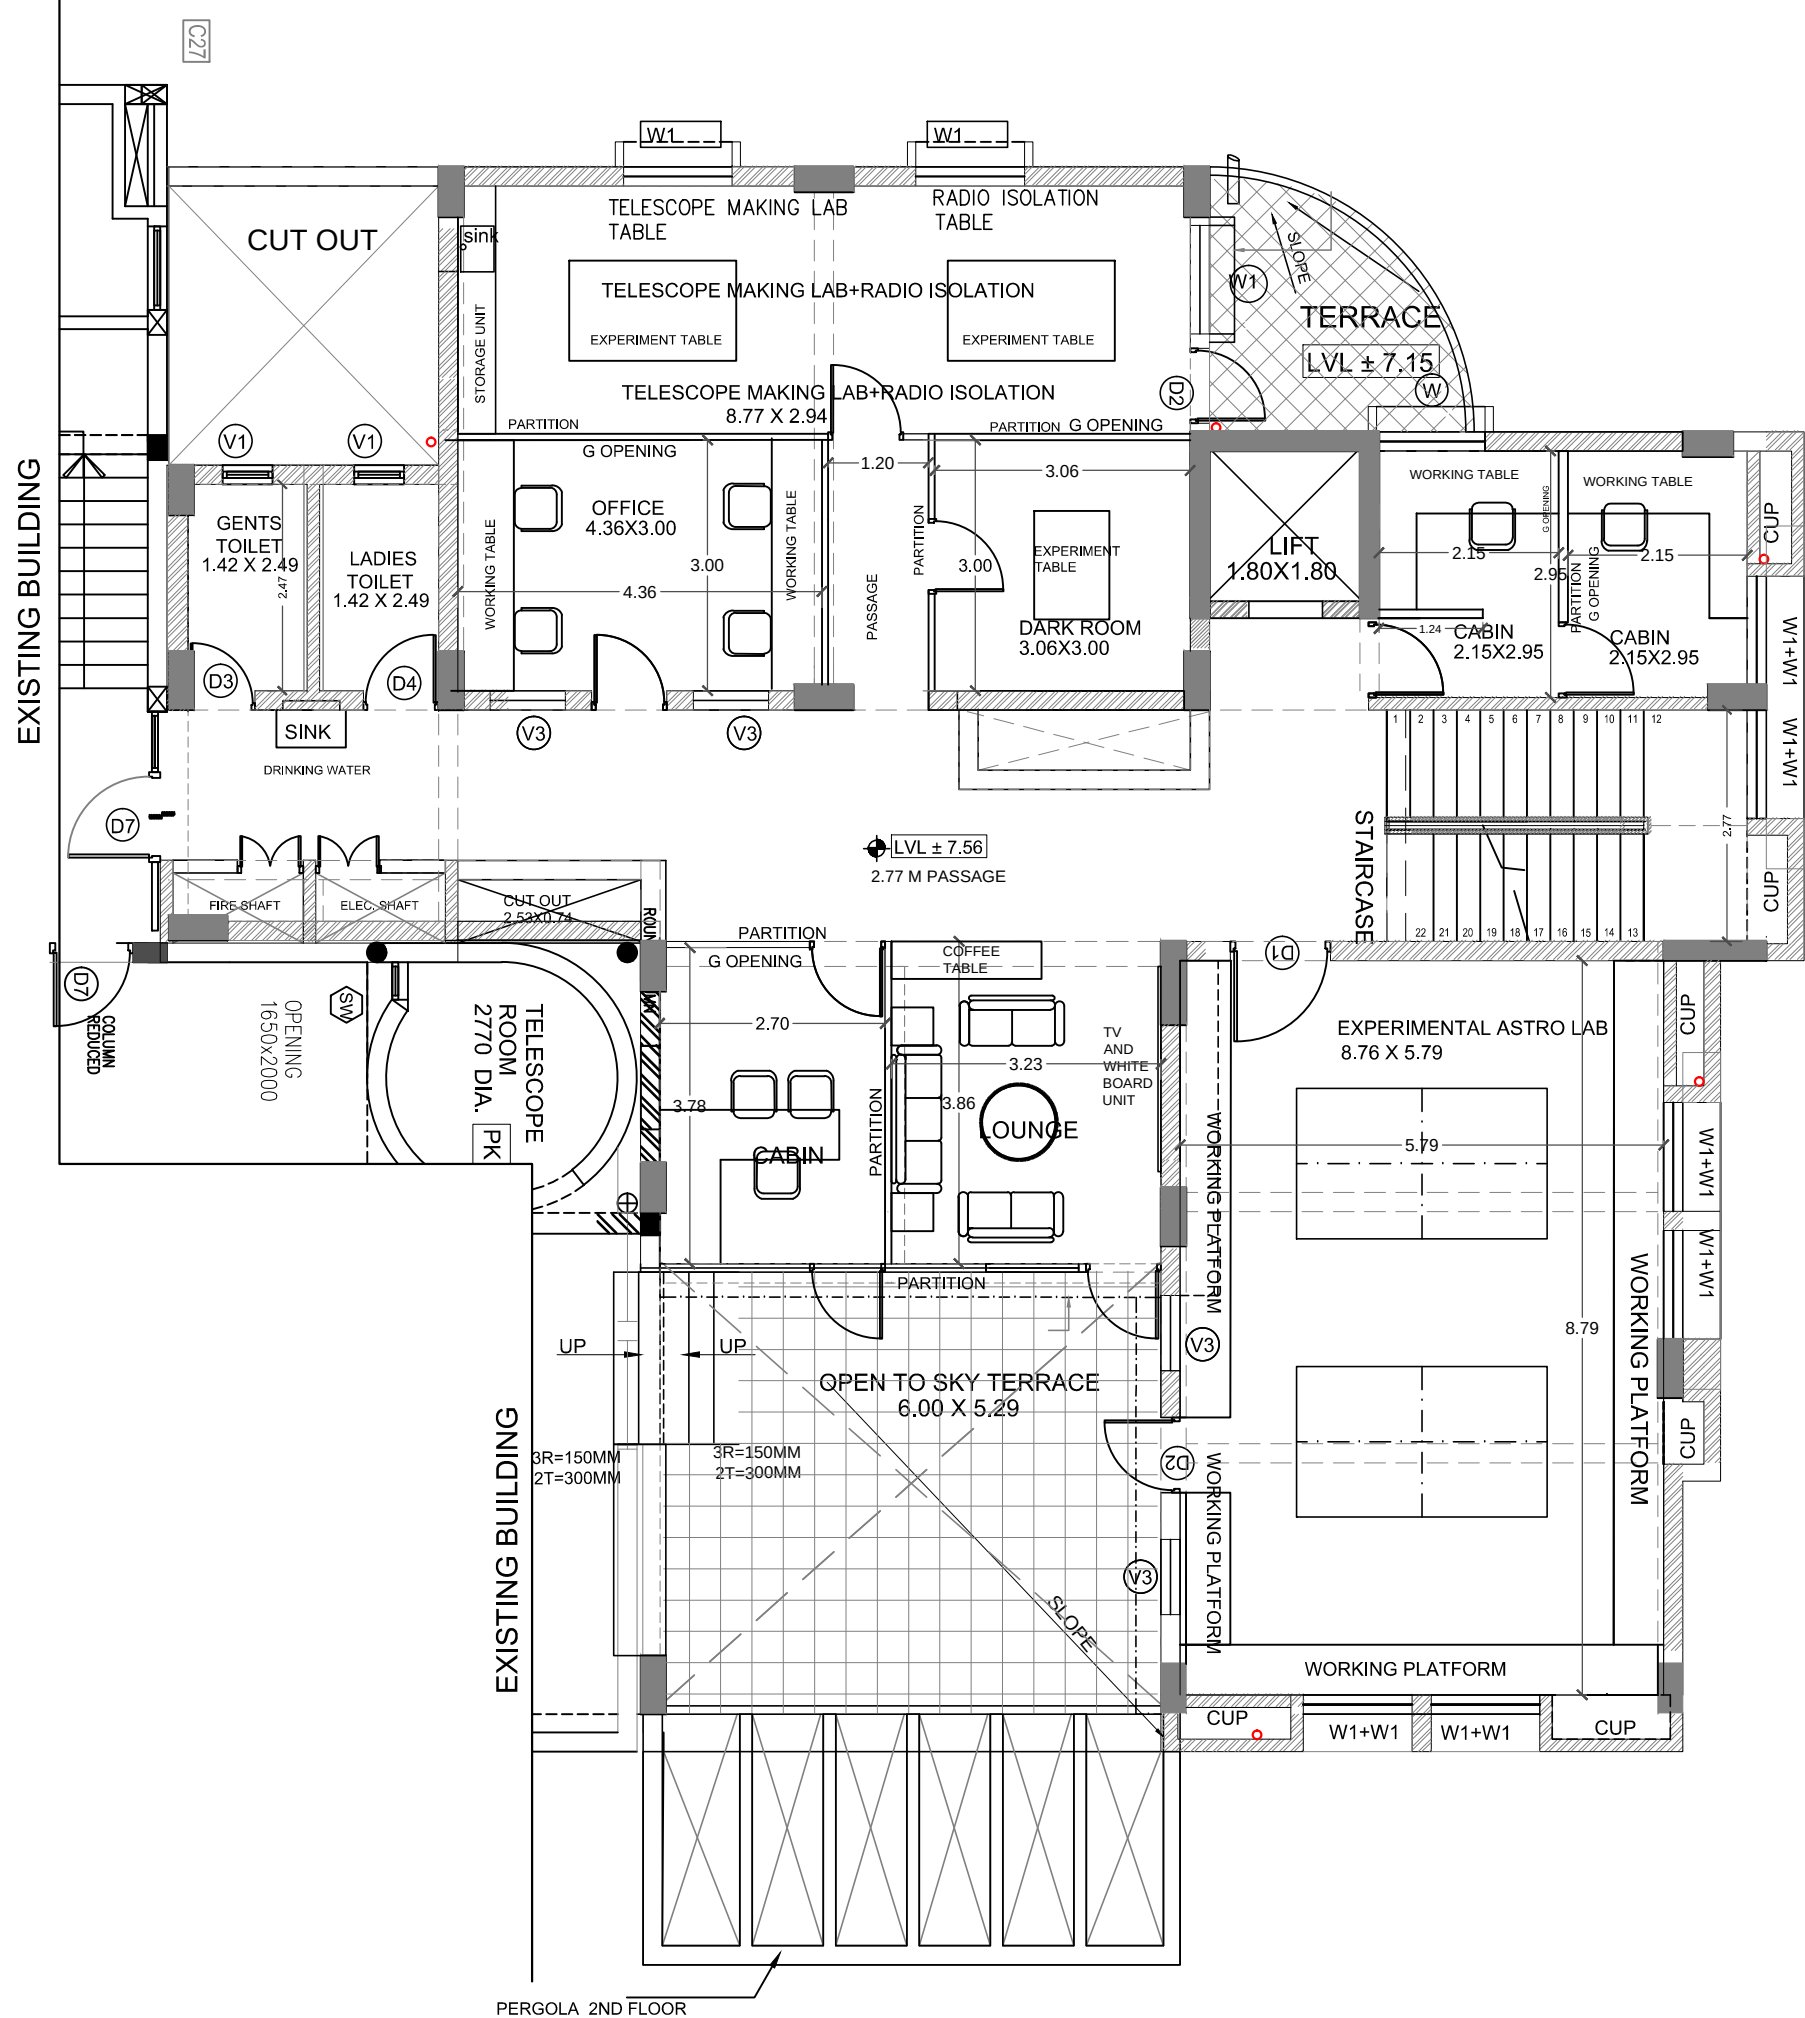



SECOND FLOOR PLAN

SECOND FLOOR FURNITURE LAYOUT

THIS DRAWING IS THE PROPERTY OF M/S RAJEEV VISHWASRAO ARCHITECTS (PUNE) IT IS NOT TO BE REPRODUCED OR COPIED WITHOUT THEIR WRITTEN PERMISSION. C:\Users\pva\Desktop\ATL\IUCAA - 2 LG - FLOOR PLANS - RELAYING.dwg	ALL DIMENSIONS SHALL BE CHECKED & CO-RELATED WITH STRUCTURAL / WORKING DRAWINGS & AMBIGUITY SHALL BE IMMEDIATELY BROUGHT TO THE ATTENTION OF THE ARCHITECT. THIS DRAWING SHOULD NOT BE SCALED & ONLY WRITTEN DIMENSIONS TO BE FOLLOWED. ALL DIMENSIONS ARE IN METERS UNLESS OTHERWISE SPECIFIED.	NO REVISIONS	ARCHITECT RAJEEV VISHWASRAO ARCHITECTS & PLANNERS 'SANSKRITI' 3RD FLOOR, PLOT NO. 2, SARASWATI PETH, PUNE - 411 030. TEL. NO. - 020 24530089, 2453009	TITLE : SECOND FLOOR-FURNITURE LAYOUT PROJECT : TEACHER'S LEARNING CENTRE AT IUCAA CAMPUS CLIENT : THE DIRECTOR IUCAA SCALE : NTS DATE : 31.08.18 DESIGN : KAVITA	DRG. NO. IU/TLG/IN/300 DATE : 17.1.2020

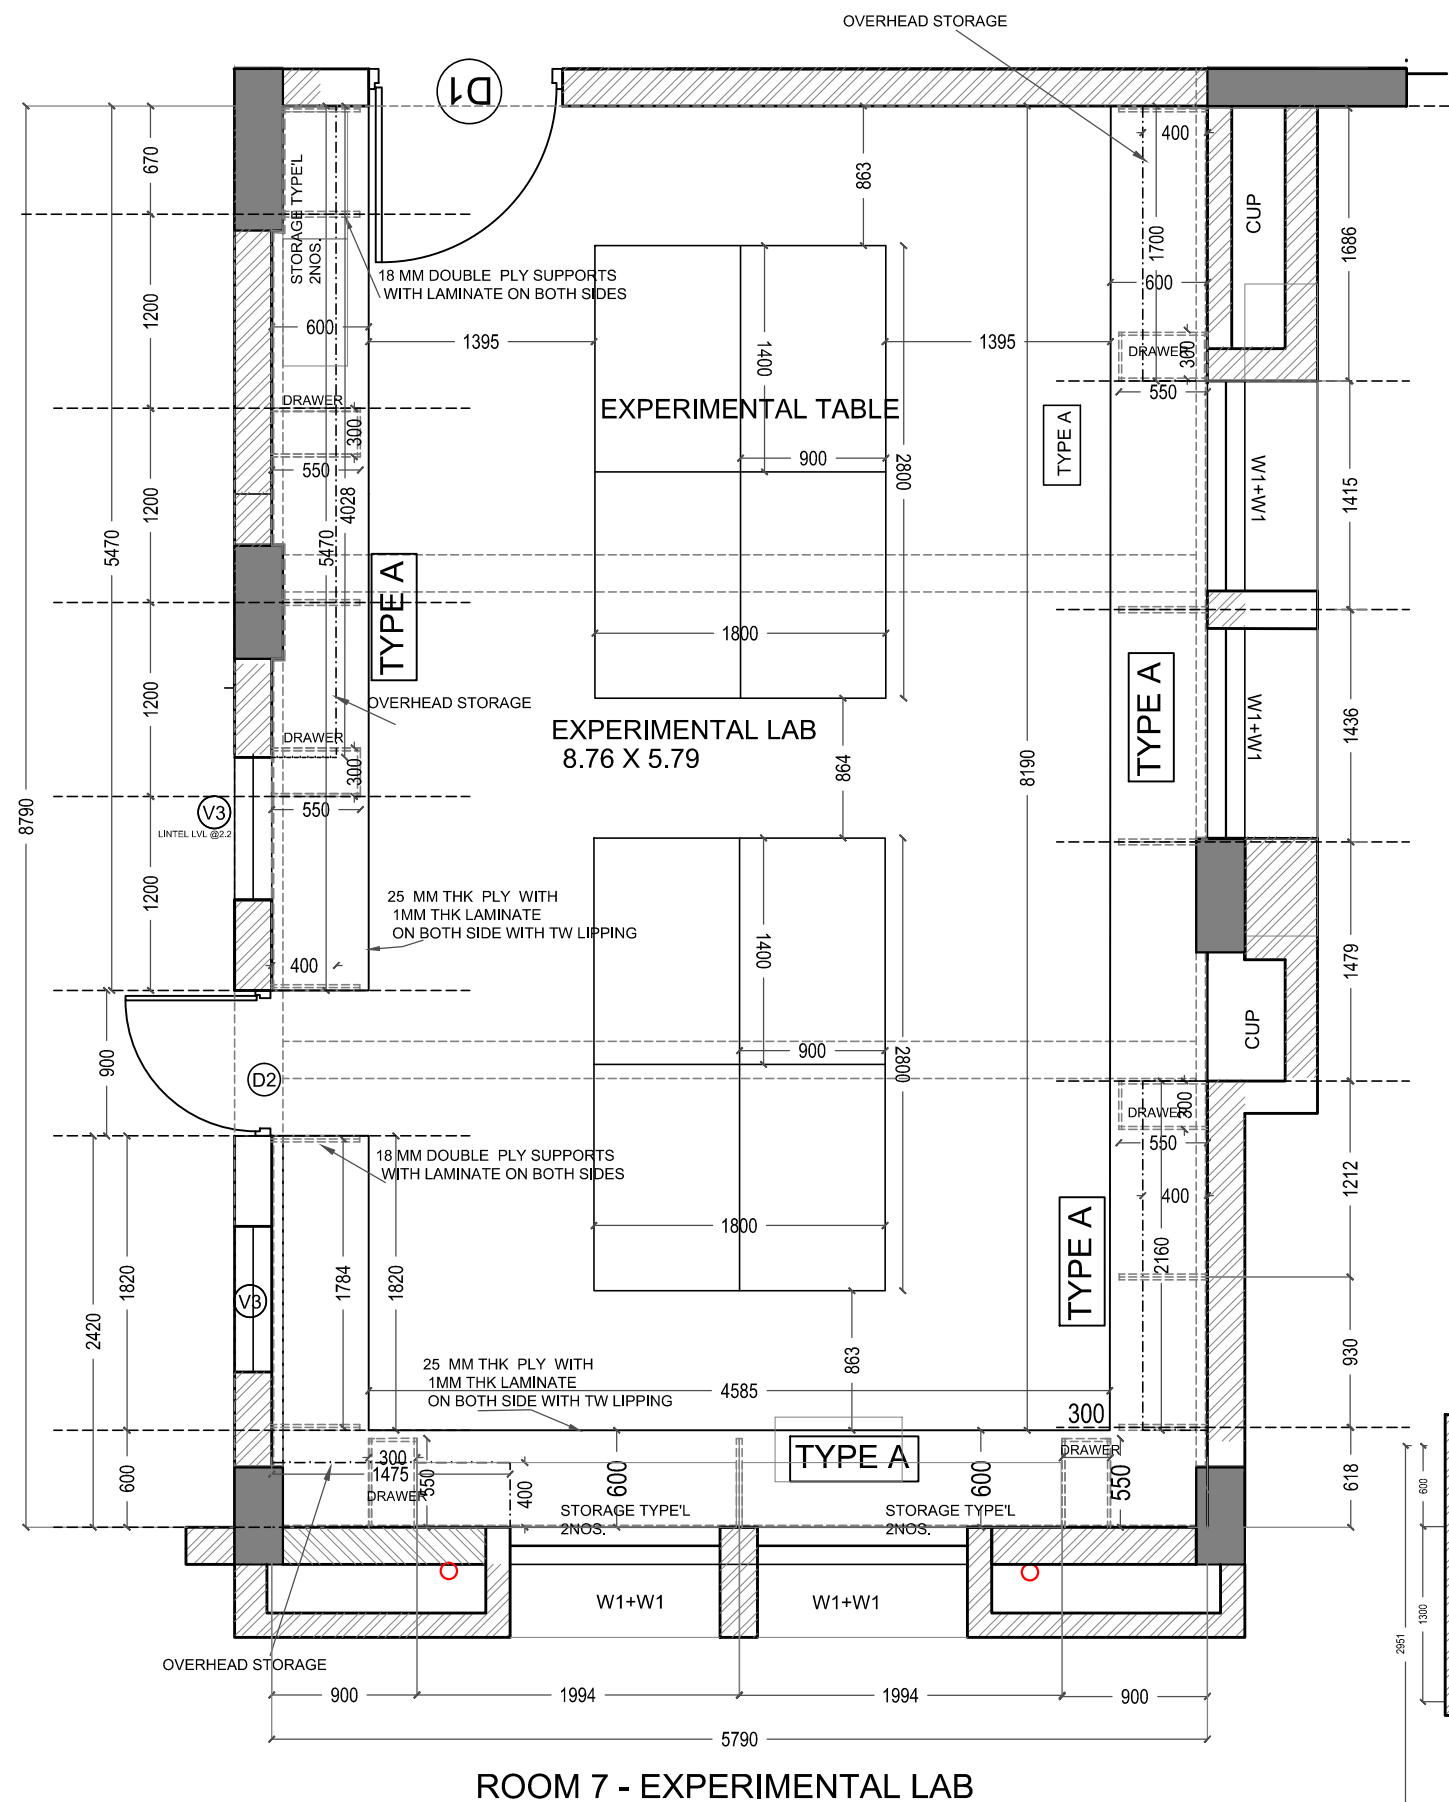

PARTITION	
TYPE	HEIGHT
P	2200 MM
Q	1500 MM
R	1500 MM
S	2955 MM
T	3390 MM
U	3390 MM

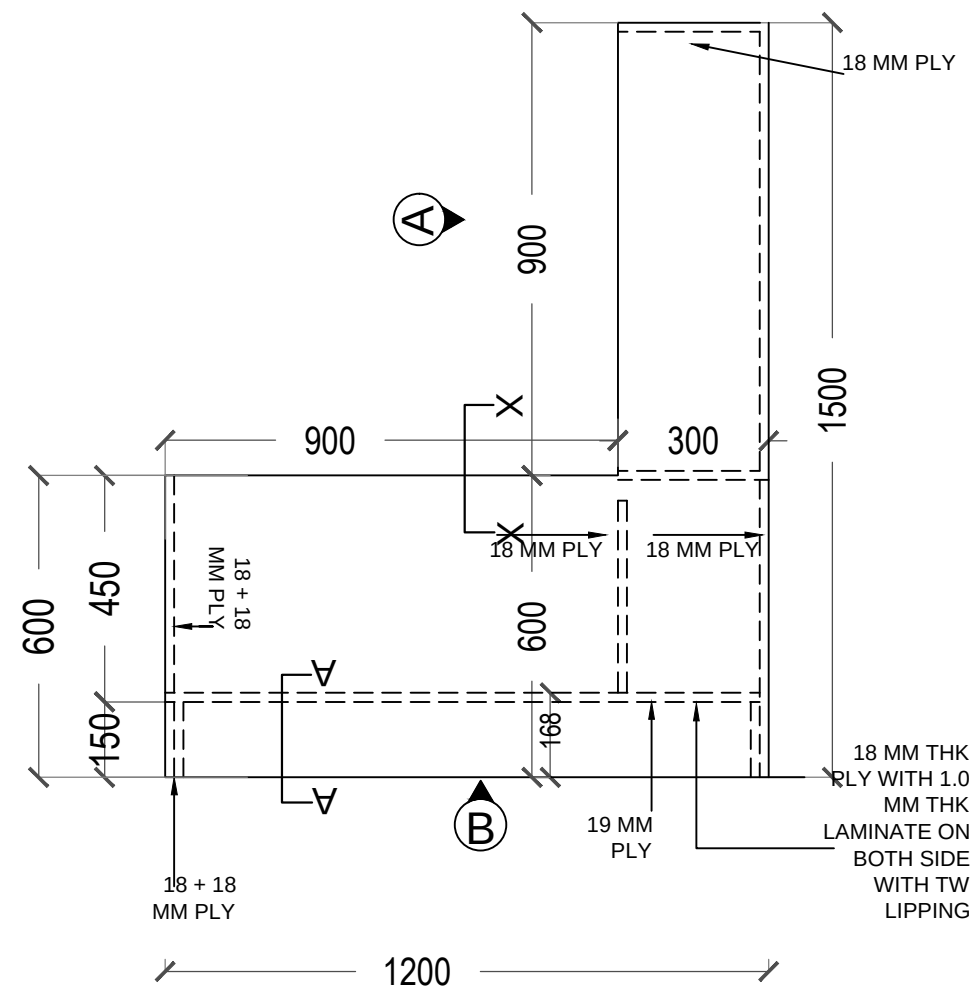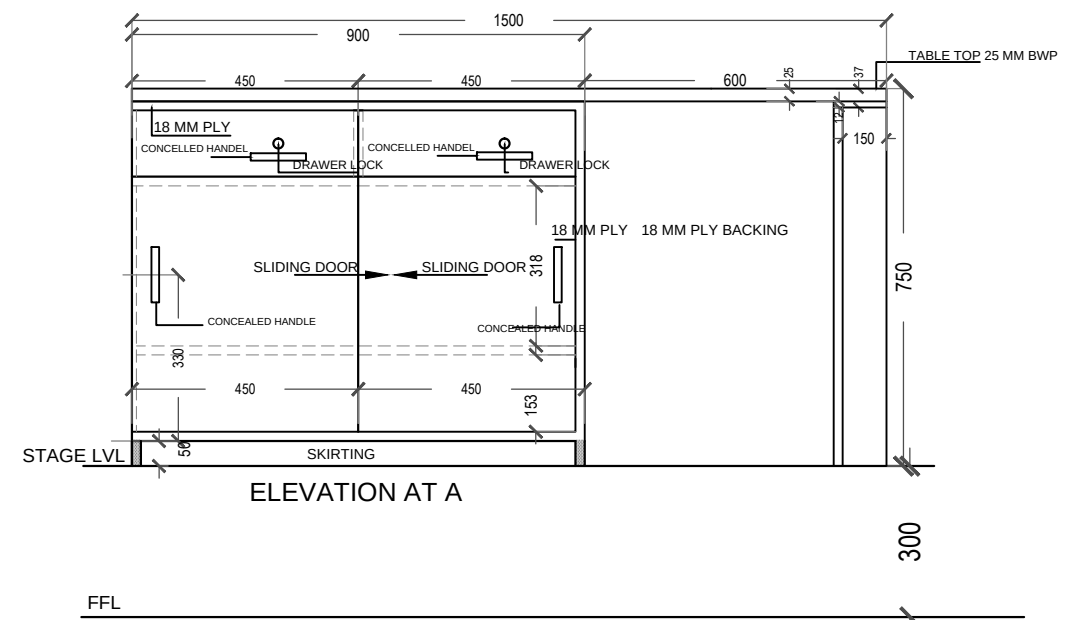

PLAN ABOVE TABLE TOP



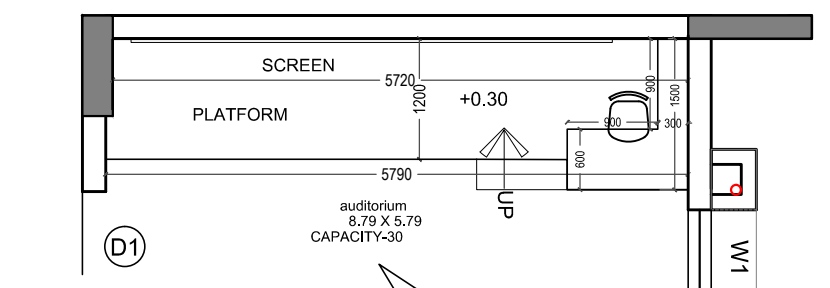


TABLE TYPE 'C'


ALL DIMENSIONS SHALL BE CHECKED & CO-RELATED WITH STRUCTURAL / MECHANICAL DRAWINGS BROUGHT TO THE NOTICE OF THE ARCHITECTS BEFORE ITS EXECUTION. THIS DRAWING SHOULD NOT BE SCALED & ONLY WRITTEN DIMENSIONS TO BE FOLLOWED. ALL DIMENSIONS ARE IN METER UNLESS OTHERWISE SPECIFIED.	NO. REVISIONS		ARCHITECT RAJEEV VISHWASRAO ARCHITECTS & PLANNERS "SANSKRUTI" 3RD FLOOR, PLOT NO. 2, SADASHIV PEETH, PUNE - 411 030. TEL. NO. - 020 24530008, 24532088		PROJECT : TEACHER'S LEARNING CENTRE AT IUCAA CAMPUS CLIENT : THE DIRECTOR, IUCAA SCALE : NTS DATE : 31.08.18 DESIGN : KAVITA	DRG. NO. : IU/TLC/IN/125 DATE : 17.1.2020
	MS BALESH VISHWASRAO ARCHITECTS (PUNE) & NOT TO BE COPIED OR USED WITHOUT THEIR WRITTEN PERMISSION.	C:\Users\G02ashv\Documents\IUCAA - TLC - STAGE RECORDING TABLE ITA 5 - 201 2001.dwg 17.01.2020				

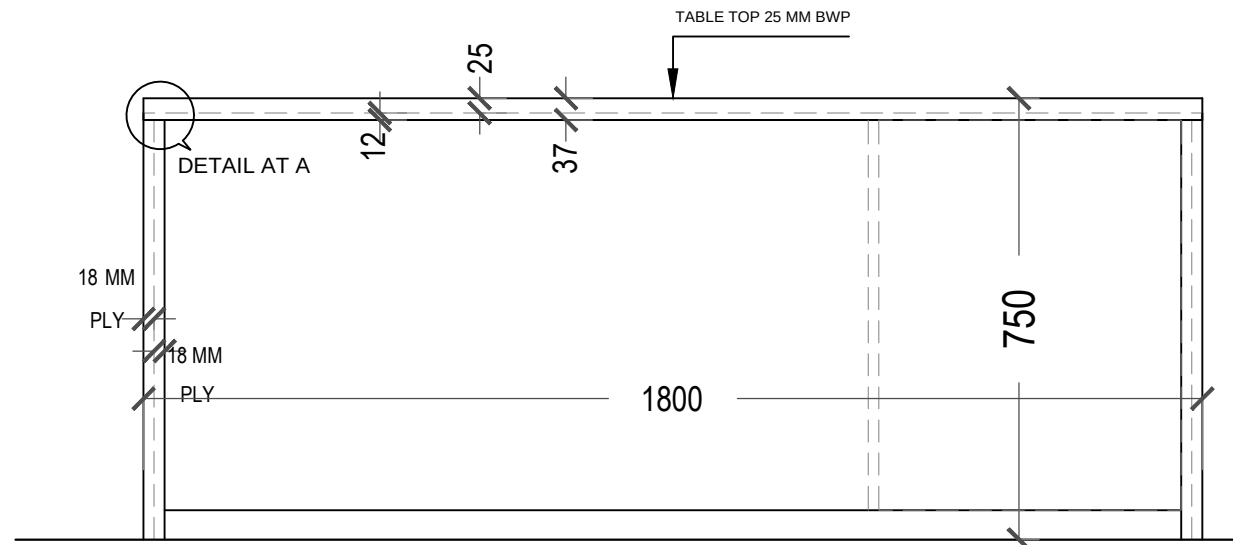


ELEVATION AT B

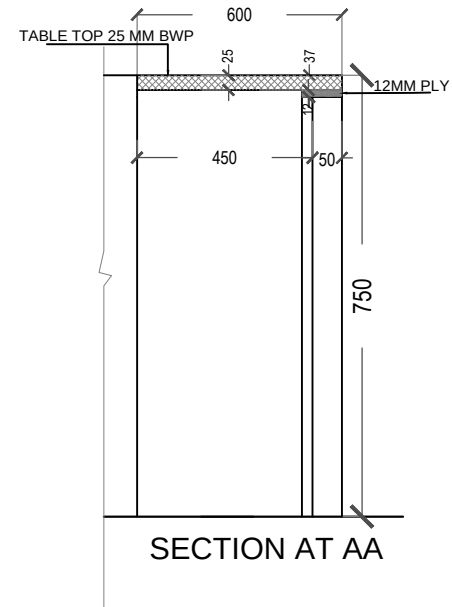


SECTION AT AA

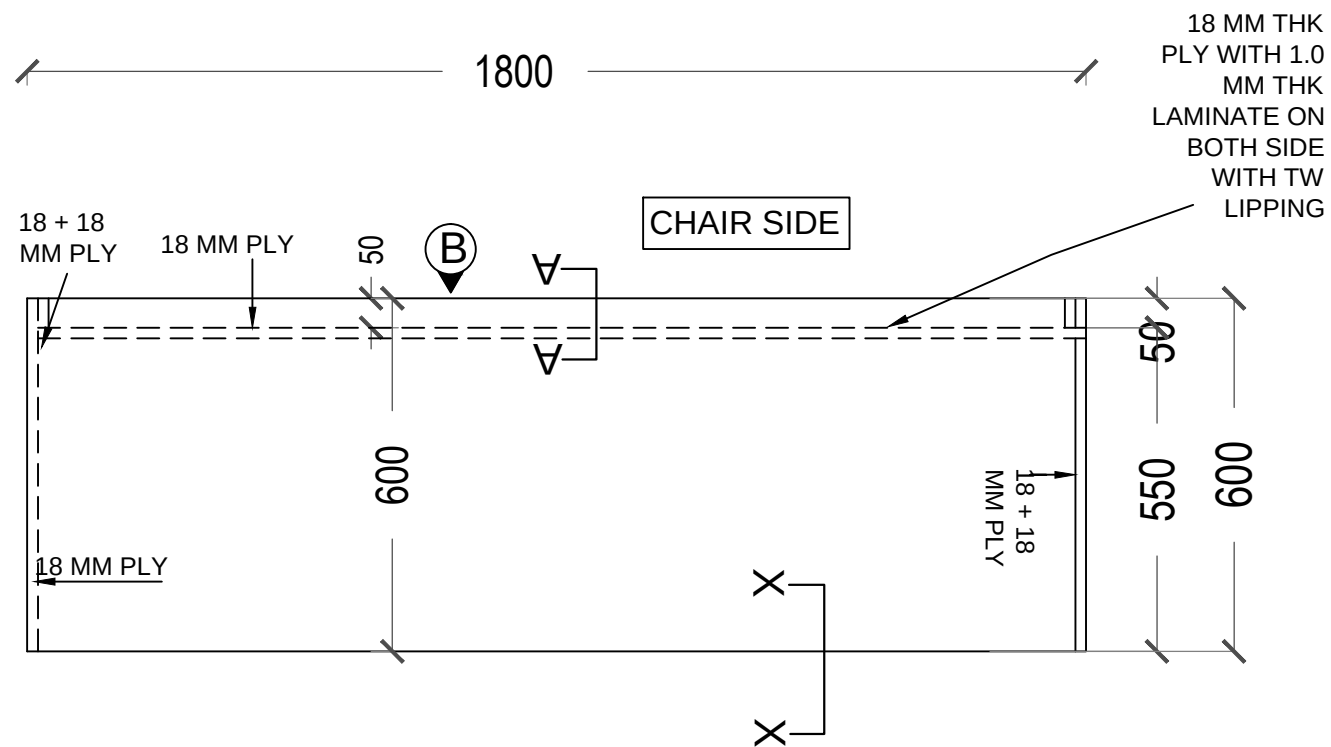


PLAN ABOVE TABLE TOP

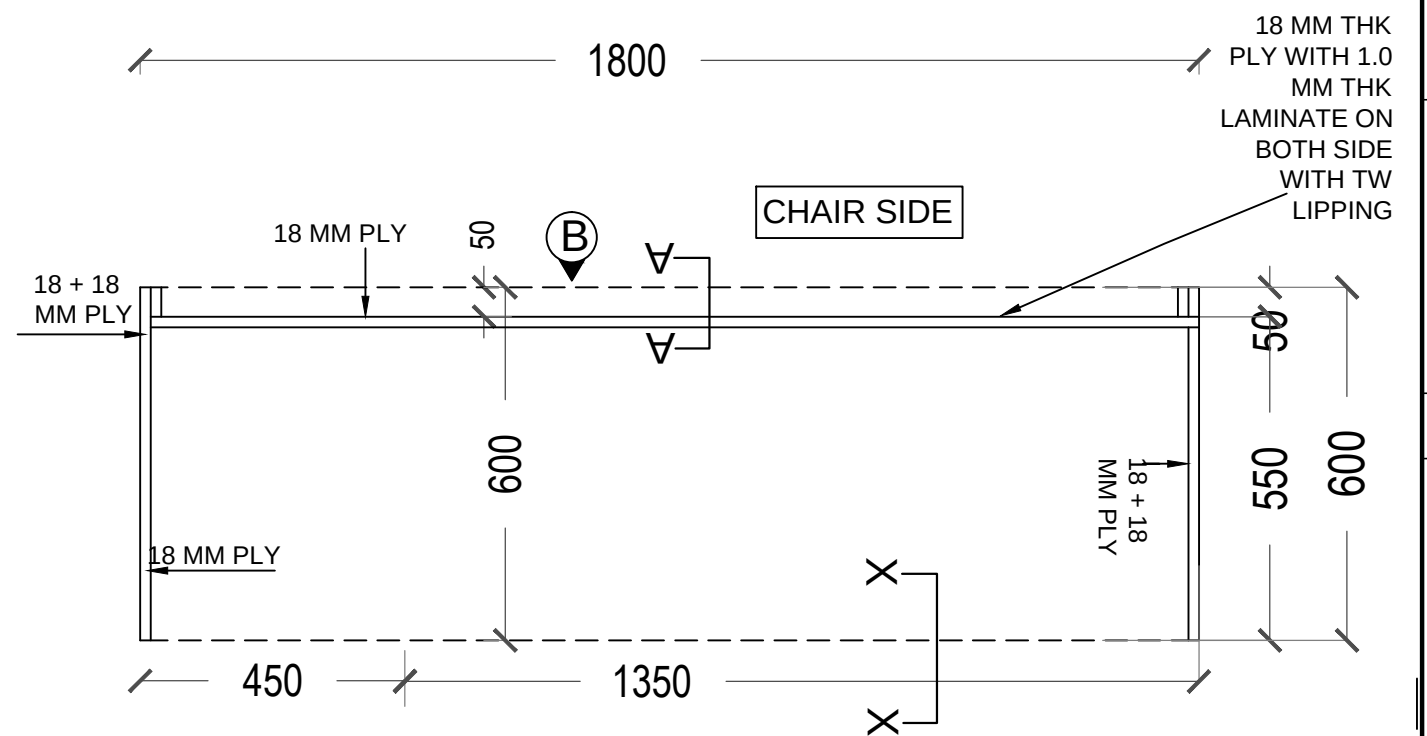

PLAN BELOW TABLE TOP

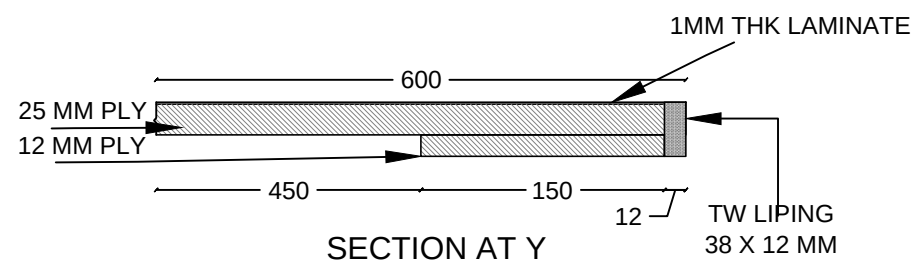


SECTION AT Y

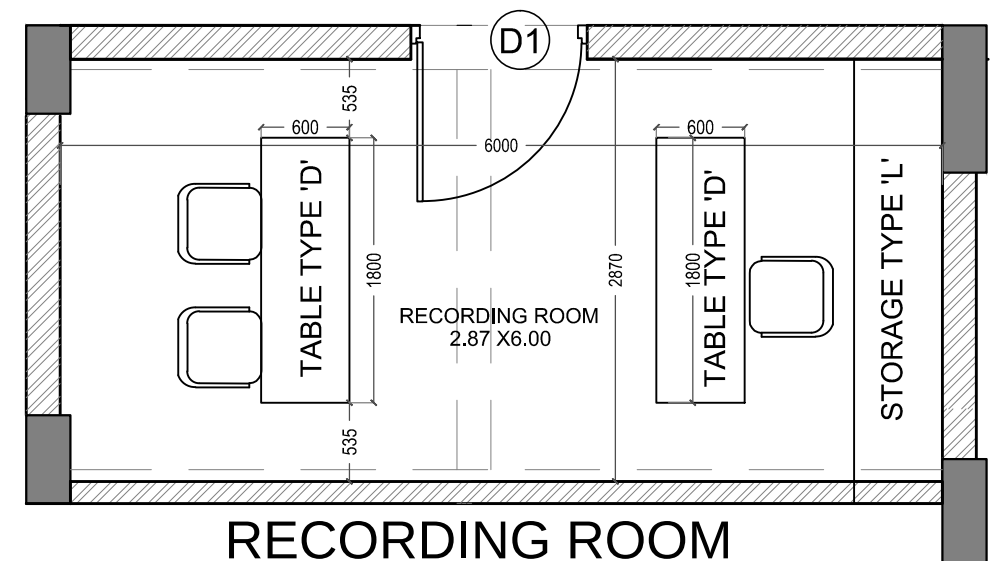

RECORDING ROOM
TABLE TYPE 'D'


THE DRAWING IS THE PROPERTY OF MS RAJEEV VISHWASRAO ARCHITECTS (PUNE) IT IS TO BE USED ONLY FOR THE PROJECT FOR WHICH IT WAS PREPARED. IT IS NOT TO BE REPRODUCED OR TRANSMITTED IN ANY FORM OR BY ANY MEANS, ELECTRONIC OR MECHANICAL, INCLUDING PHOTOCOPYING, RECORDING, OR BY ANY INFORMATION STORAGE AND RETRIEVAL SYSTEM, WITHOUT THE WRITTEN PERMISSION. C:\Users\PC\Downloads\IUCAA - TLG - STAGE RECORDING TABLE TYPE 'D' - 30.1.2020.dwg	NO REVISIONS	ALL DIMENSIONS SHALL BE CHECKED & CO-RELATED WITH STRUCTURAL / WORKING DRAWINGS & AMBIGUITY SHALL BE IMMEDIATELY BROUGHT TO THE ARCHITECT'S ATTENTION. THIS DRAWING SHOULD NOT BE SCALED & ONLY DIMENSIONS TO BE FOLLOWED. ALL DIMENSIONS ARE IN METERS UNLESS OTHERWISE SPECIFIED.	ARCHITECT RAJEEV VISHWASRAO ARCHITECTS & PLANNERS SANSKRUTI 3RD FLOOR PLOT NO. 2, SADASHIV PEETH, PUNE - 411 001. TEL. NO. : 020 24530068, 24532028	TITLE : RECORDING ROOM TABLE DETAILS		DRG. NO.
				PROJECT : TEACHER'S LEARNING CENTRE AT IUCAA CAMPUS		IU/TLG/IIN/240
				CLIENT : THE DIRECTOR IUCAA		DATE :
				SCALE : NTS		20.1.2020
				DATE : 31.08.18		DESIGN : KAVITA

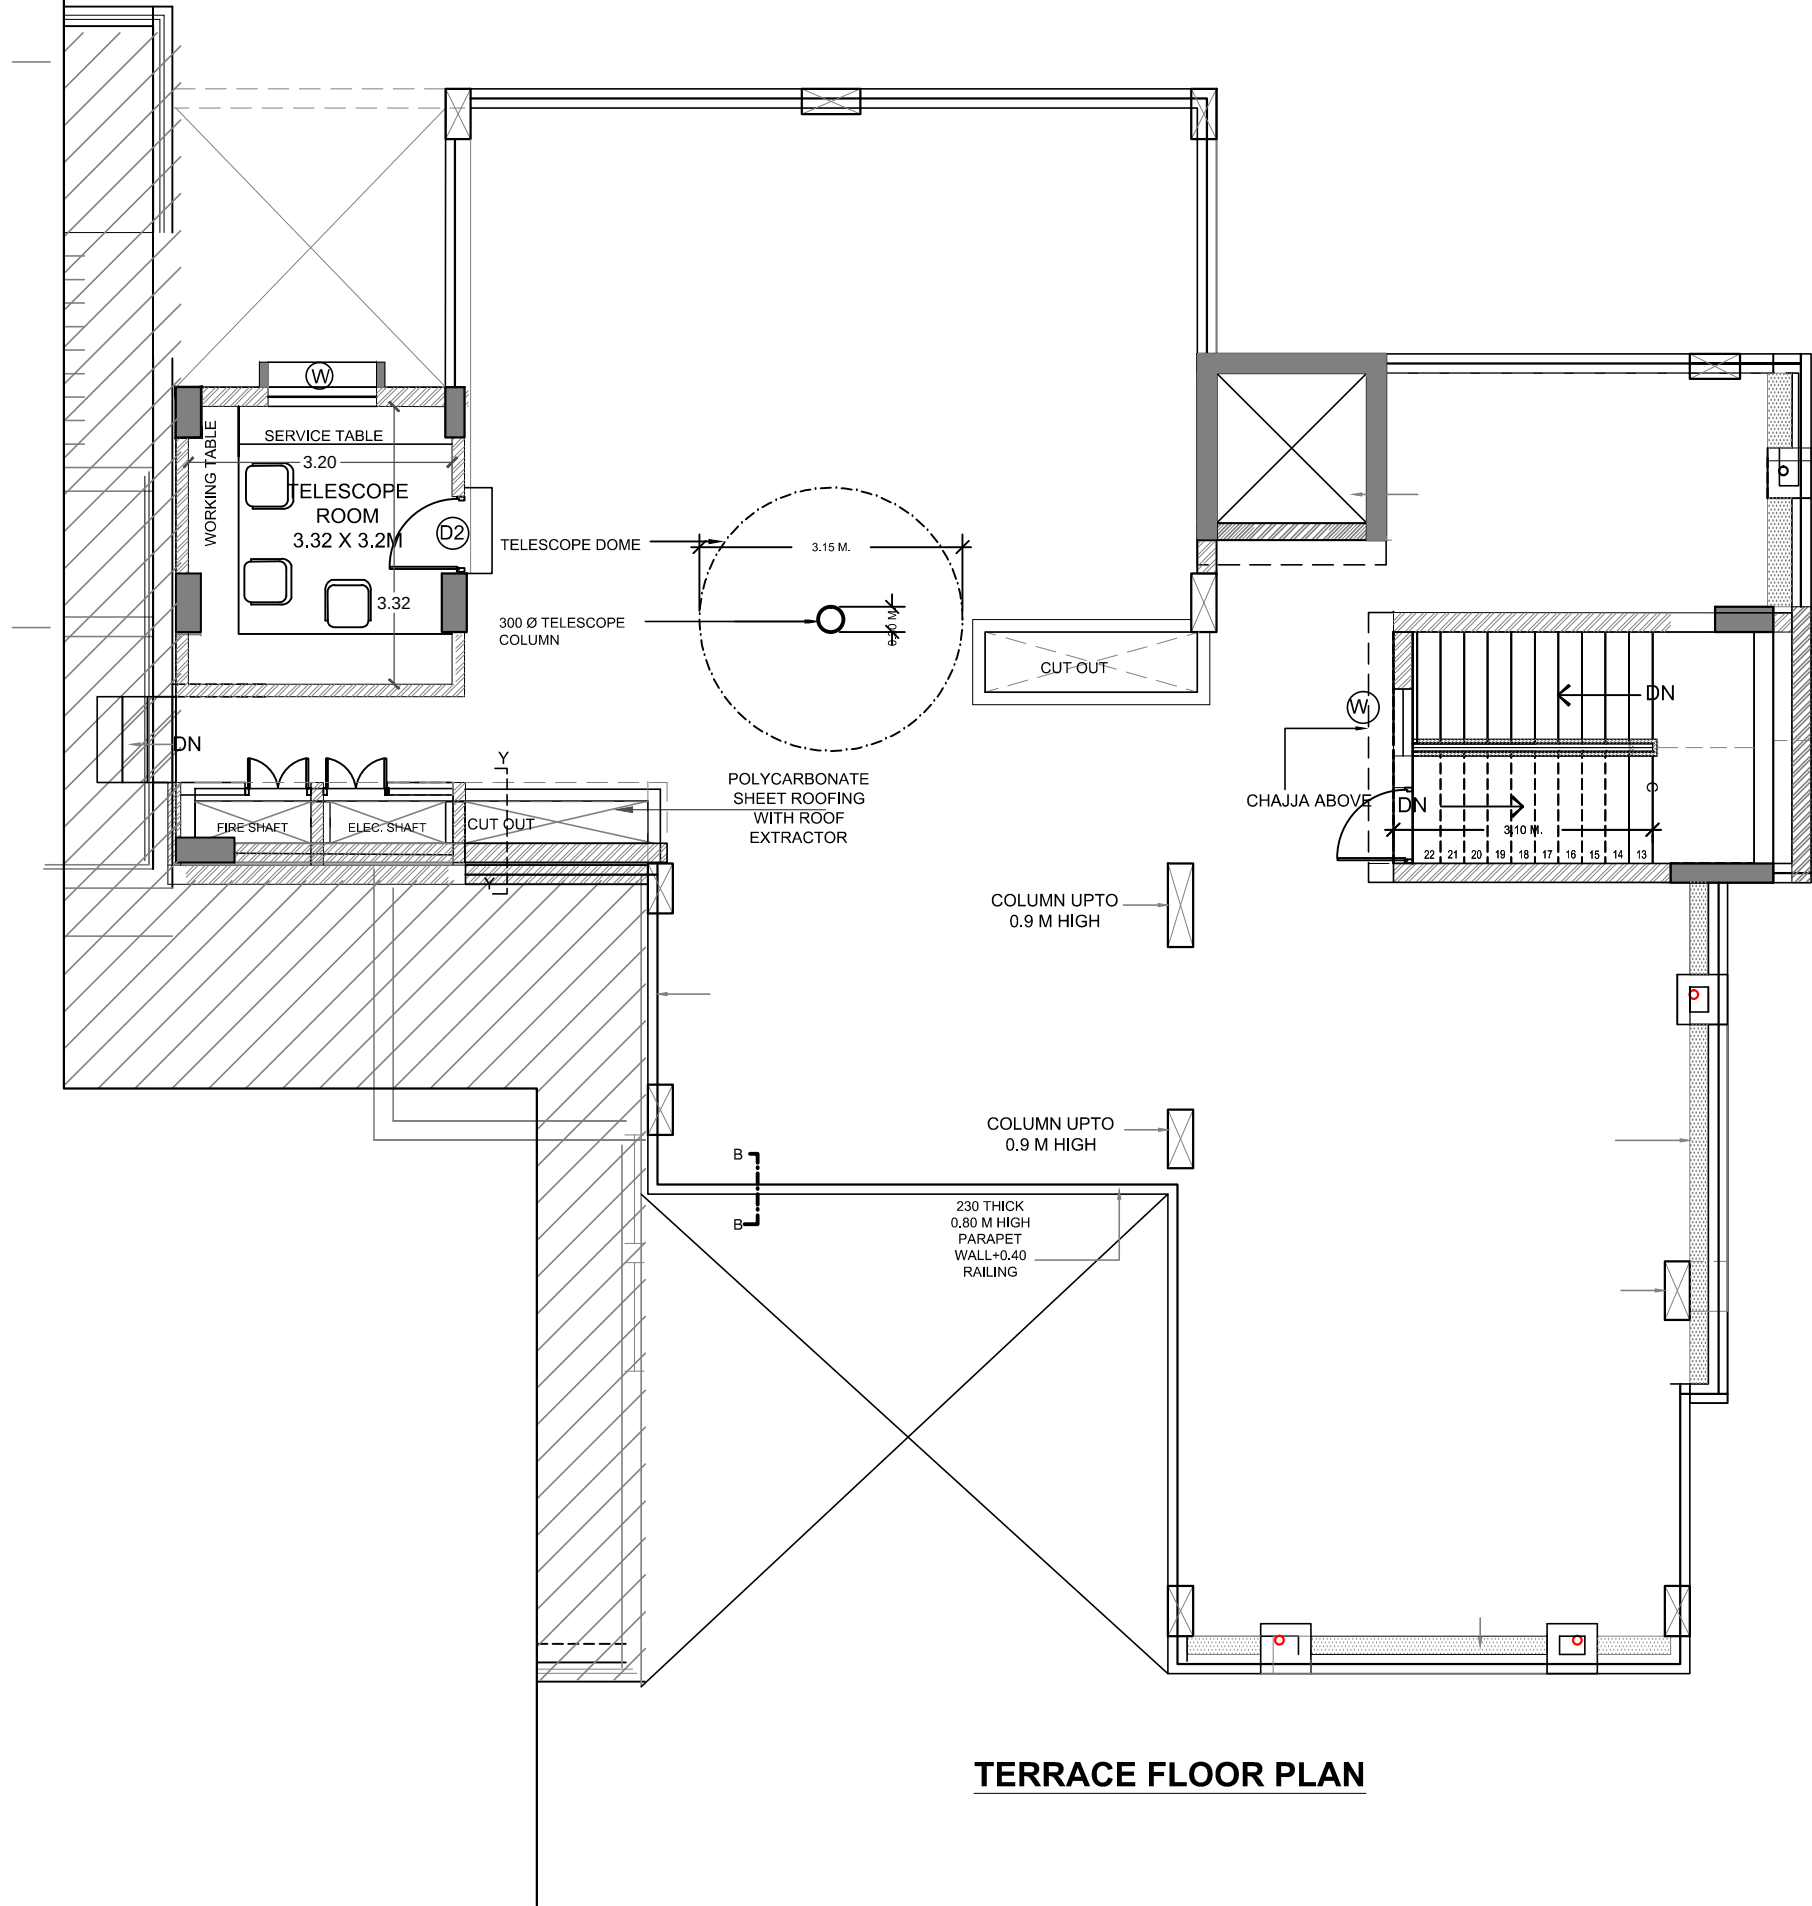

TERRACE FLOOR PLAN

TERRACE FLOOR
FURNITURE LAYOUT

THIS DRAWING IS THE PROPERTY OF M/S RAJEEV VISHWASRAO ARCHITECTS (PUNE) AND IS NOT TO BE REPRODUCED OR COPIED IN ANY MANNER WITHOUT THEIR WRITTEN PERMISSION. C:\Users\pvc\Desktop\ATL\IUCAA - TLC - FLOOR PLANS - RELEASE.dwg	NO. REVISIONS	ARCHITECT RAJEEV VISHWASRAO ARCHITECTS & PLANNERS 'SANSKRITI' 3RD FLOOR, PLOT NO. 2, SARASWATI PETH, PUNE - 411 030. TEL. NO. - 020 24330009, 24330008	TITLE : TERRACE FLOOR-FURNITURE LAYOUT		DRG. NO.
			PROJECT : TEACHER'S LEARNING CENTRE AT IUCAA CAMPUS		IU/TLC/IN/400
			CLIENT: THE DIRECTOR IUCAA		DATE :
			SCALE : NTS DATE : 31.08.18 DESIGN : KAVITA		17.1.2020

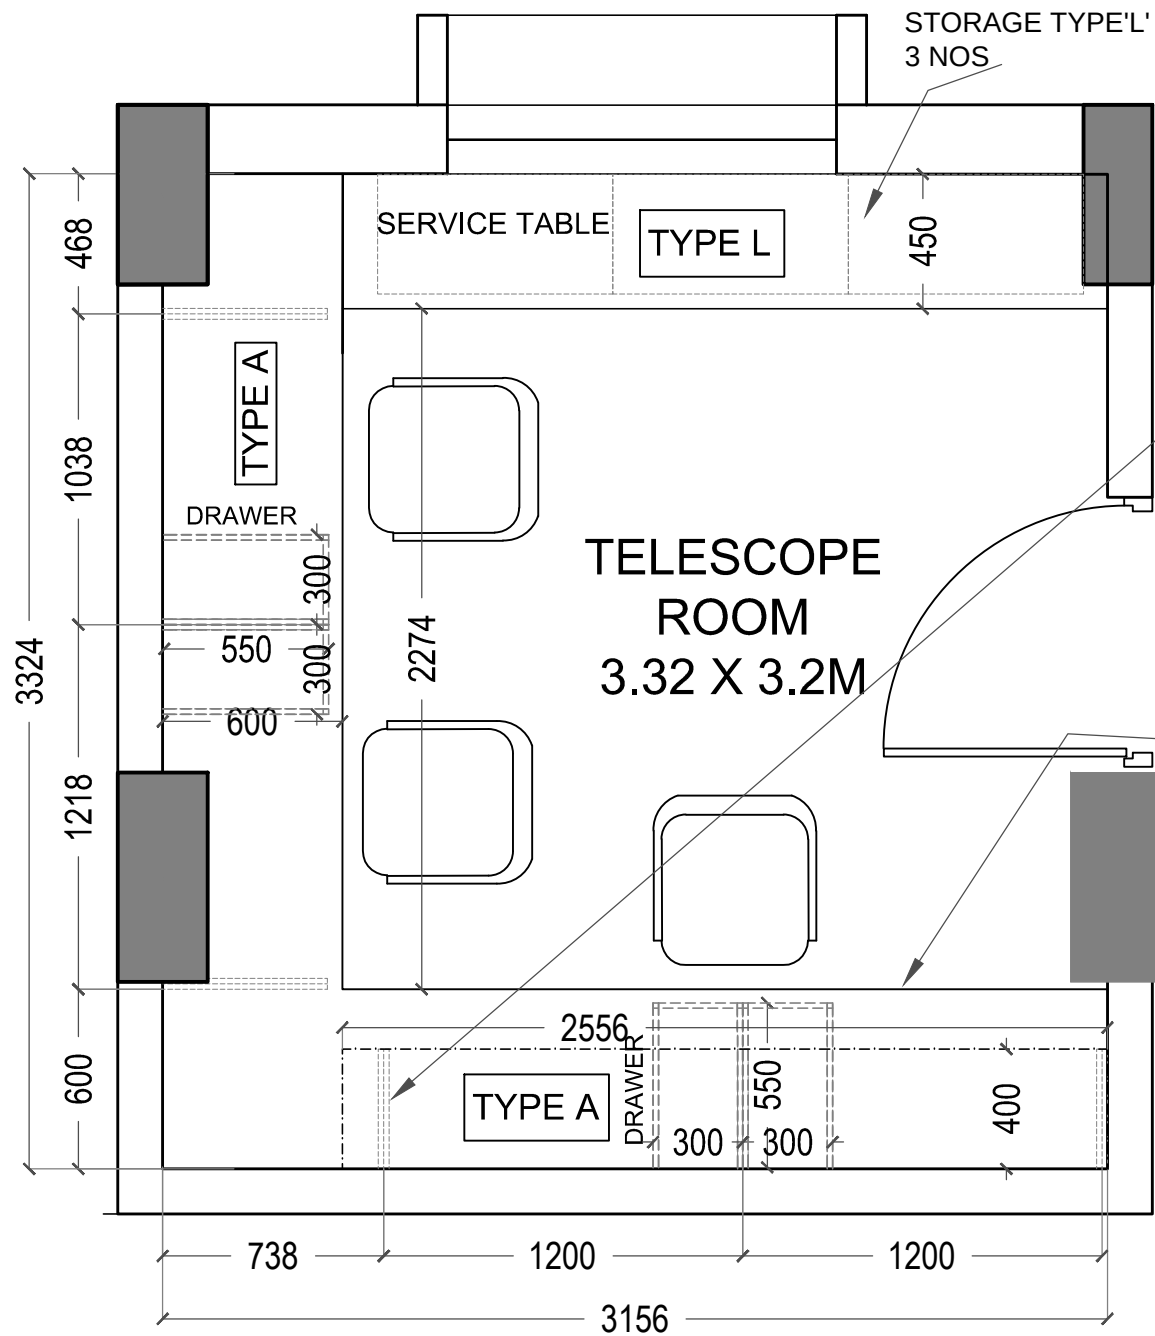


PARTITION	
TYPE	HEIGHT
P	2200 MM
Q	1500 MM
R	1500 MM
S	2955 MM
T	3390 MM
U	3390 MM

TYPE	FURNITURE TYPE	SIZE
A	TABLE	1200 X 600 MM
A	TABLE	1500 X 600 MM
A	TABLE	1800 X 600 MM
F	STORAGE CABINET	3435 X 600 MM
L	LAB TABLE	IUCAA

18 MM DOUBLE PLY SUPPORTS
WITH LAMINATE ON BOTH SIDES

25MM THK PLY WITH
1MM THK LAMINATE
ON BOTH SIDE WITH TW LIPPING

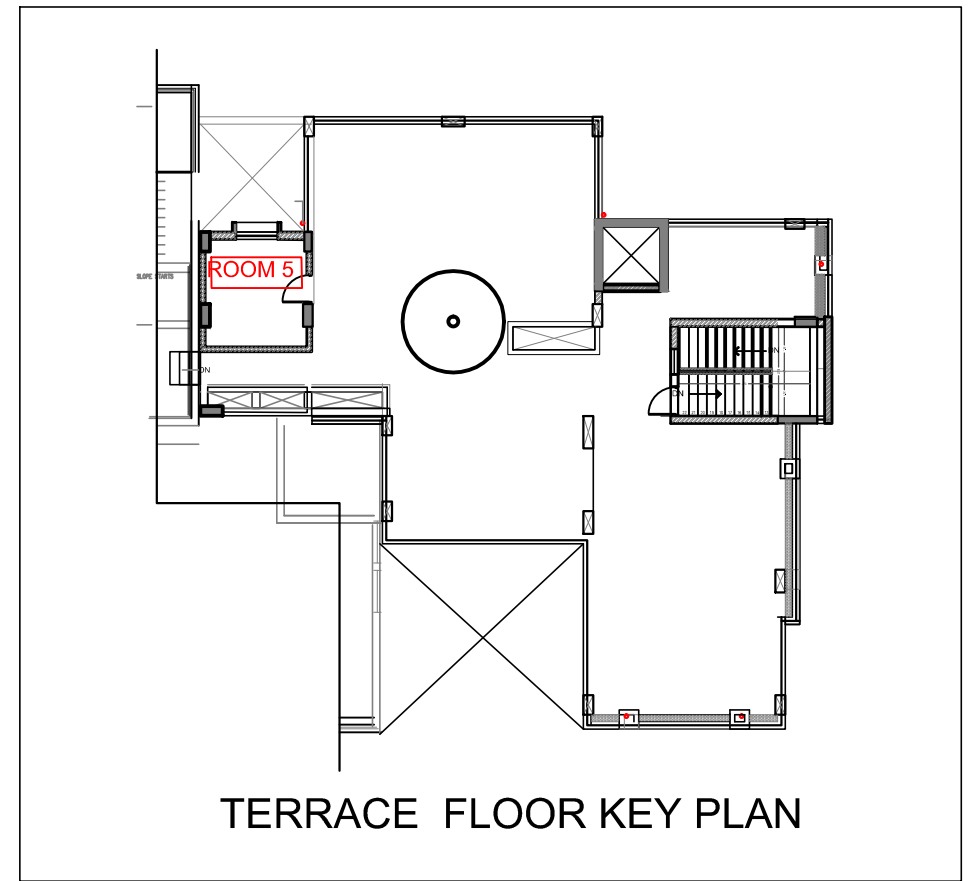

THIS DRAWING IS THE PROPERTY OF
M/S RAJEEV VISHWASRAO ARCHITECTS,(PUNE)
& NOT TO BE COPIED OR USED WITHOUT
THEIR WRITTEN PERMISSION.

C:\Users\PC6\Desktop\TLC\IUCAA - TLC - ROOM DETAIL
LAYOUTS- 20.1.2020.dwg


ALL DIMENSIONS SHALL BE CHECKED & CO-RELATED WITH STRUCTURAL /
WORKING DRAWINGS & AMBIGUITY SHALL BE IMMEDIATELY BROUGHT
TO THE NOTICE OF THE ARCHITECTS BEFORE ITS EXECUTION.
THIS DRAWING SHOULD NOT BE SCALED & ONLY WRITTEN
DIMENSIONS TO BE FOLLOWED.
ALL DIMENSIONS ARE IN METER UNLESS OTHERWISE SPECIFIED.

NO.	REVISIONS


ARCHITECT
RAJEEV VISHWASRAO
ARCHITECTS & PLANNERS
'SANSKRUTI' 3RD FLOOR, PLOT NO. 2, SADASHIV PETH,
PUNE - 411 030. TEL. NO. - 020 24530008, 24532008

TITLE : TERRACE FLOOR FURNITURE DETAILS		
PROJECT : TEACHER'S LEARNING CENTRE AT IUCAA CAMPUS		
CLIENT :THE DIRECTOR ,IUCAA		
SCALE : NTS	DATE : 31.08.18	DESIGN : KAVITA


DRG. NO.
IU/TLC/N/410
DATE : 09.12.19

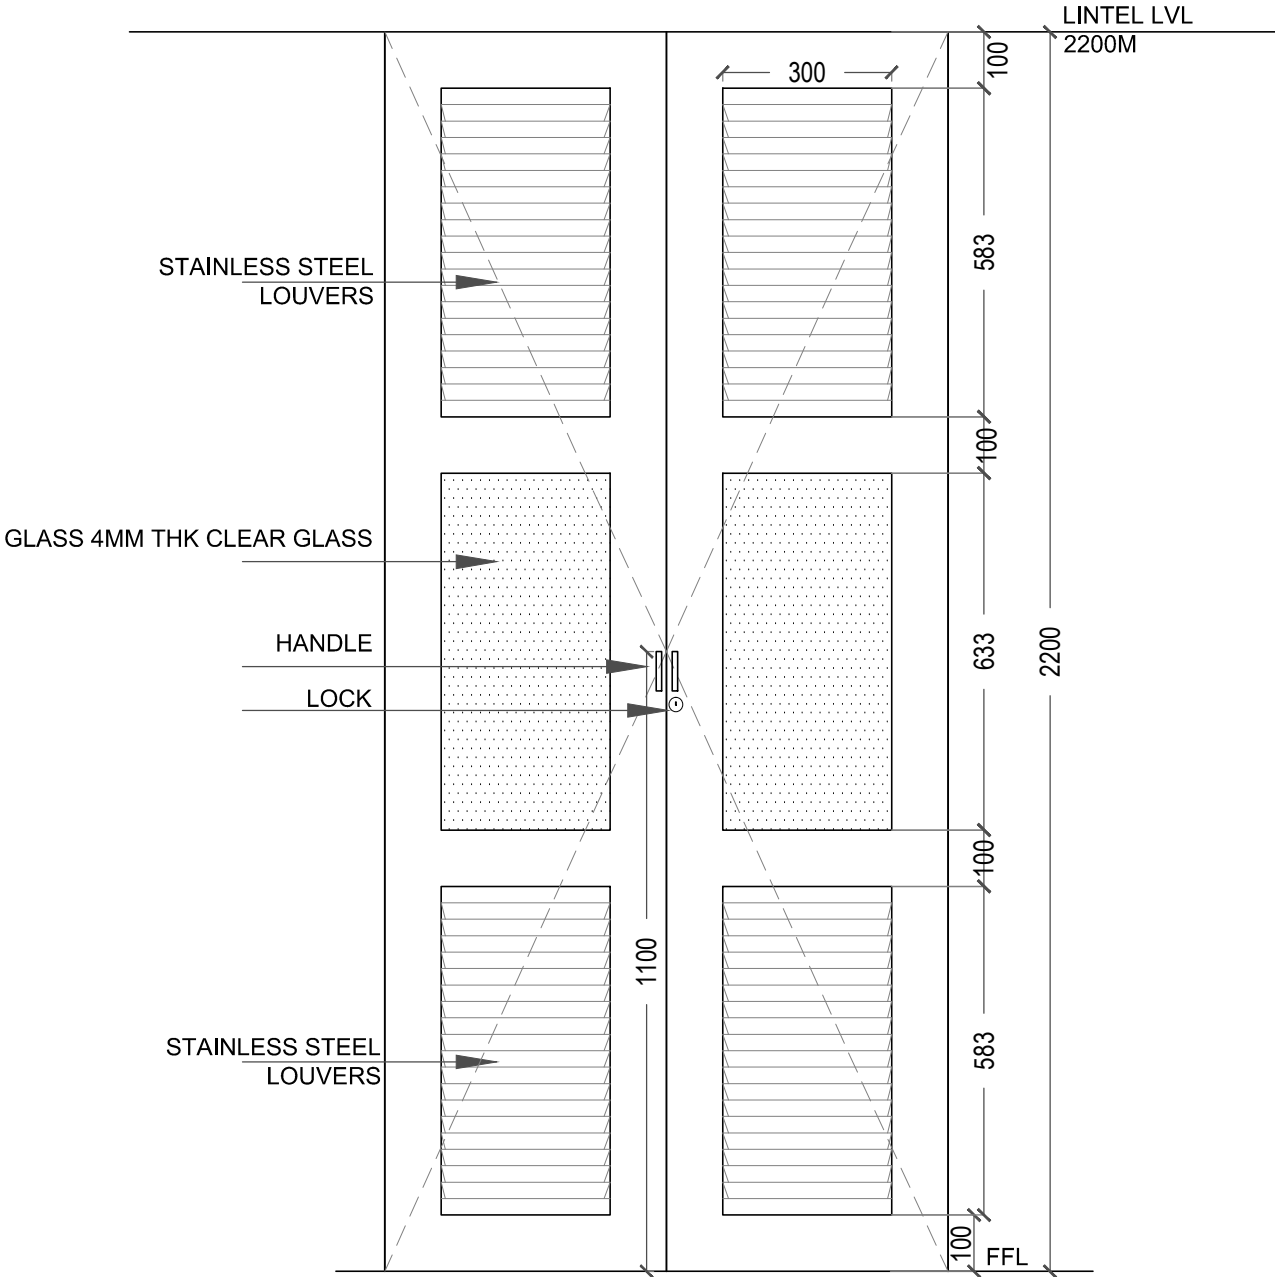

ELEVATION

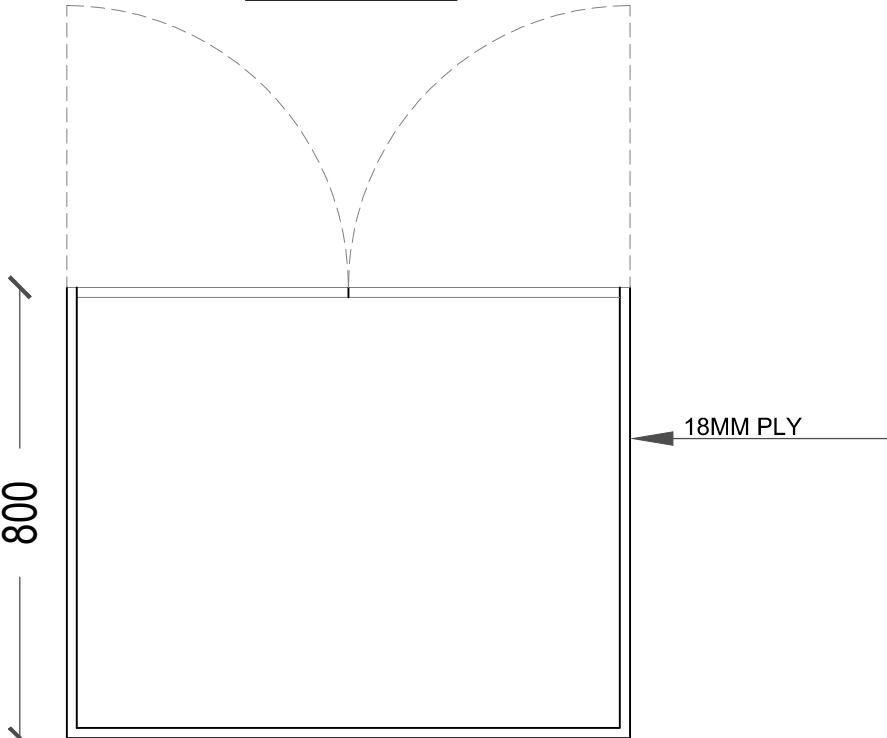




PLAN






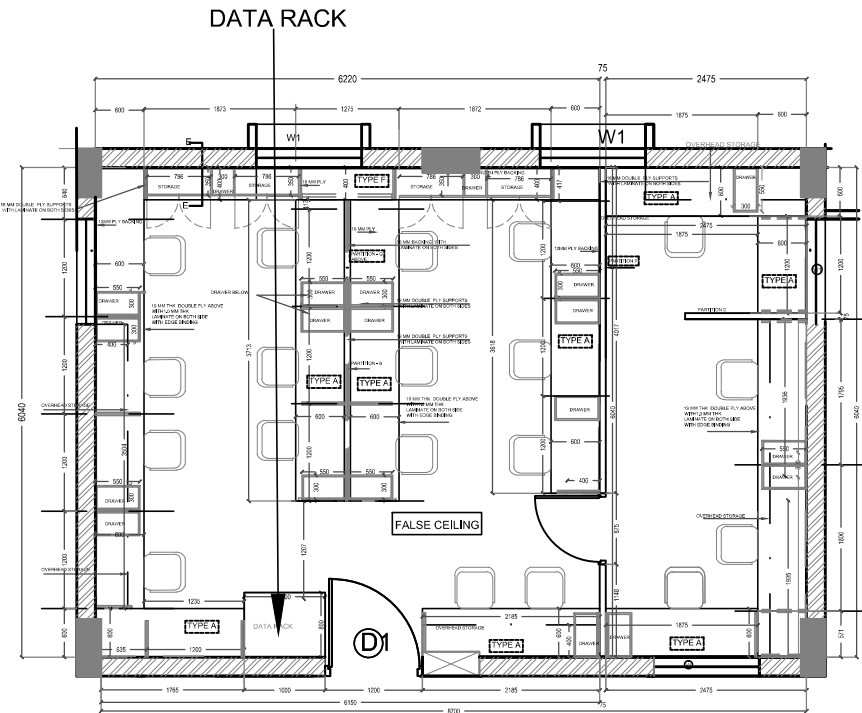


COMPUTER ROOM-FIRST FLOOR



DATA RACK DETAIL

THIS DRAWING IS THE PROPERTY OF MS RAJEEV VISHWASRAO ARCHITECTS (PUNE) & NOT TO BE COPIED OR USED WITHOUT THEIR WRITTEN PERMISSION. C:\rajeev\cd\dwg\project\TLC\DATA - TLC - SINK - RACK.DWG RACK_AJI_2001.dwg		NO REVISIONS																																																																																																																																																																																																																																																																																																																																																																																																																																																																																																																																																																																										
---	--	--------------	--	--	
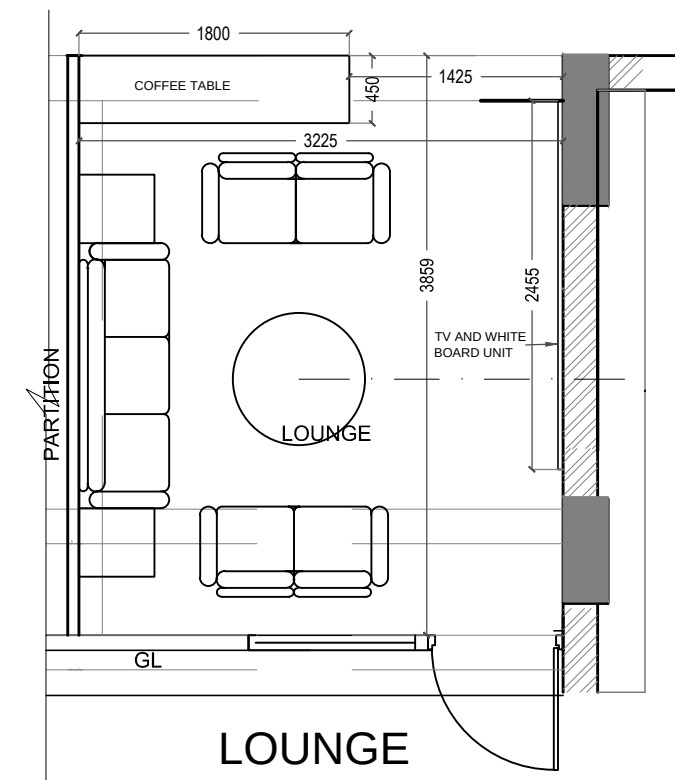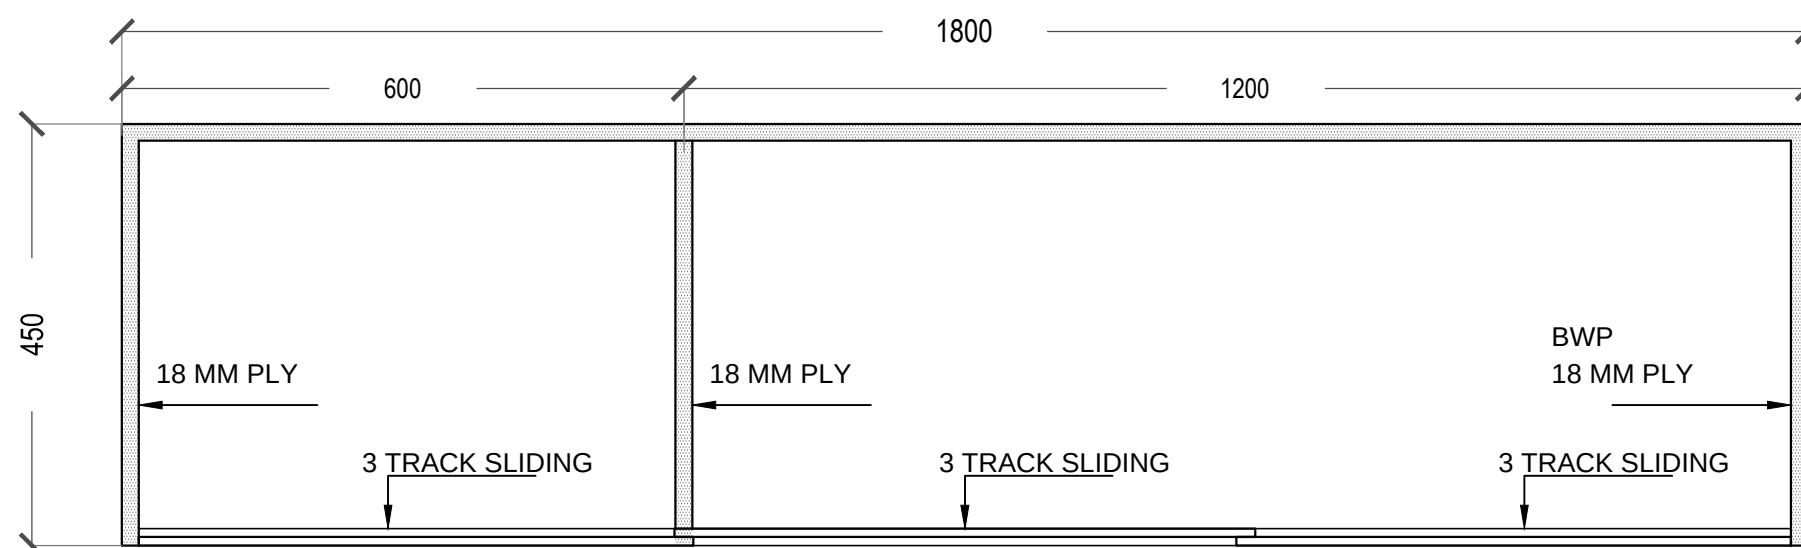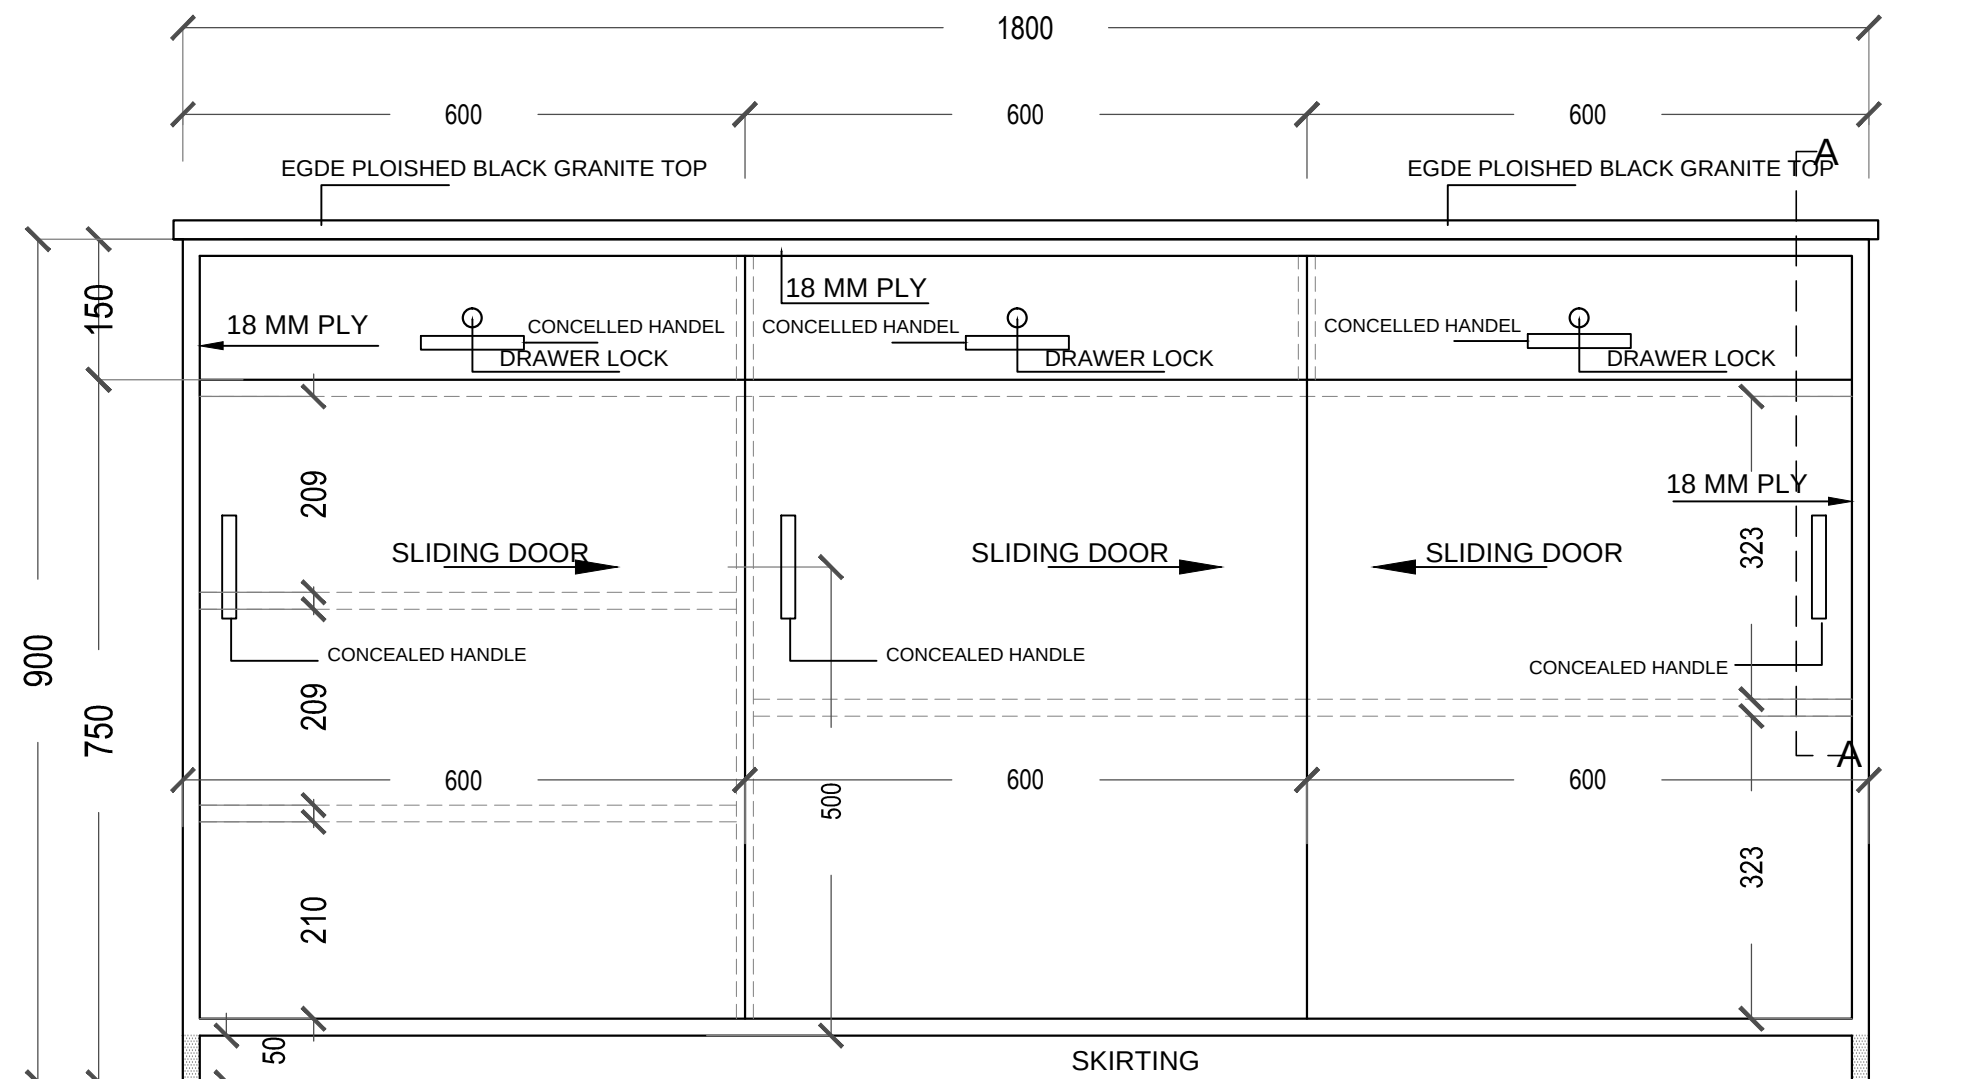

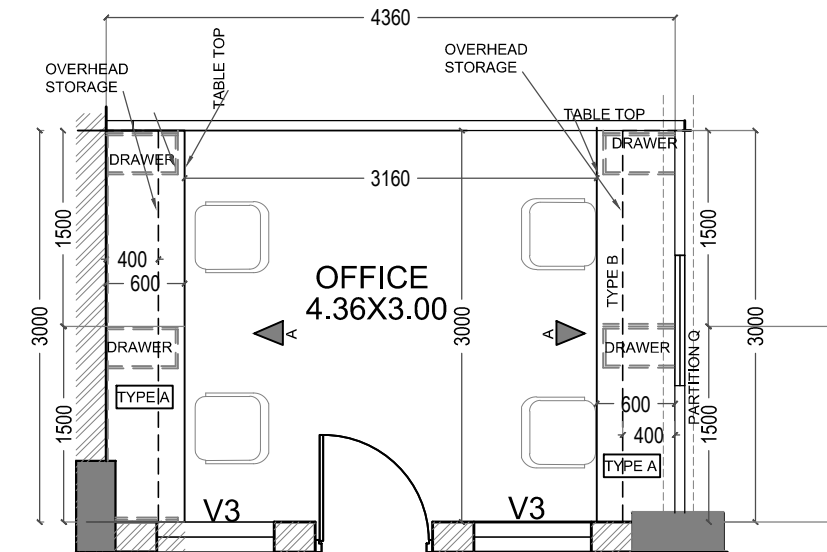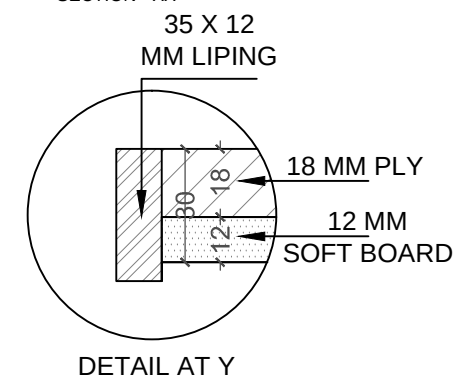
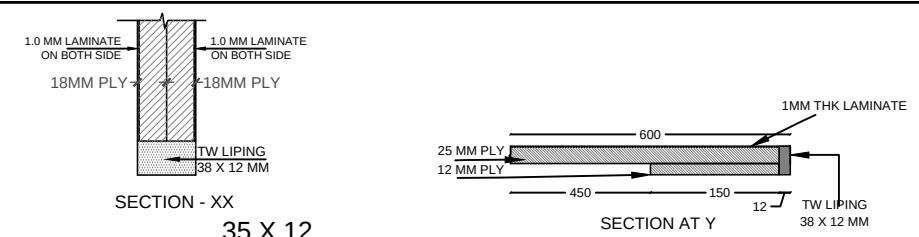
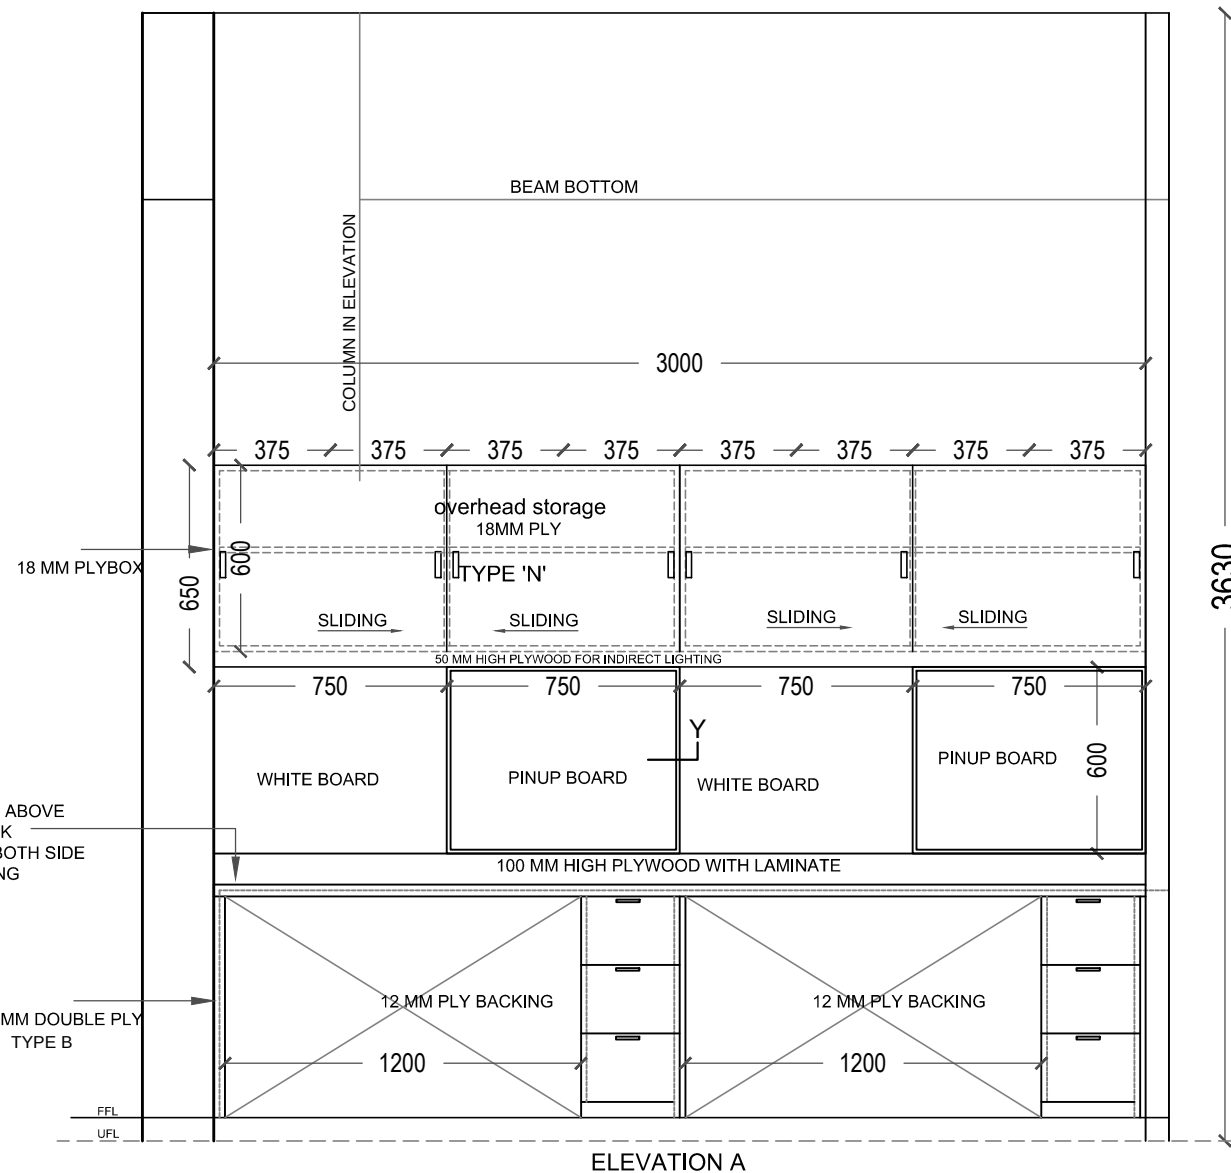
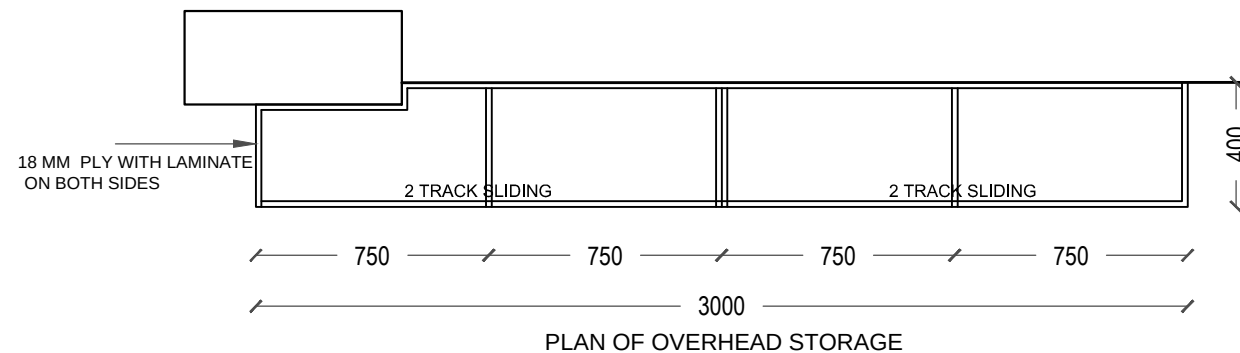
 


KEY PLAN-OFFICE TABLE
2ND FLOOR



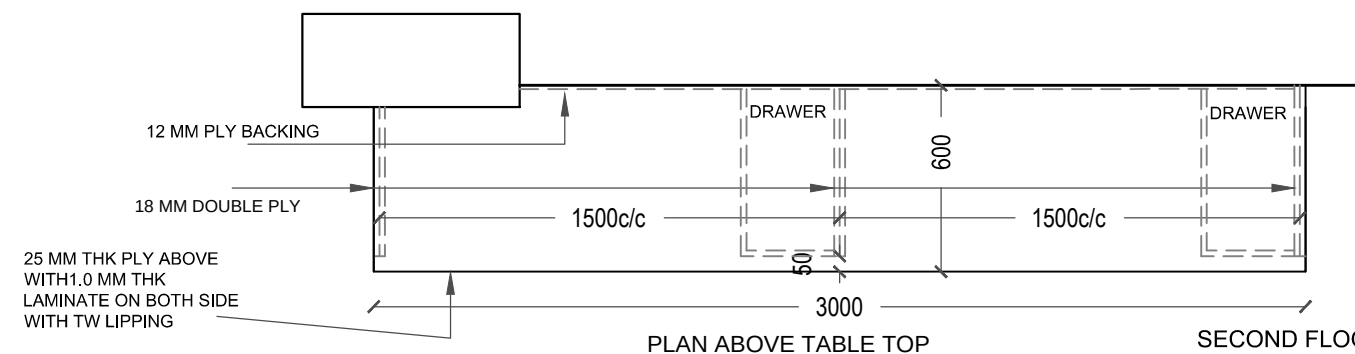
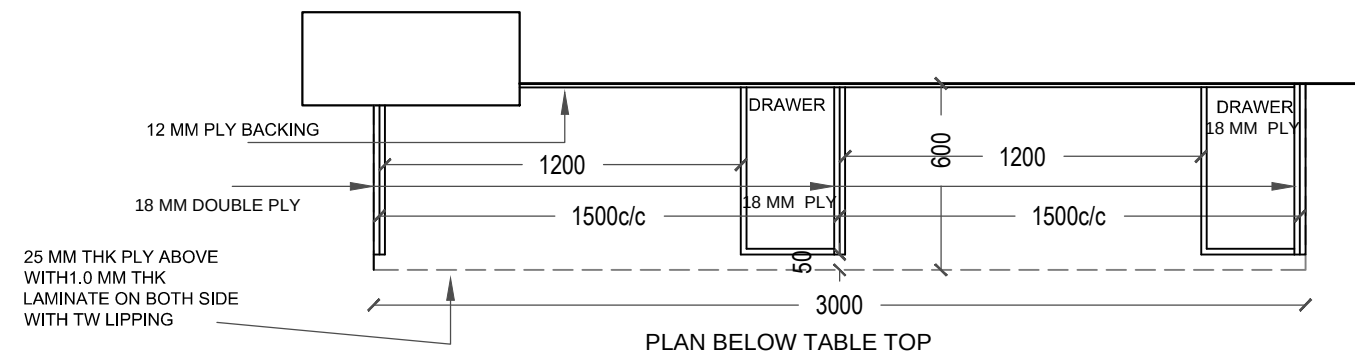


SECOND FLOOR
OFFICE TABLE-TYPE A
STORAGE TYPE 'N'
SOFT BOARD










[illegible]

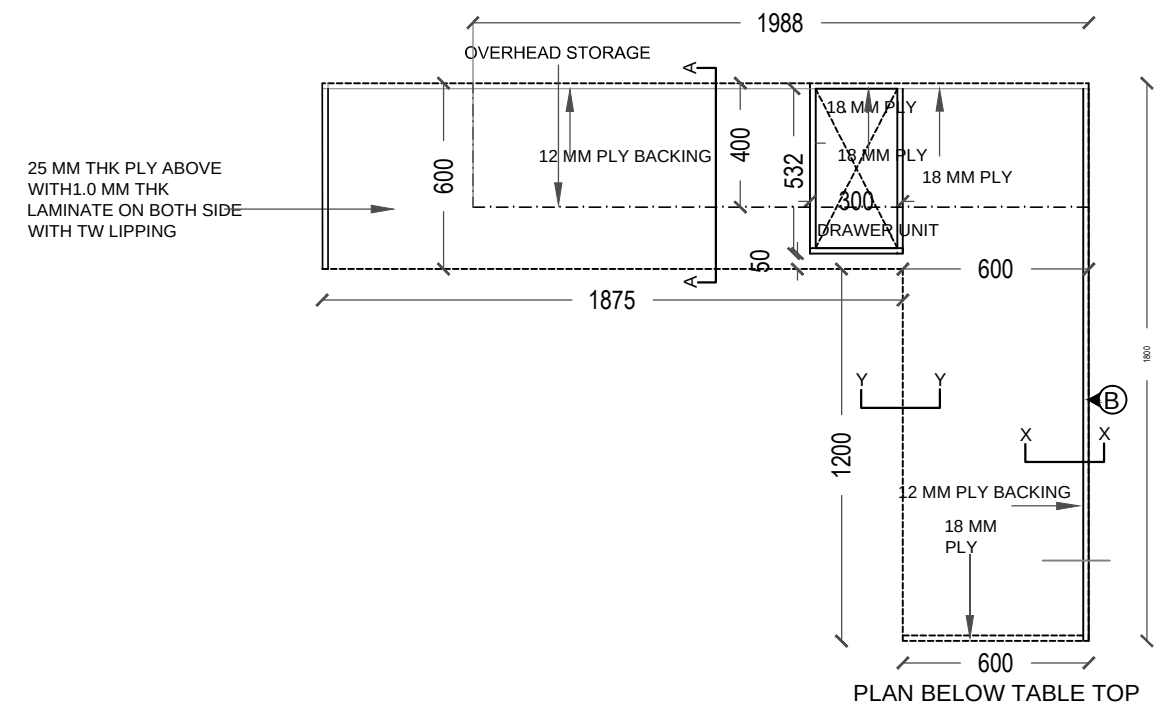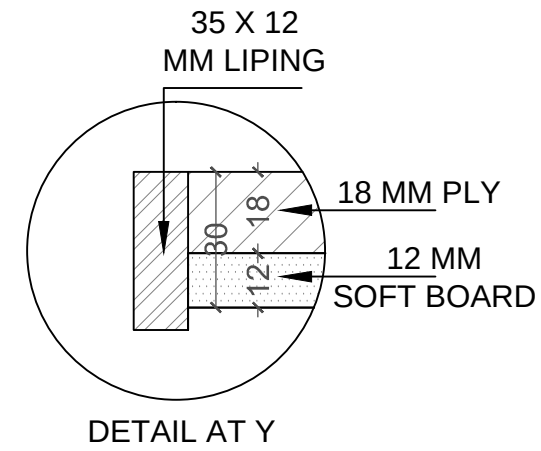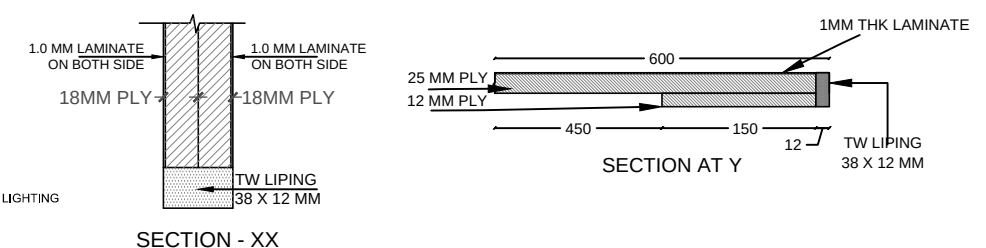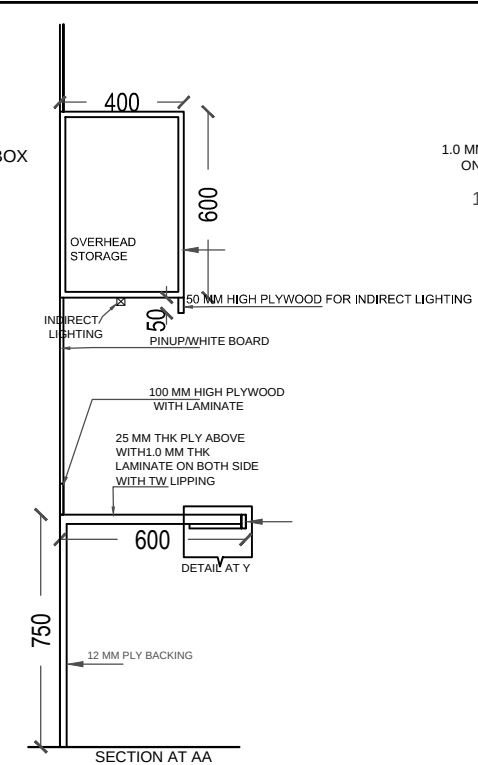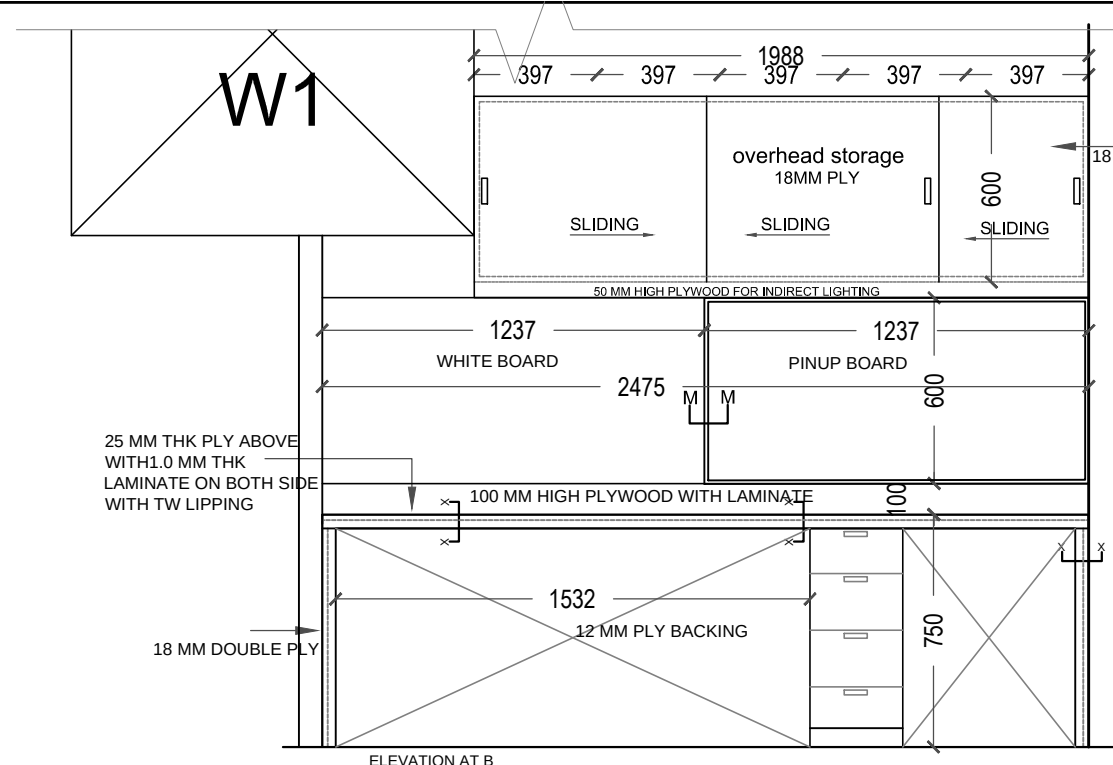



19 MM THK DOUBLE PLY WITH 1.0 MM THK LAMINATE ON BOTH SIDE WITH TW LIPPING

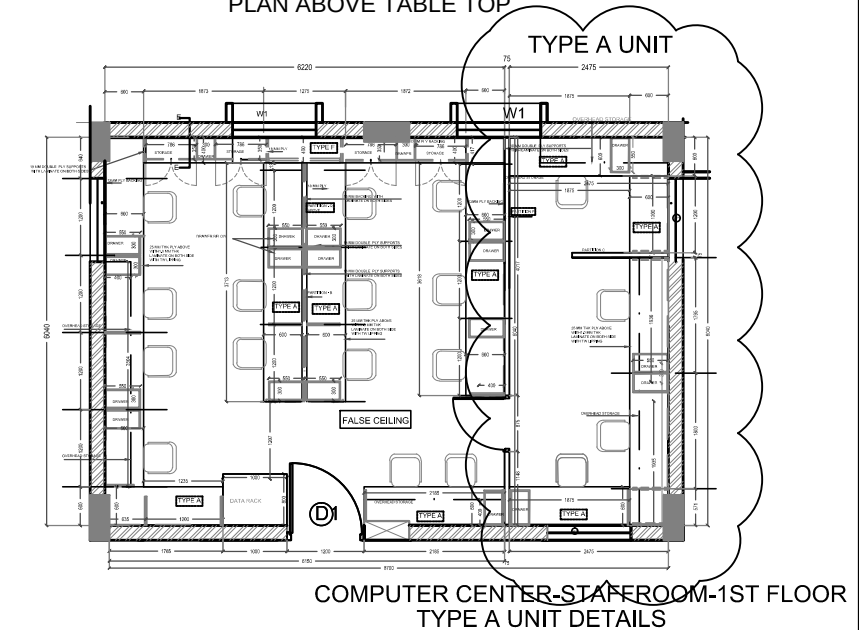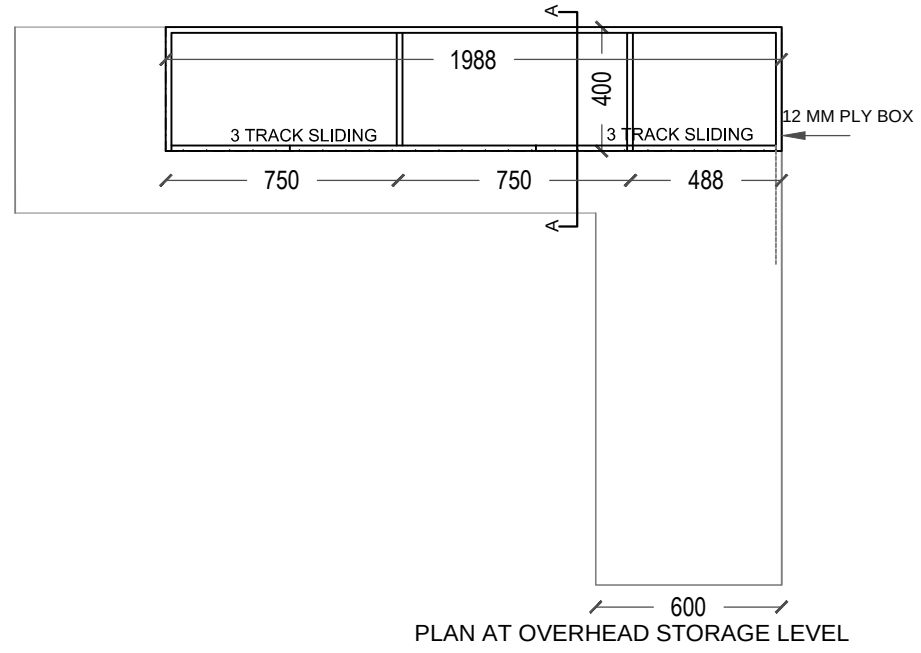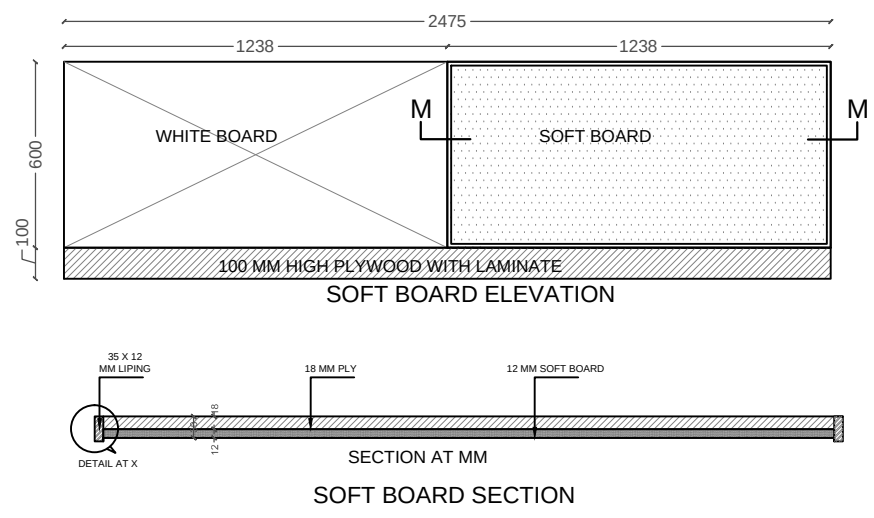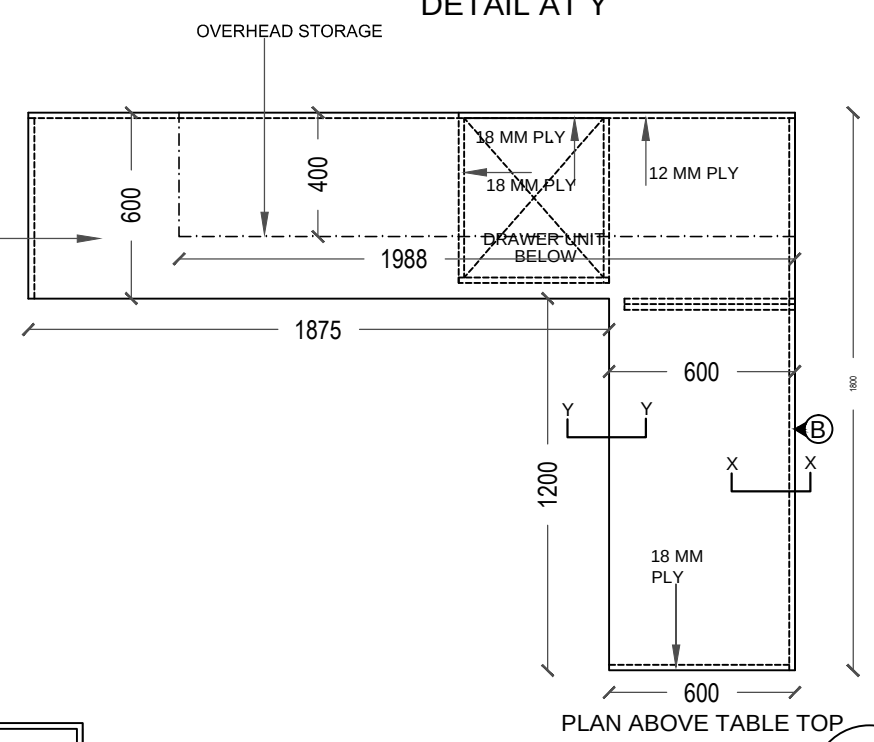

DRG. NO.	IU/TLC/IN/222	DATE :	17.12.19
TITLE : TABLE TYPE A DETAILS			
PROJECT : TEACHER'S LEARNING CENTRE AT IUCAA CAMPUS			
CLIENT : THE DIRECTOR IUCAA			
SCALE : NTS			
DATE : 31.08.18			
DESIGN : KAVITA			
ARCHITECT	RAJEEV VISHWASRAO		
ARCHITECTS & PLANNERS			
SANSKRITI 3RD FLOOR PLOT NO. 2, SADASHIV PETH, PUNE - 411 005. TEL. NO. : 020 24530006, 24532008			
NO. REVISIONS			
ALL DIMENSIONS SHALL BE CHECKED & CO-RELATED WITH STRUCTURAL WORKING DRAWINGS & AMBIGUITY SHALL BE IMMEDIATELY BROUGHT TO THE ATTENTION OF THE ARCHITECT. THIS DRAWING SHOULD NOT BE SCALED & ONLY WRITTEN DIMENSIONS TO BE FOLLOWED. ALL DIMENSIONS ARE IN METERS UNLESS OTHERWISE SPECIFIED.			
THIS DRAWING IS THE PROPERTY OF MS RAJEEV VISHWASRAO ARCHITECTS (PUNE) & NOT TO BE REPRODUCED OR COPIED WITHOUT THEIR WRITTEN PERMISSION.			
C:\Users\PC\Downloads\IUCAA - TLC - FURNITURE DETAILS TABLES 301_2000_2.dwg			

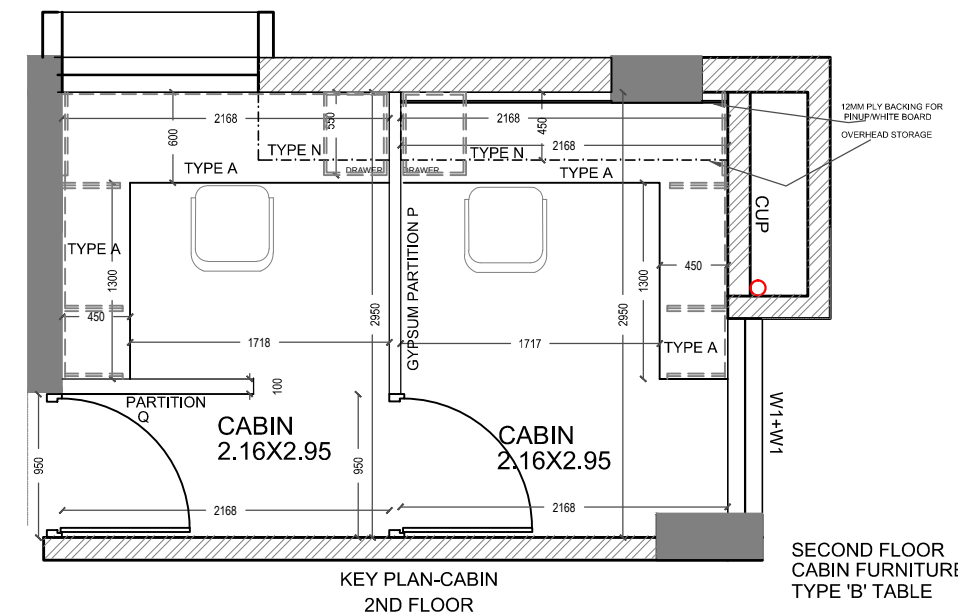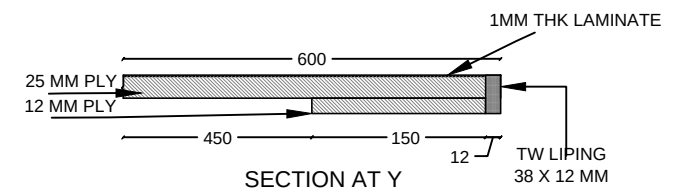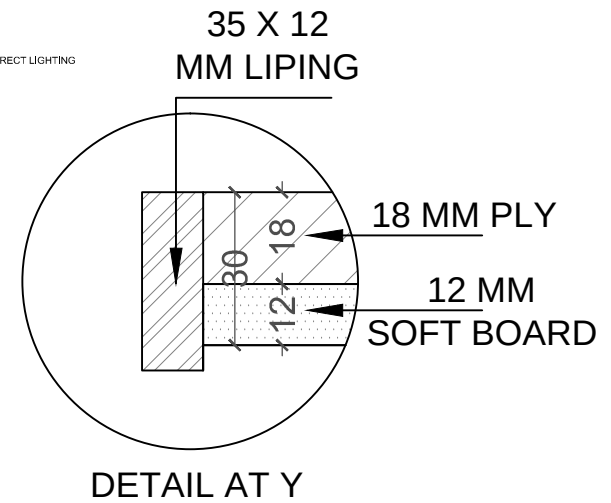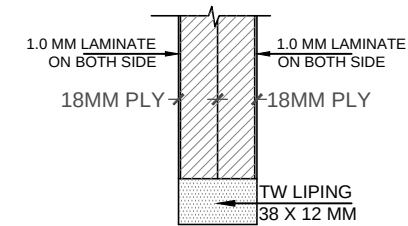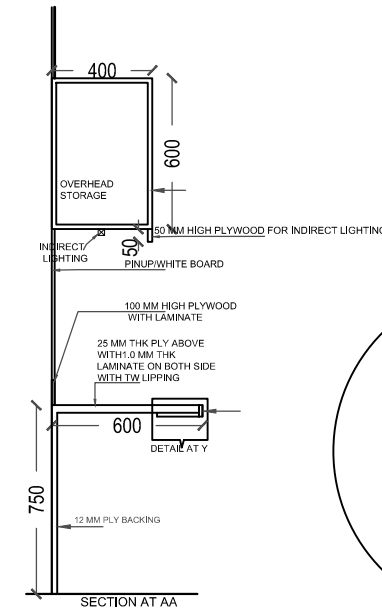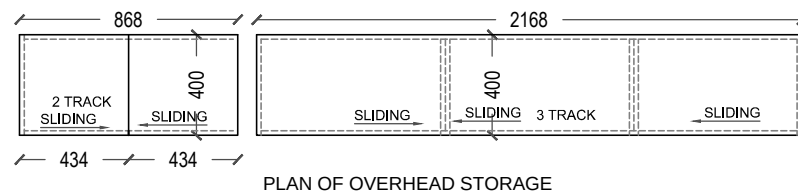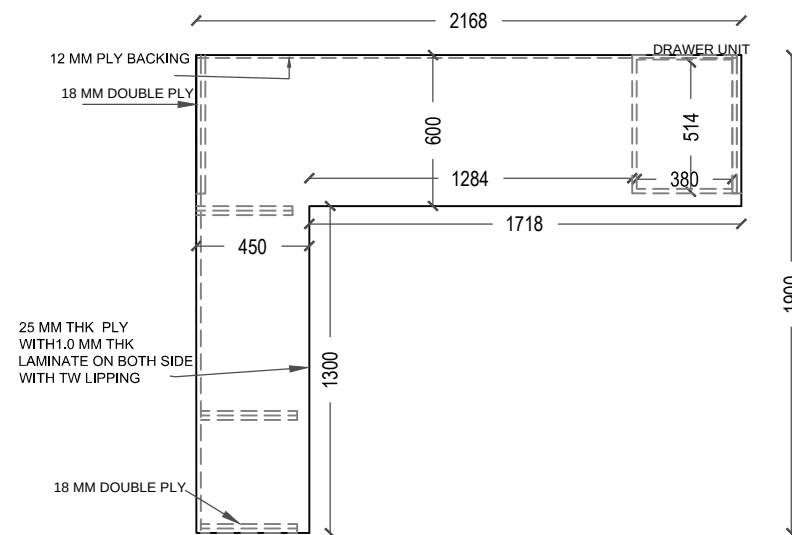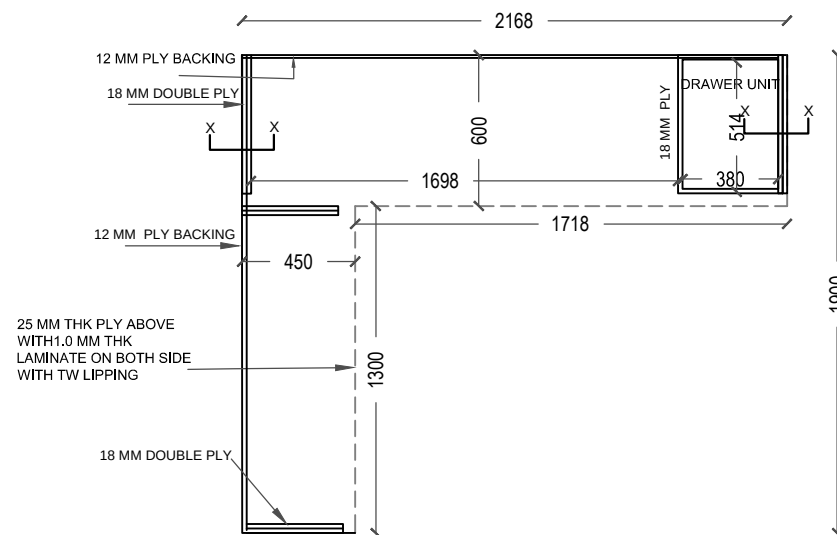
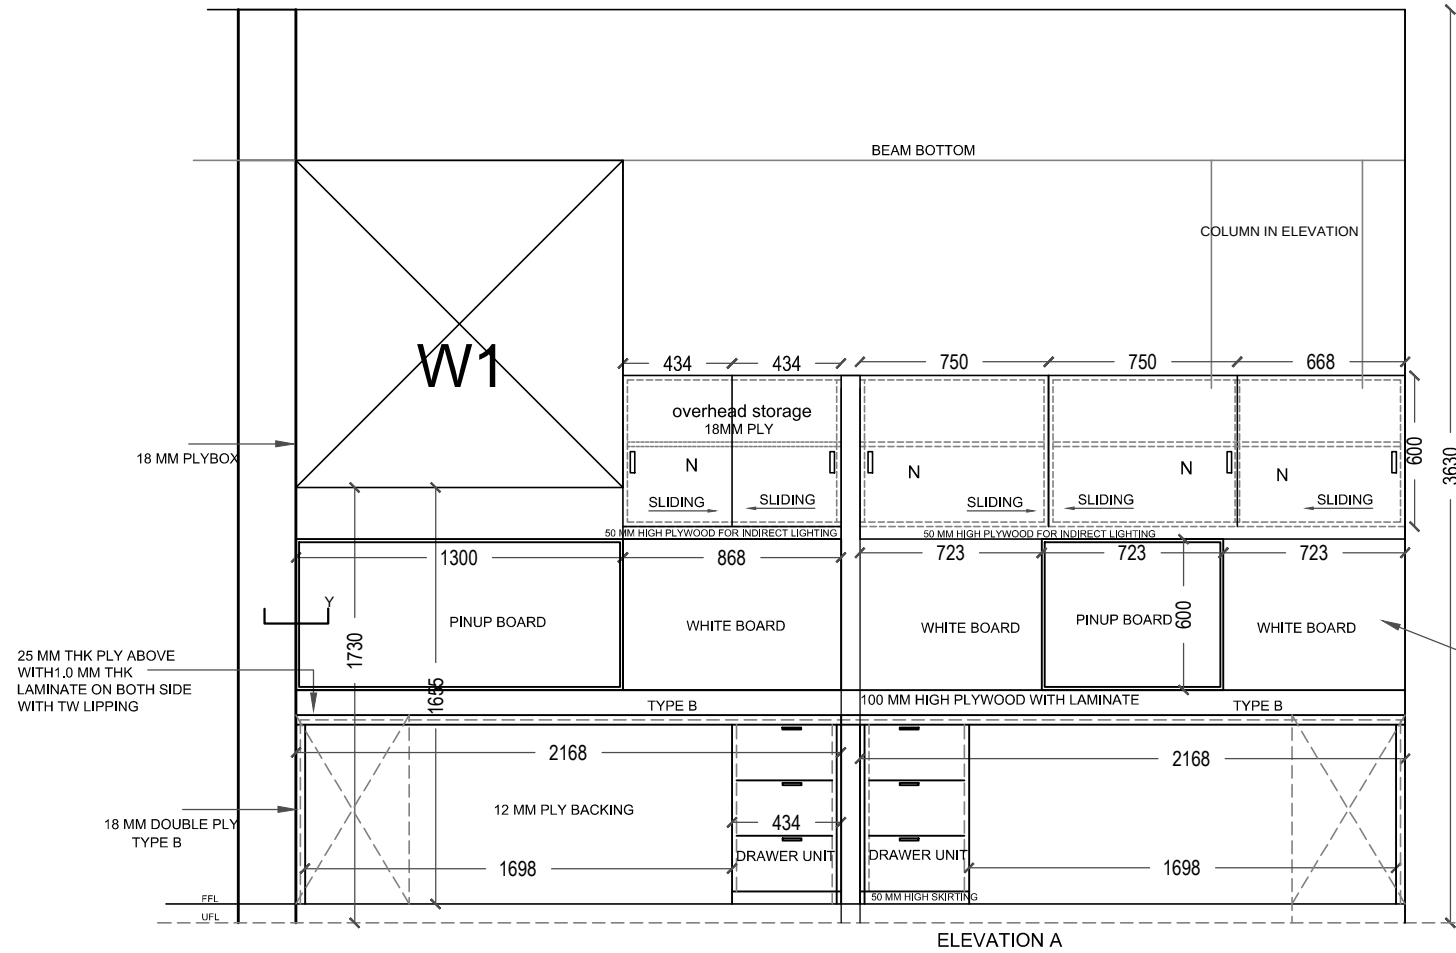


DRG. NO.	IU/TLC/IN/342	
	DATE : 17.12.19	
TITLE : CABIN FURNITURE DETAILS	PROJECT : TEACHER'S LEARNING CENTRE AT IUCAA CAMPUS	
	CLIENT : THE DIRECTOR IUCAA	
	SCALE : NTS DATE : 31.08.18 DESIGN : KAVITA	
ARCHITECT	RAJEEV VISHWASRAO	
	ARCHITECTS & PLANNERS	
	SANSKRITI 3RD FLOOR PLOT NO. 2, SADASHIV PETH, PUNE - 411 004. TEL. NO. : 020 24530006, 24532008	
NO REVISIONS		
ALL DIMENSIONS SHALL BE CHECKED & CO-RELATED WITH STRUCTURAL WORKING DRAWINGS & AMBIGUITY SHALL BE IMMEDIATELY BROUGHT TO THE ATTENTION OF THE ARCHITECT. THIS DRAWING SHOULD NOT BE SCALED & ONLY WRITTEN DIMENSIONS TO BE FOLLOWED.		
THIS DRAWING IS THE PROPERTY OF MS RAJEEV VISHWASRAO ARCHITECTS (PUNE) & NOT TO BE REPRODUCED OR COPIED WITHOUT THEIR WRITTEN PERMISSION.		
	C:\Users\PC\Documents\IUCAA -TLC- FURNITURE DETAILS TABLES 30.12.2009.dwg	

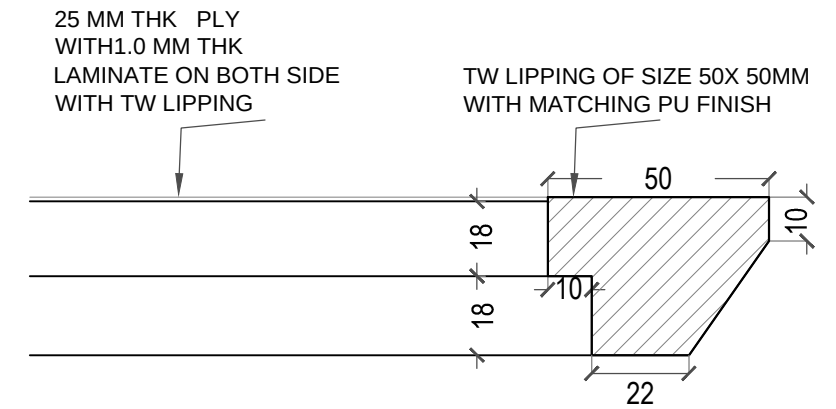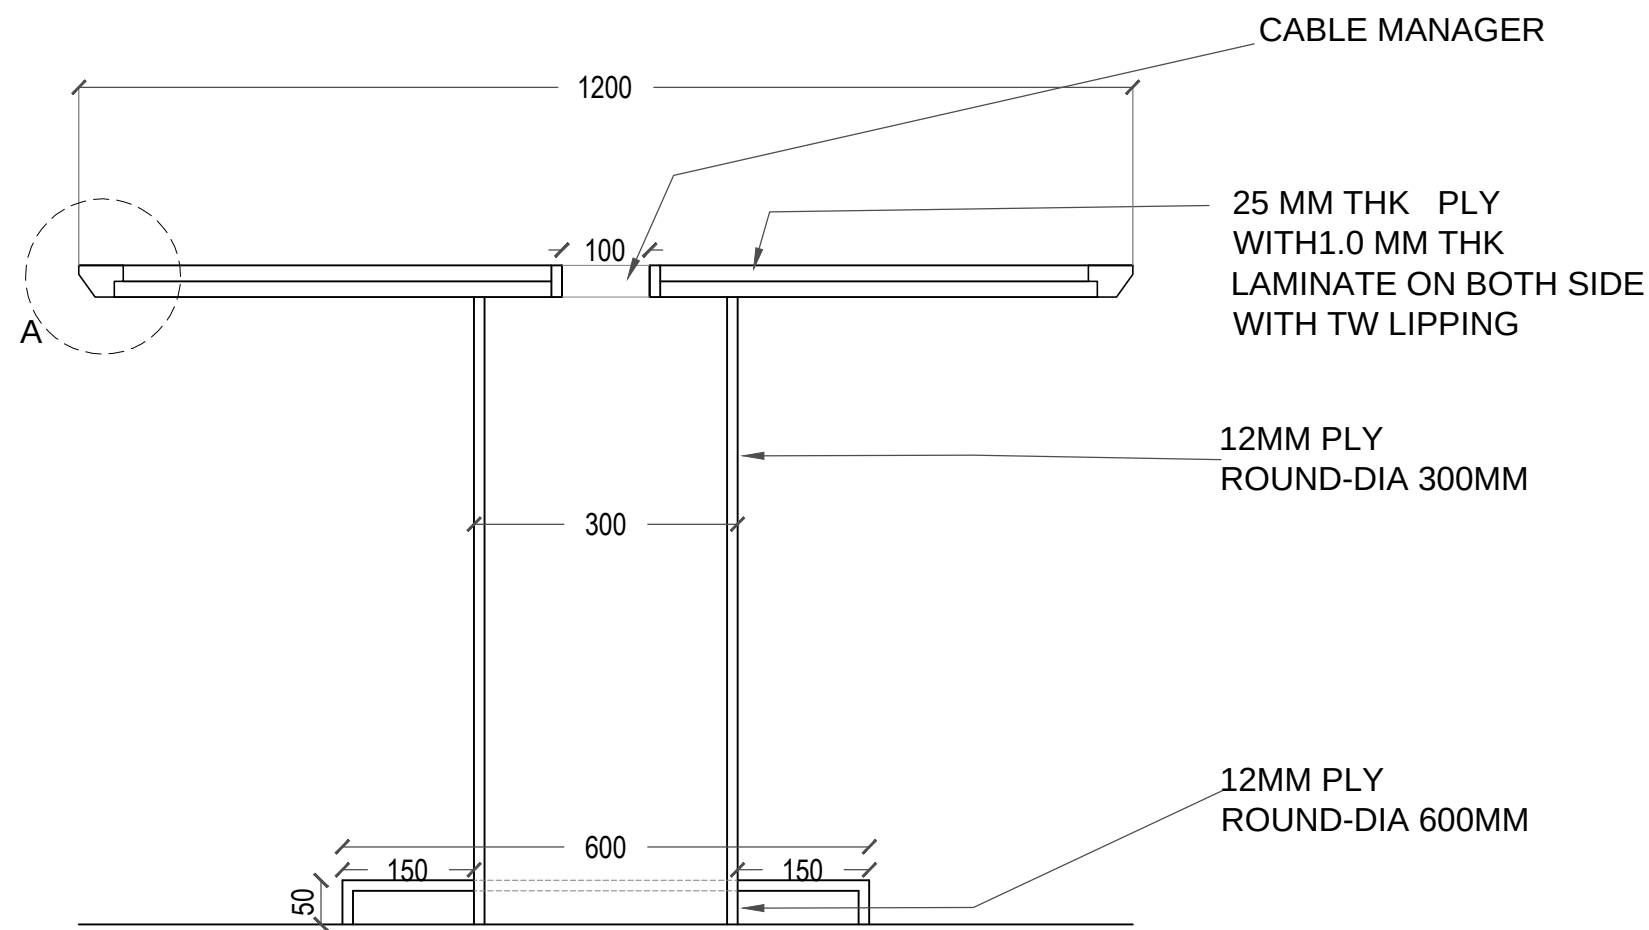

DETAIL AT 'A'

SECTION

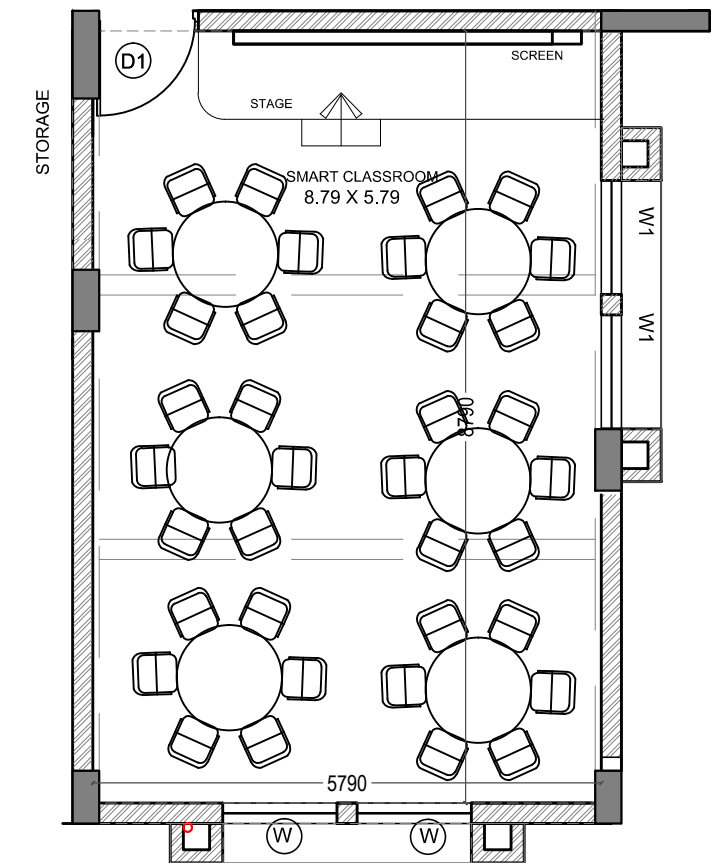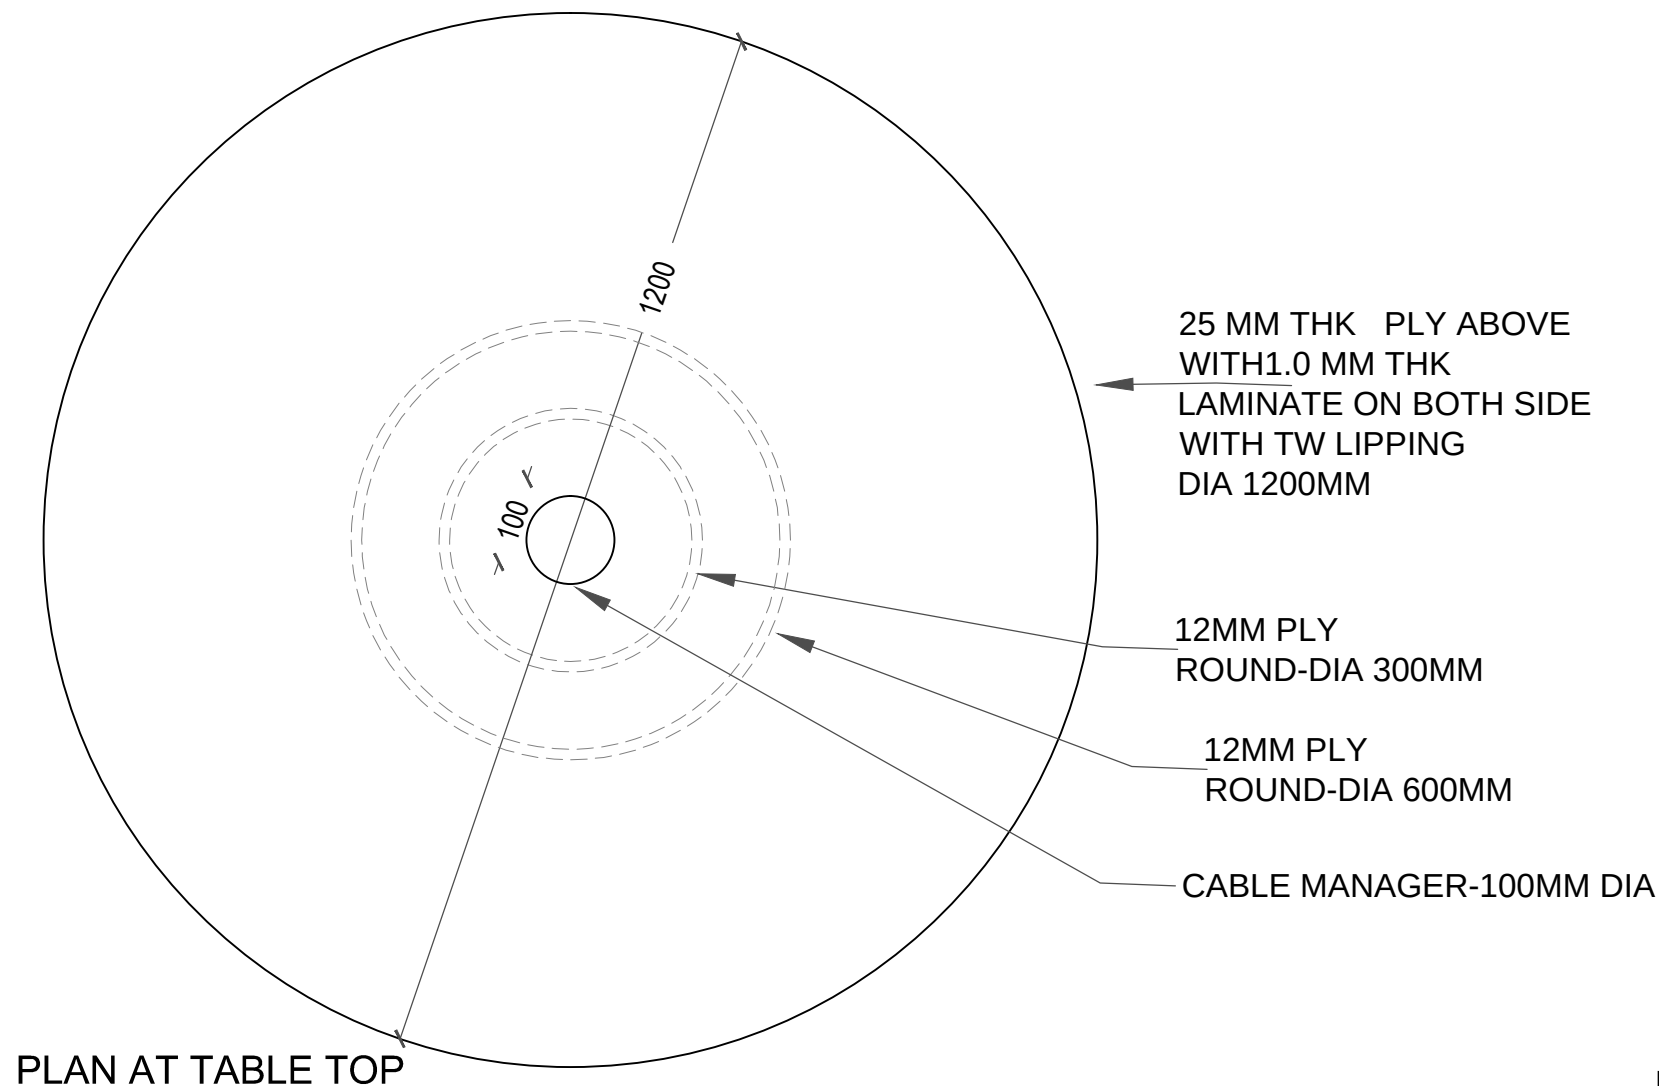


SMART CLASSROOM

FIRST FLOOR
SMART CLASSROOM
ROUND TABLE DETAILS

REQD=6NOS.


THIS DRAWING IS THE PROPERTY OF MS RAJEEV VISHWASRAO ARCHITECTS (PUNE) & NOT TO BE REPRODUCED OR COPIED WITHOUT THE WRITTEN PERMISSION.	DRG. NO. IU/TLC/IN/232	
	DATE : 17.12.19	
	TITLE : SMART CLASSROOM ROUND TABLE DETAILS	
	PROJECT : TEACHER'S LEARNING CENTRE AT IUCAA CAMPUS	
ARCHITECT RAJEEV VISHWASRAO ARCHITECTS & PLANNERS SANSKRITI 3RD FLOOR PLOT NO. 2, SADASHIV PETH, PUNE - 411 006. TEL. NO. : 020 24530006, 24532008	CLIENT : THE DIRECTOR IUCAA	
	SCALE : NTS	
	DATE : 31.08.18 DESIGN : KAVITA	

ALL DIMENSIONS SHALL BE CHECKED & CO-RELATED WITH STRUCTURAL /
WORKING DRAWINGS & AMBIGUITY SHALL BE IMMEDIATELY BROUGHT
TO THE ATTENTION OF THE ARCHITECT. THIS DRAWING SHOULD NOT BE SCALED & ONLY WRITTEN
DIMENSIONS TO BE FOLLOWED. ALL DIMENSIONS ARE IN METER UNLESS OTHERWISE SPECIFIED.

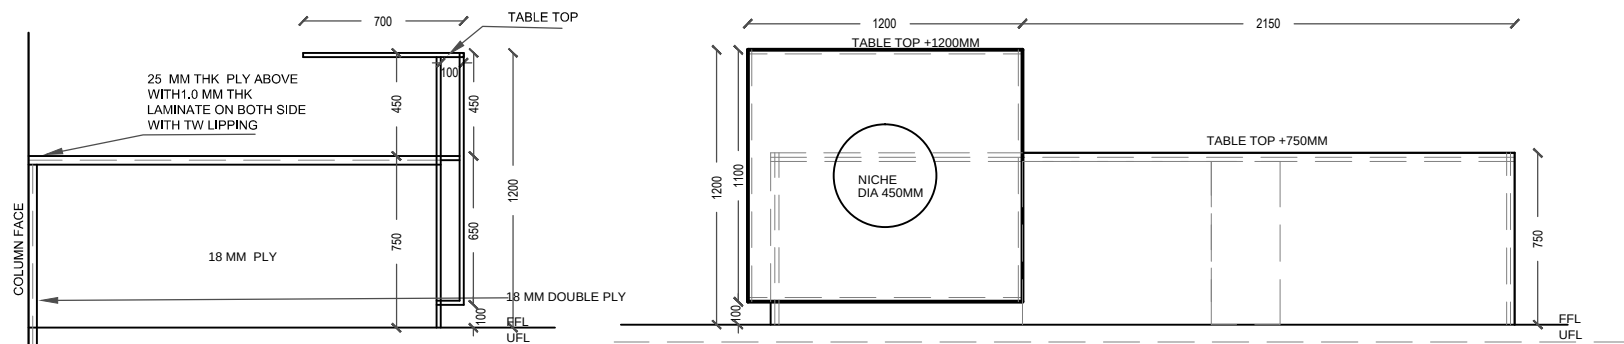


SECTION X-X

ELEVATION A

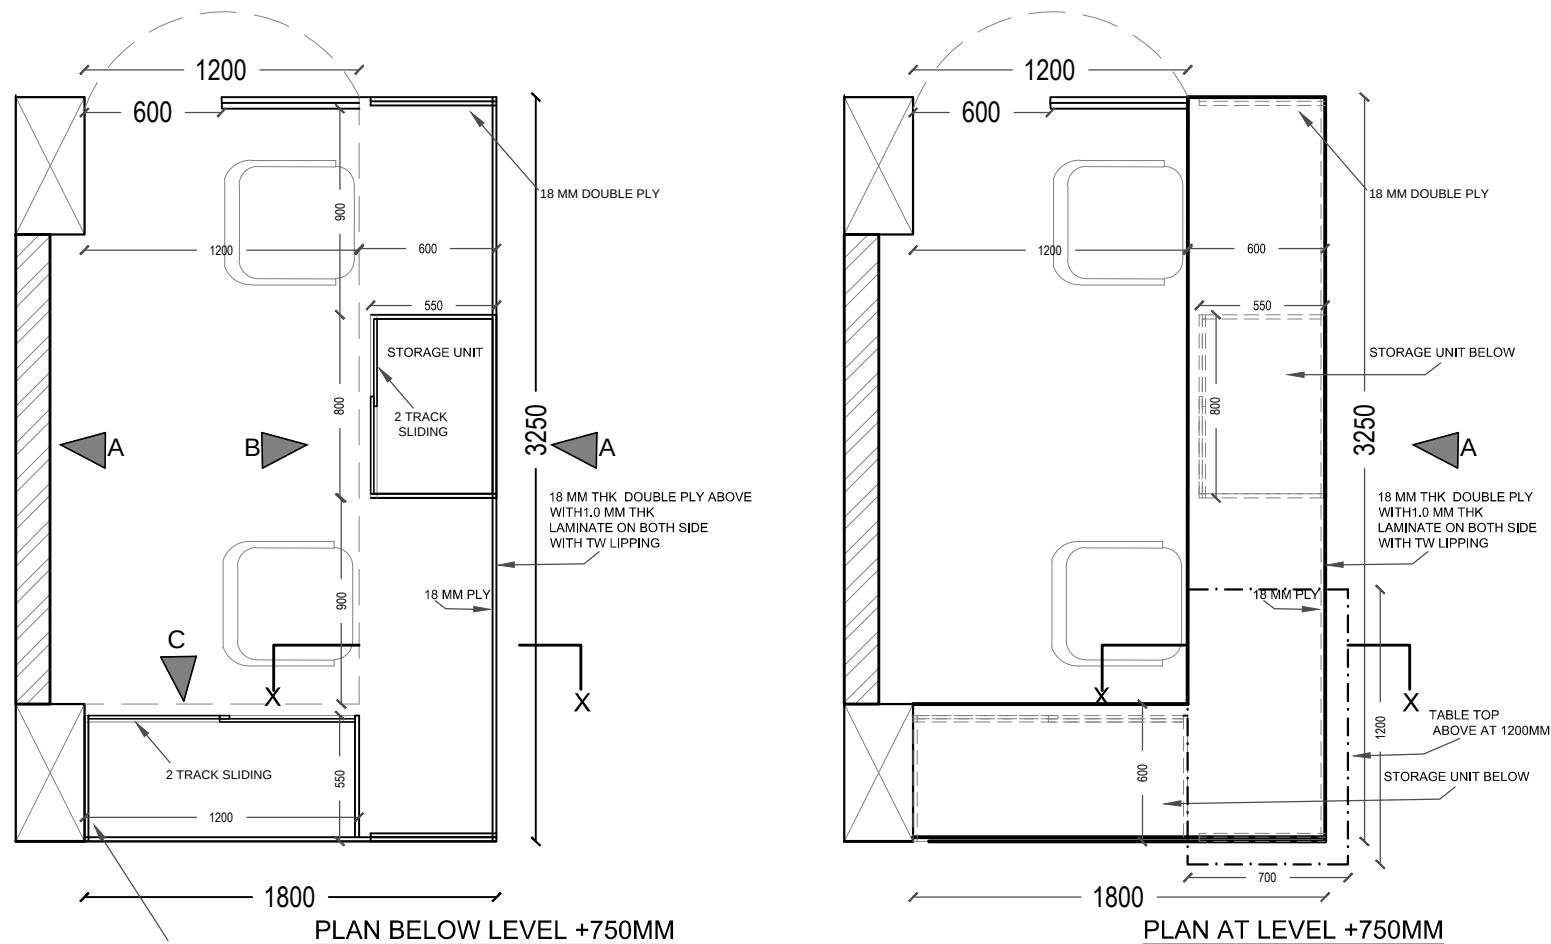


PLAN BELOW LEVEL +750MM

PLAN AT LEVEL +750MM

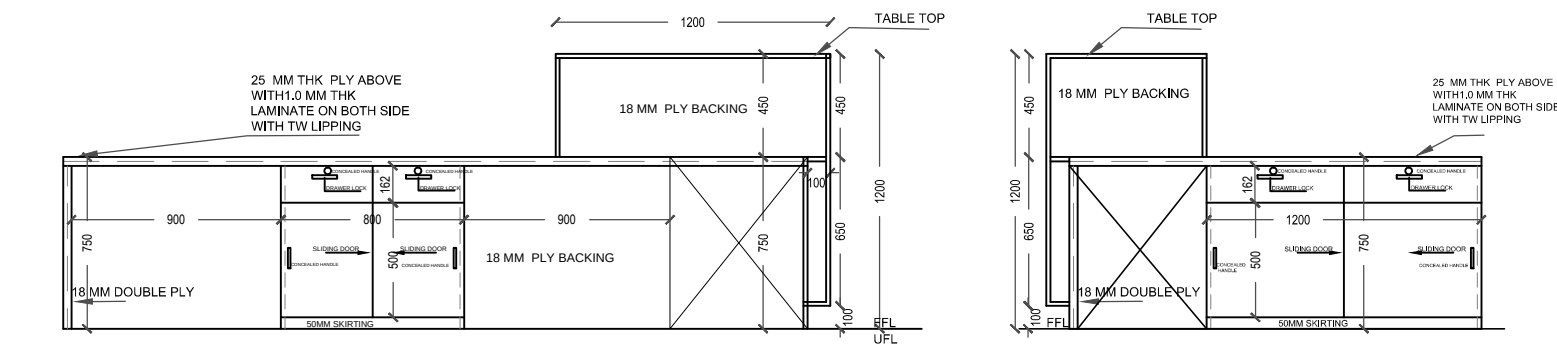


ELEVATION B

ELEVATION C

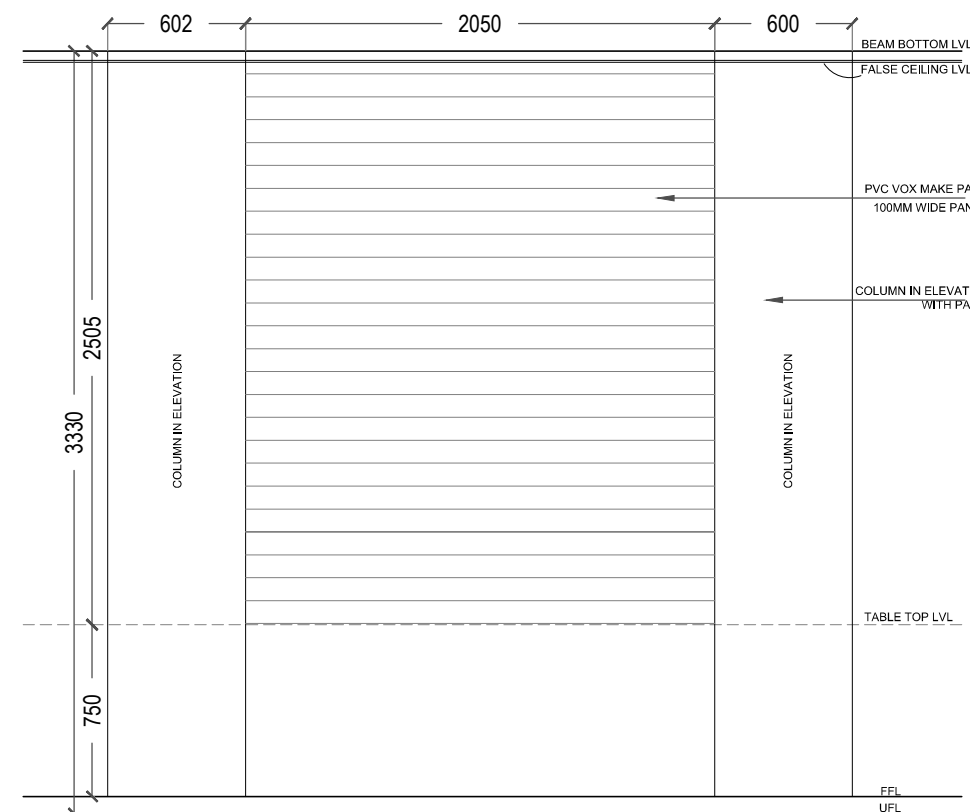


RECEPTION WALL DETAIL
ELEVATION 'A'

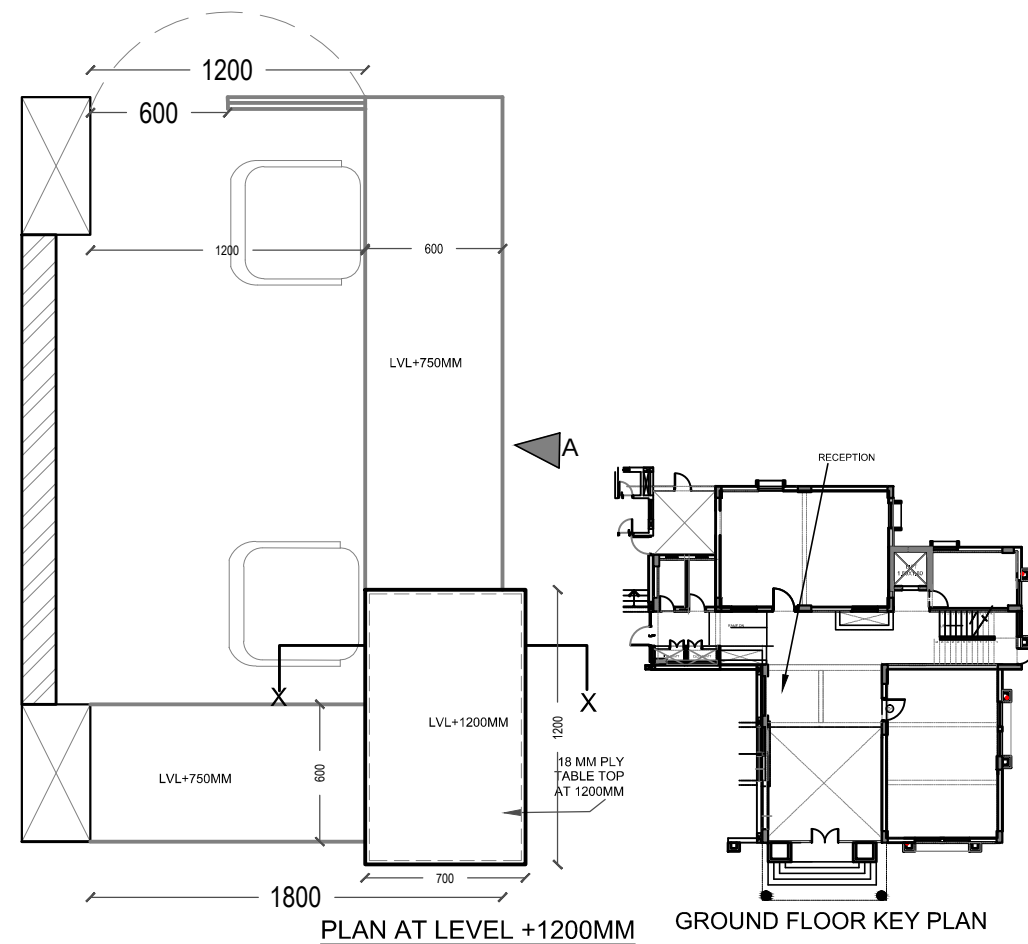


PLAN AT LEVEL +1200MM

GROUND FLOOR KEY PLAN


DRG. NO.	IU/TLC/IN/130	
	DATE :	
	3.1.2020	
TITLE : RECEPTION TABLE DETAILS	PROJECT : TEACHER'S LEARNING CENTRE AT IUCAA CAMPUS	
	CLIENT : THE DIRECTOR IUCAA	
	SCALE : NTS	
	DATE : 31.08.18	
ARCHITECT	RAJEEV VISHWASRAO	
	ARCHITECTS & PLANNERS	
	SANSKRUT 3RD FLOOR, PLOT NO 2, SANSKRUT PETH,	
	PUNE - 411 001. TEL NO. - 020 24530008, 24530008	
NO. REVISIONS		
ALL DIMENSIONS SHALL BE CHECKED & CO-RELATED WITH STRUCTURAL WORKING DRAWINGS & AMBIGUITY SHALL BE IMMEDIATELY BROUGHT TO THE ARCHITECT'S ATTENTION. THIS DRAWING SHOULD NOT BE SCALED & ONLY WRITTEN DIMENSIONS TO BE FOLLOWED.		
THIS DRAWING IS THE PROPERTY OF MS RAJEEV VISHWASRAO ARCHITECTS (PUNE) & NOT TO BE REPRODUCED OR COPIED WITHOUT THEIR WRITTEN PERMISSION.		

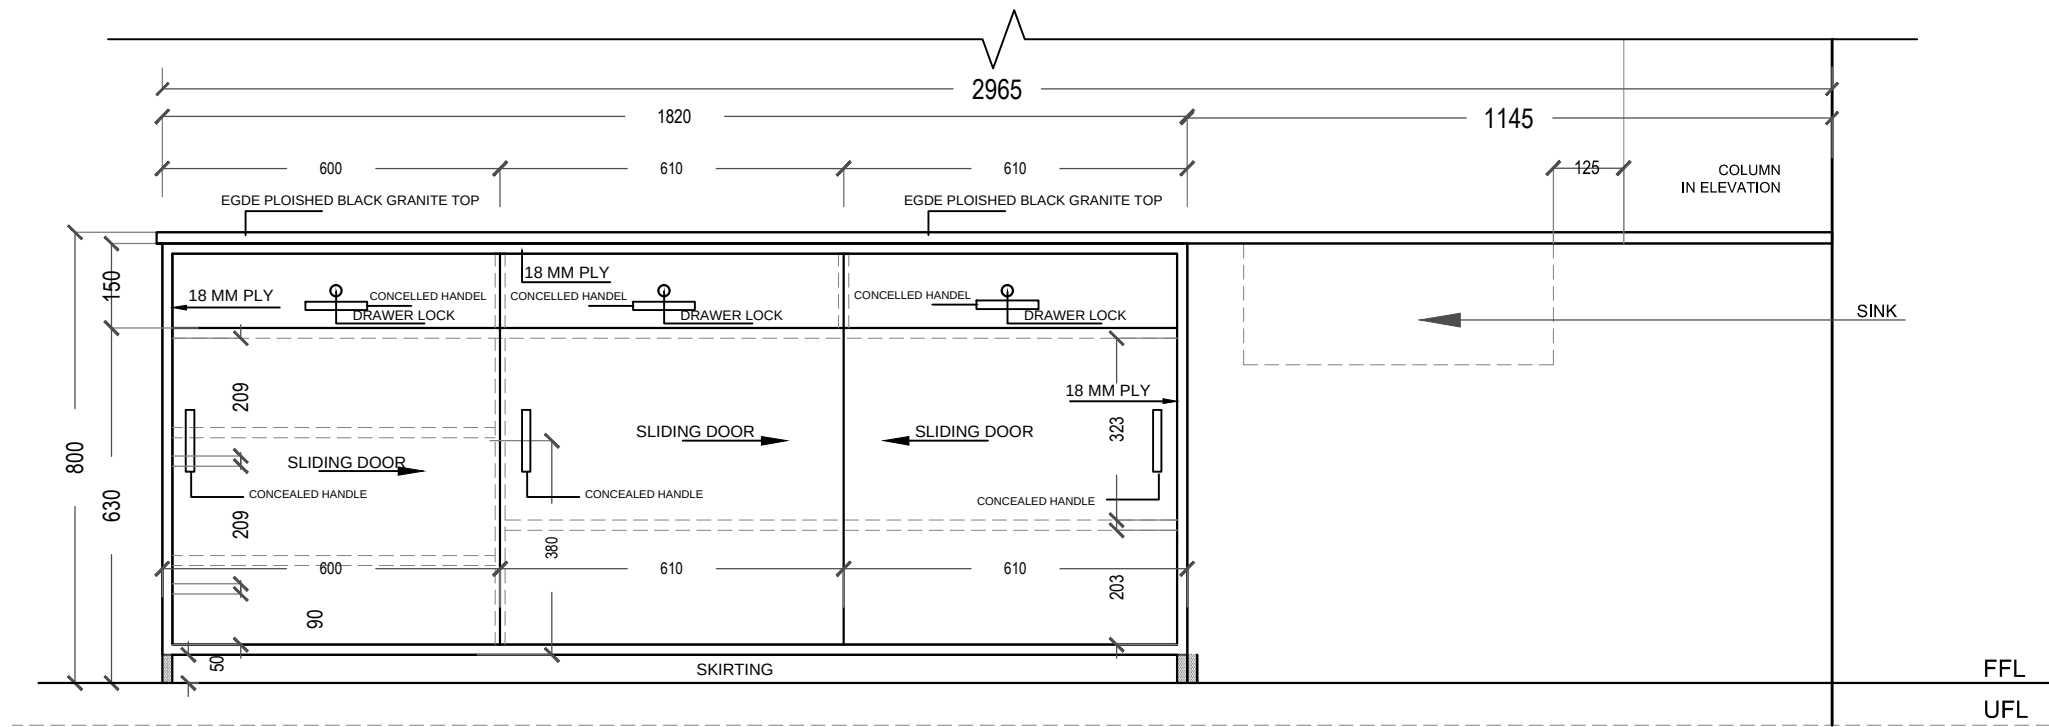

ELEVATION






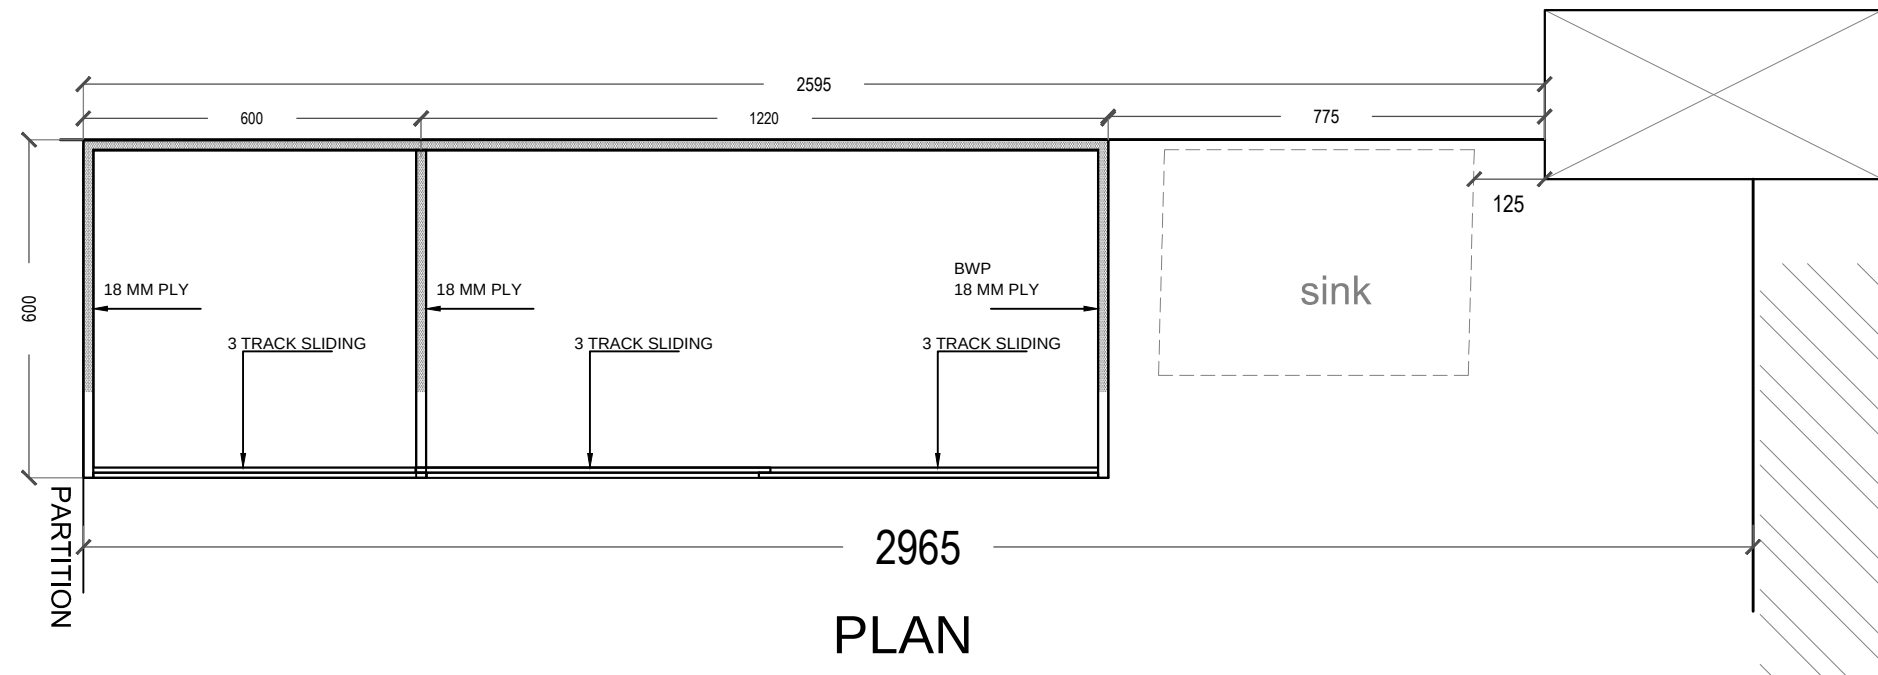


PLAN

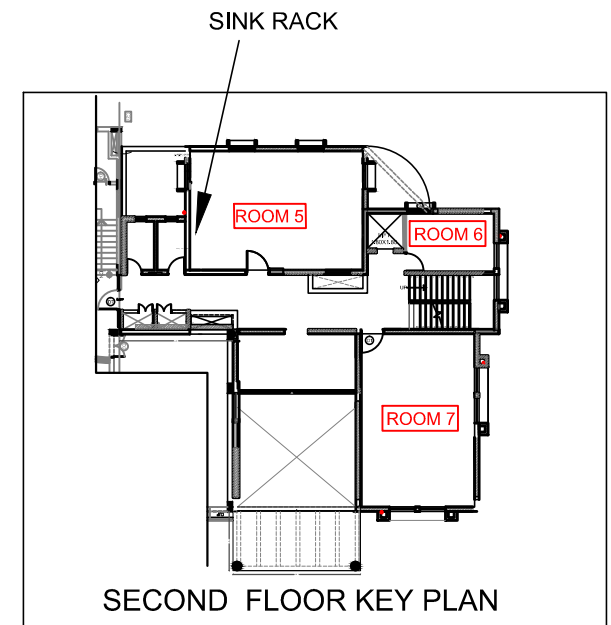


SINK RACK DETAILS-
TELESCOPE MAKING LAB


MS RAJEEV VISHWASRAO ARCHITECTS (PUNE) AND NOT TO BE COPIED OR USED WITHOUT THEIR WRITTEN PERMISSION. C:\Users\PC\Downloads\IUCAA -TLC SINK RACK.DWG RACF- 20.1.2020.dwg	NO REVISIONS	ALL DIMENSIONS SHALL BE CHECKED & CO-RELATED WITH STRUCTURAL / WORKING DRAWINGS & AMBIGUITY SHALL BE IMMEDIATELY BROUGHT TO THE NOTICE OF THE ARCHITECTS BEFORE ITS EXECUTION. THIS DRAWING SHOULD NOT BE SCALED & ONLY WRITTEN DIMENSIONS TO BE FOLLOWED. ALL DIMENSIONS ARE IN METER UNLESS OTHERWISE SPECIFIED.	ARCHITECT RAJEEV VISHWASRAO ARCHITECTS & PLANNERS SANSKRITI 3RD FLOOR PLOT NO. 2, SADASHIV PETH, PUNE - 411001. TEL. NO. : 020 24530006, 24532008		TITLE : TELESCOPE MAKING LAB- SINK RACK DETAILS PROJECT : TEACHER'S LEARNING CENTRE AT IUCAA CAMPUS CLIENT : THE DIRECTOR IUCAA SCALE : NTS DATE : 31.08.18 DESIGN : KAVITA		DRG. NO. IU/TLC/IN/350 DATE : 20.1.2020

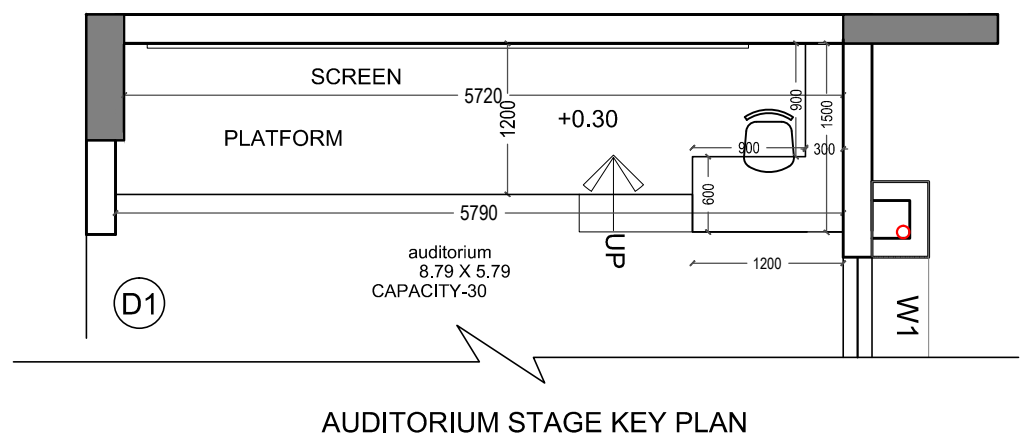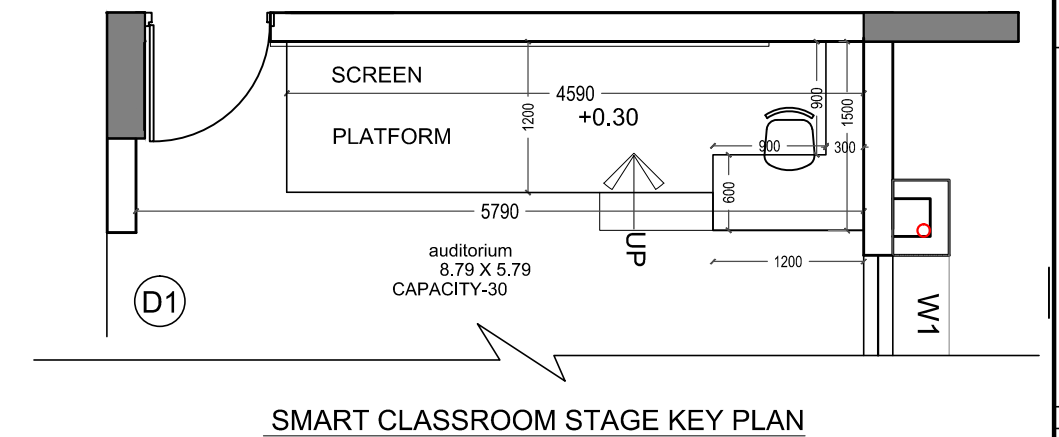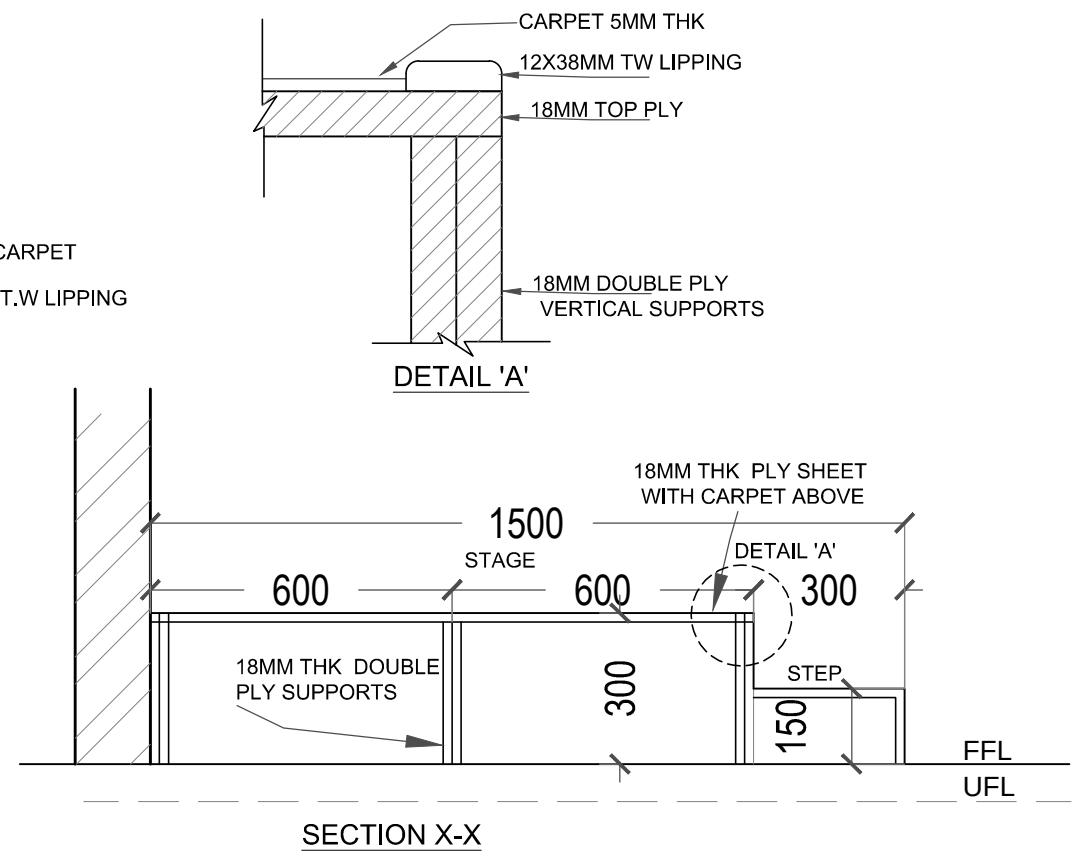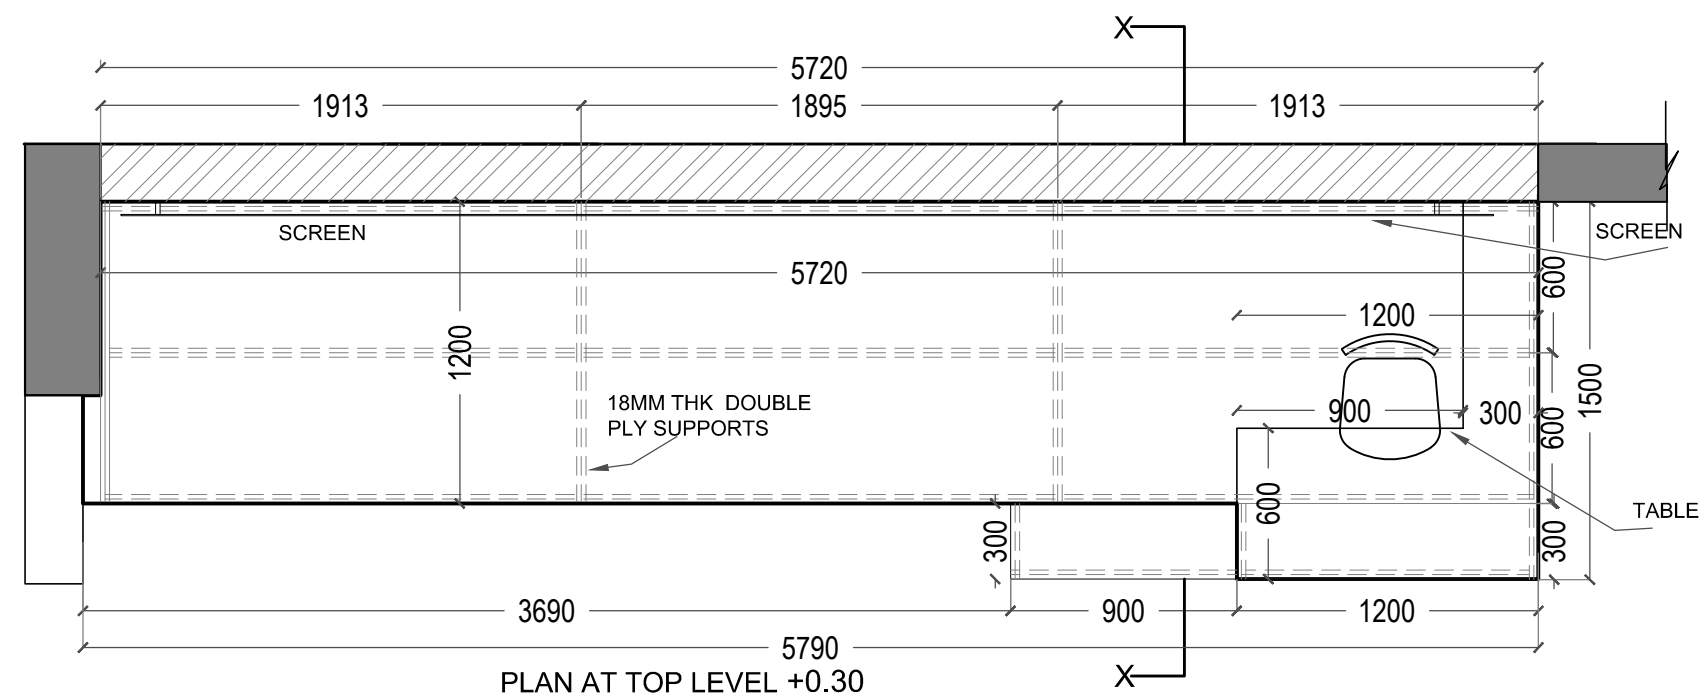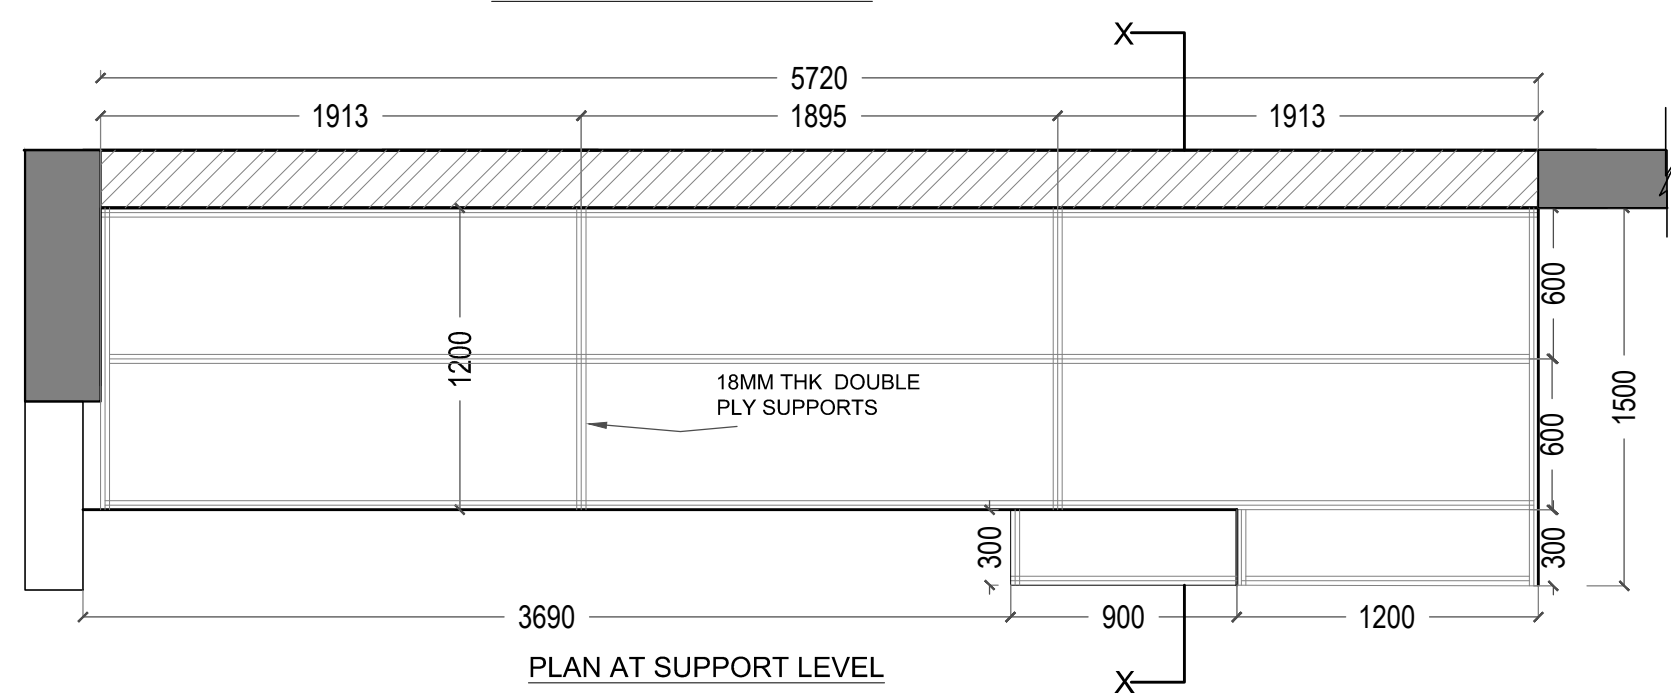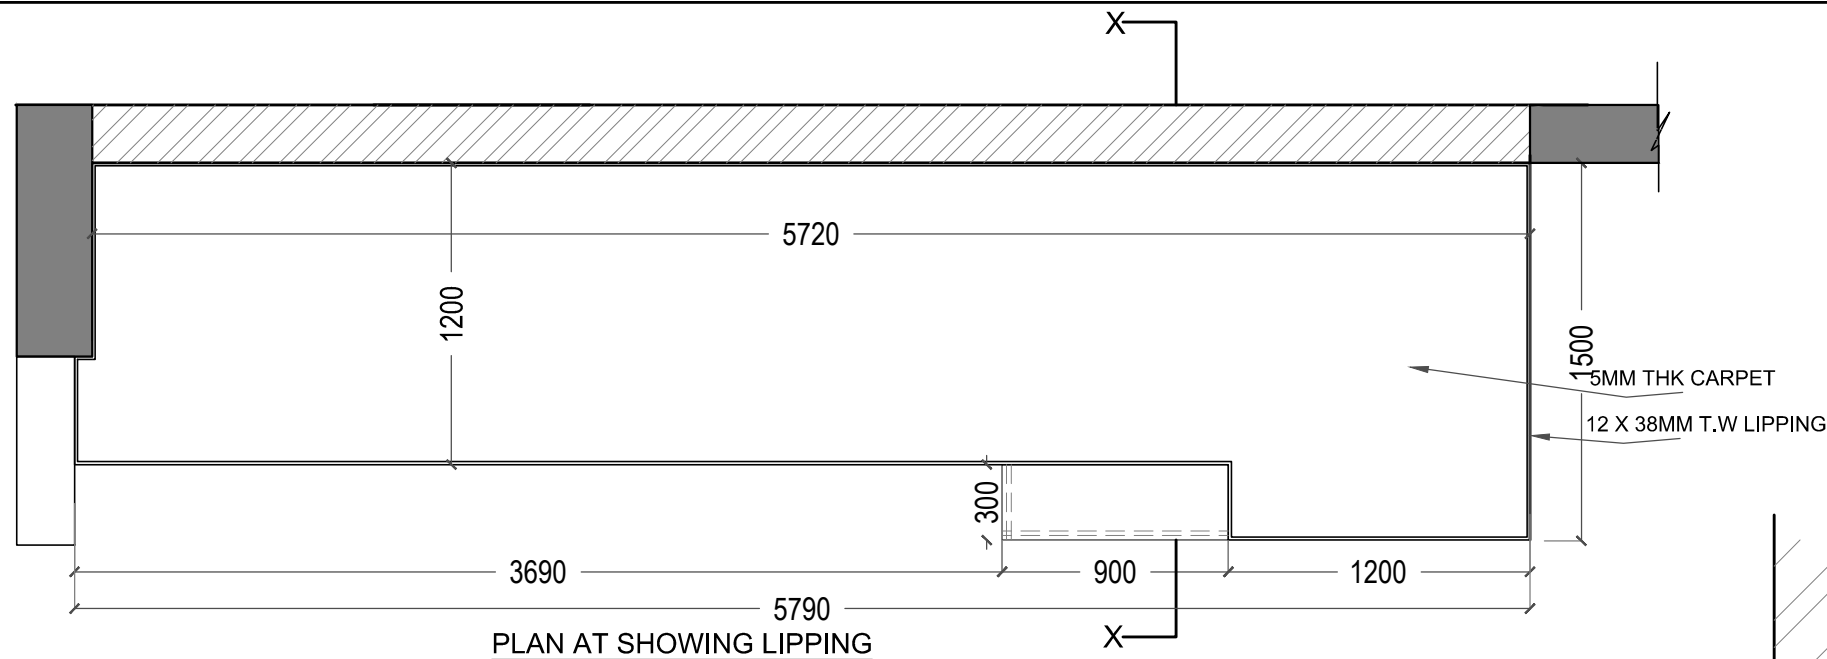


THE DRAWING IS THE PROPERTY OF MS RAJEEV VISHWASRAO ARCHITECTS (PUNE) & NOT BE LOANED, REPRODUCED, COPIED OR USED IN ANY MANNER WITHOUT THEIR WRITTEN PERMISSION. C:\Users\PC\Documents\IUCAA - TCG STAGE DETAILS- 23.12.2019.dwg	NO REVISIONS	ALL DIMENSIONS SHALL BE CHECKED & CO-RELATED WITH STRUCTURAL / WORKING DRAWINGS & AMBIGUITY SHALL BE IMMEDIATELY BROUGHT TO THE ATTENTION OF THE ARCHITECT. THIS DRAWING SHOULD NOT BE SCALED & ONLY WRITTEN DIMENSIONS TO BE FOLLOWED. ALL DIMENSIONS ARE IN METER UNLESS OTHERWISE SPECIFIED.	ARCHITECT RAJEEV VISHWASRAO ARCHITECTS & PLANNERS "SANSKRITI 3RD FLOOR PLOT NO. 2, SADASHIV PEETH, PUNE - 411 008. TEL. NO. - 020 24530068, 24532088	TITLE : AUDITORIUM STAGE DETAILS		DRG. NO.
				PROJECT : TEACHER'S LEARNING CENTRE AT IUCAA CAMPUS		IU/TLC/IN/124
				CLIENT : THE DIRECTOR IUCAA		DATE :
				SCALE : NTS		23.12.19
				DESIGN : KAVITA		

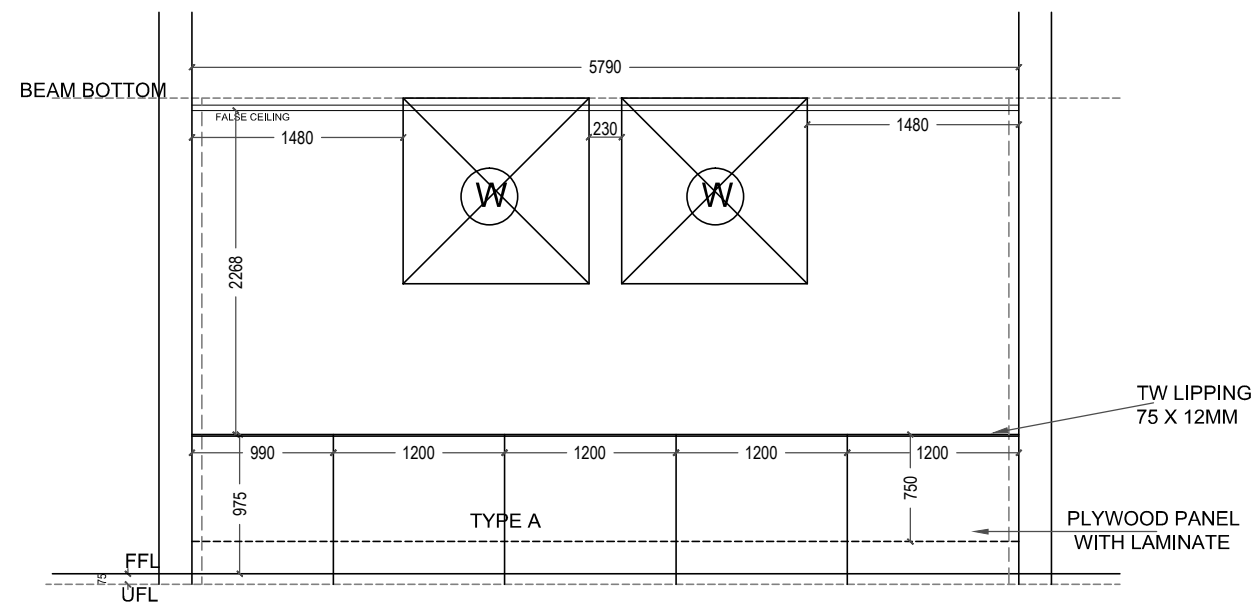


ELEVATION A

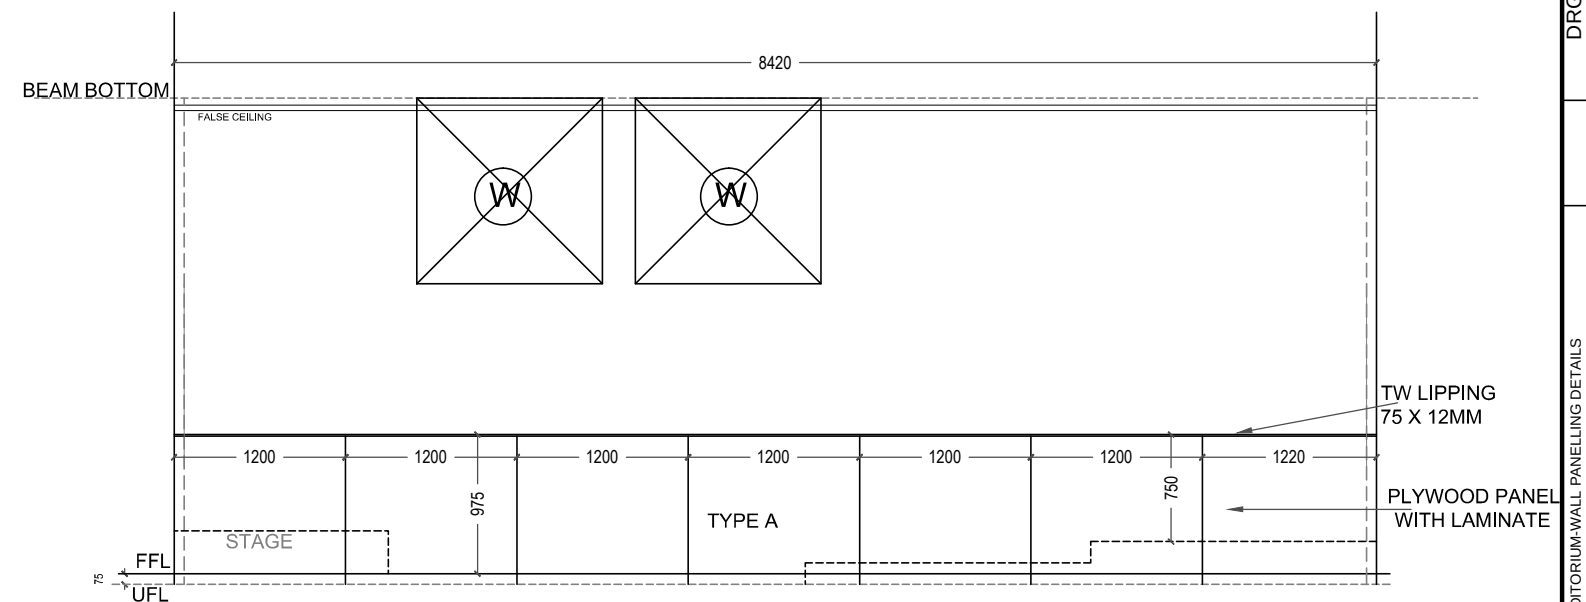


ELEVATION B

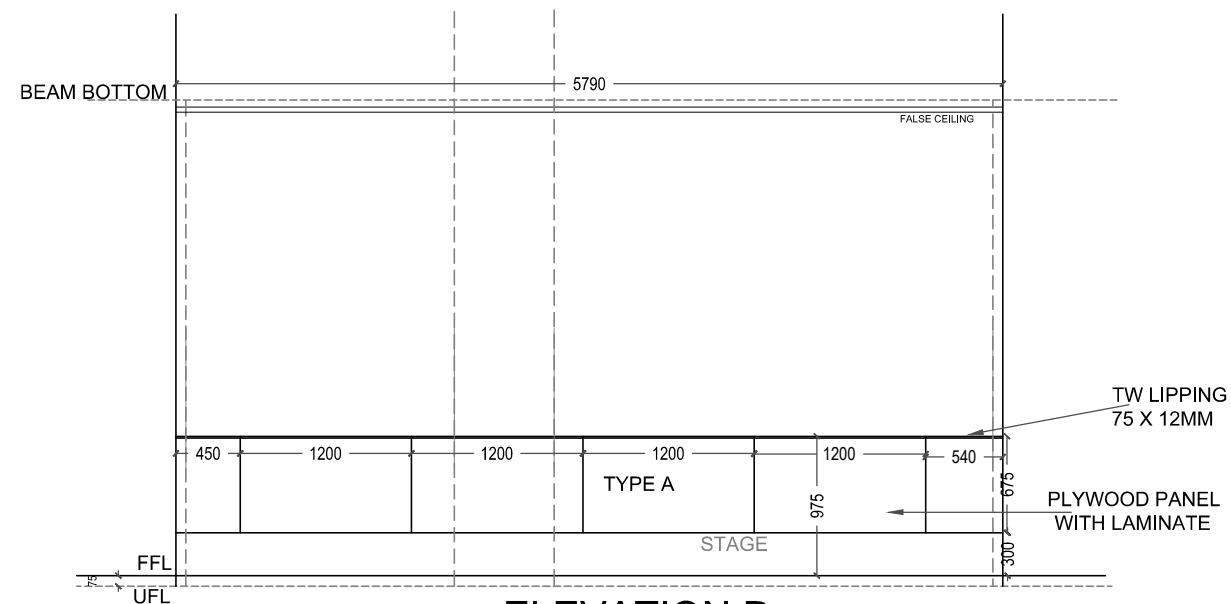


ELEVATION D

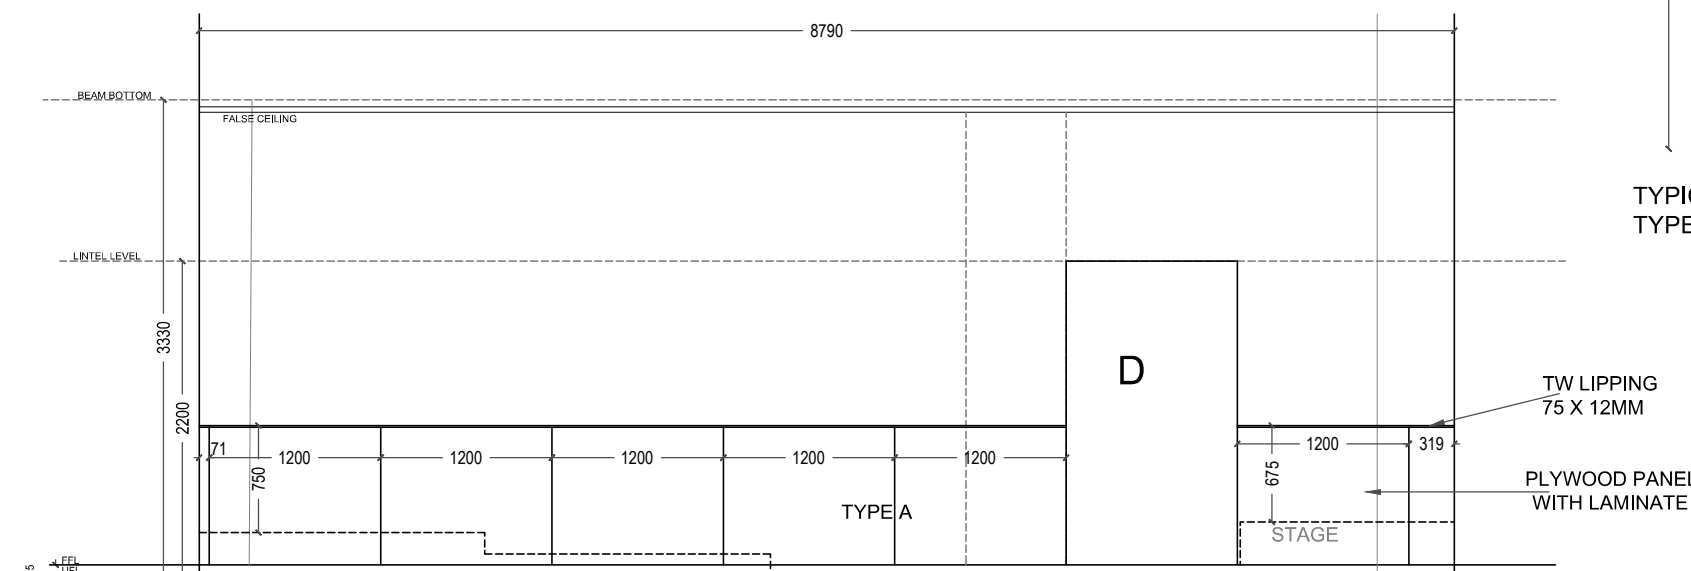

ELEVATION C

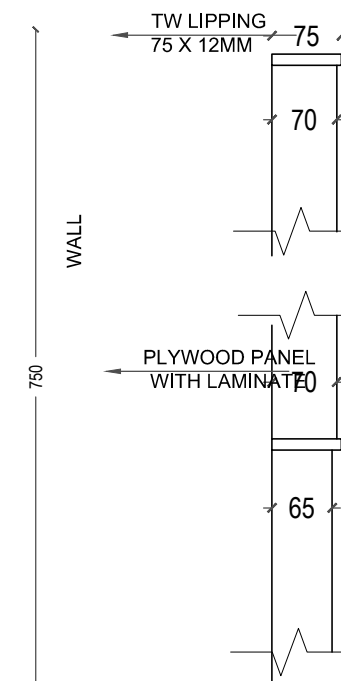


TYPICAL SECTION OF
TYPE A PANEL

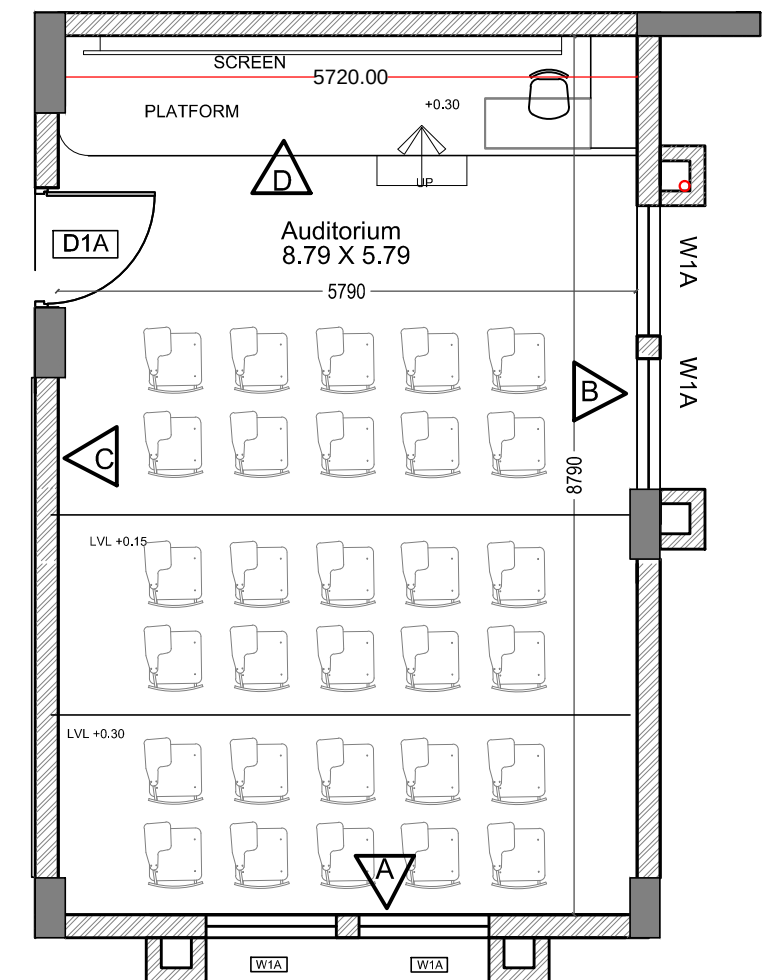

AUDITORIUM WALL PANELLING DETAILS

THIS DRAWING IS THE PROPERTY OF MS RAJEEV VISHWASRAO ARCHITECTS (PUNE) AND NOT BE LOANED, REPRODUCED, COPIED, OR IN ANY MANNER BEING REPRODUCED WITHOUT THEIR WRITTEN PERMISSION.	NO REVISIONS	ALL DIMENSIONS SHALL BE CHECKED & CO-RELATED WITH STRUCTURAL / MECHANICAL DRAWING & ARCHITECTS DRAWING IS TO BE CONSIDERED Brought TO THE ATTENTION OF THE ARCHITECTS FIRM. IT IS NOT TO BE THIS DRAWING SHOULD NOT BE SCALED & ONLY WRITTEN DIMENSIONS TO BE FOLLOWED. ALL DIMENSIONS ARE IN METER UNLESS OTHERWISE SPECIFIED.	ARCHITECT RAJEEV VISHWASRAO ARCHITECTS & PLANNERS 'SANSKRITI' 2RD FLOOR, PLOT NO. 3, SAKSHI, PETH, PUNE - 411 030. TEL. NO. - 020 24530008, 24532008		TITLE : AUDITORIUM-WALL PANELLING DETAILS PROJECT : TEACHER'S LEARNING CENTRE AT IUCAA CAMPUS CLIENT : THE DIRECTOR, IUCAA SCALE : NTS DATE : 31.08.18 DESIGN : KAVITA		DRG. NO. IU/TLC/IN/123 DATE : 17.12.19	

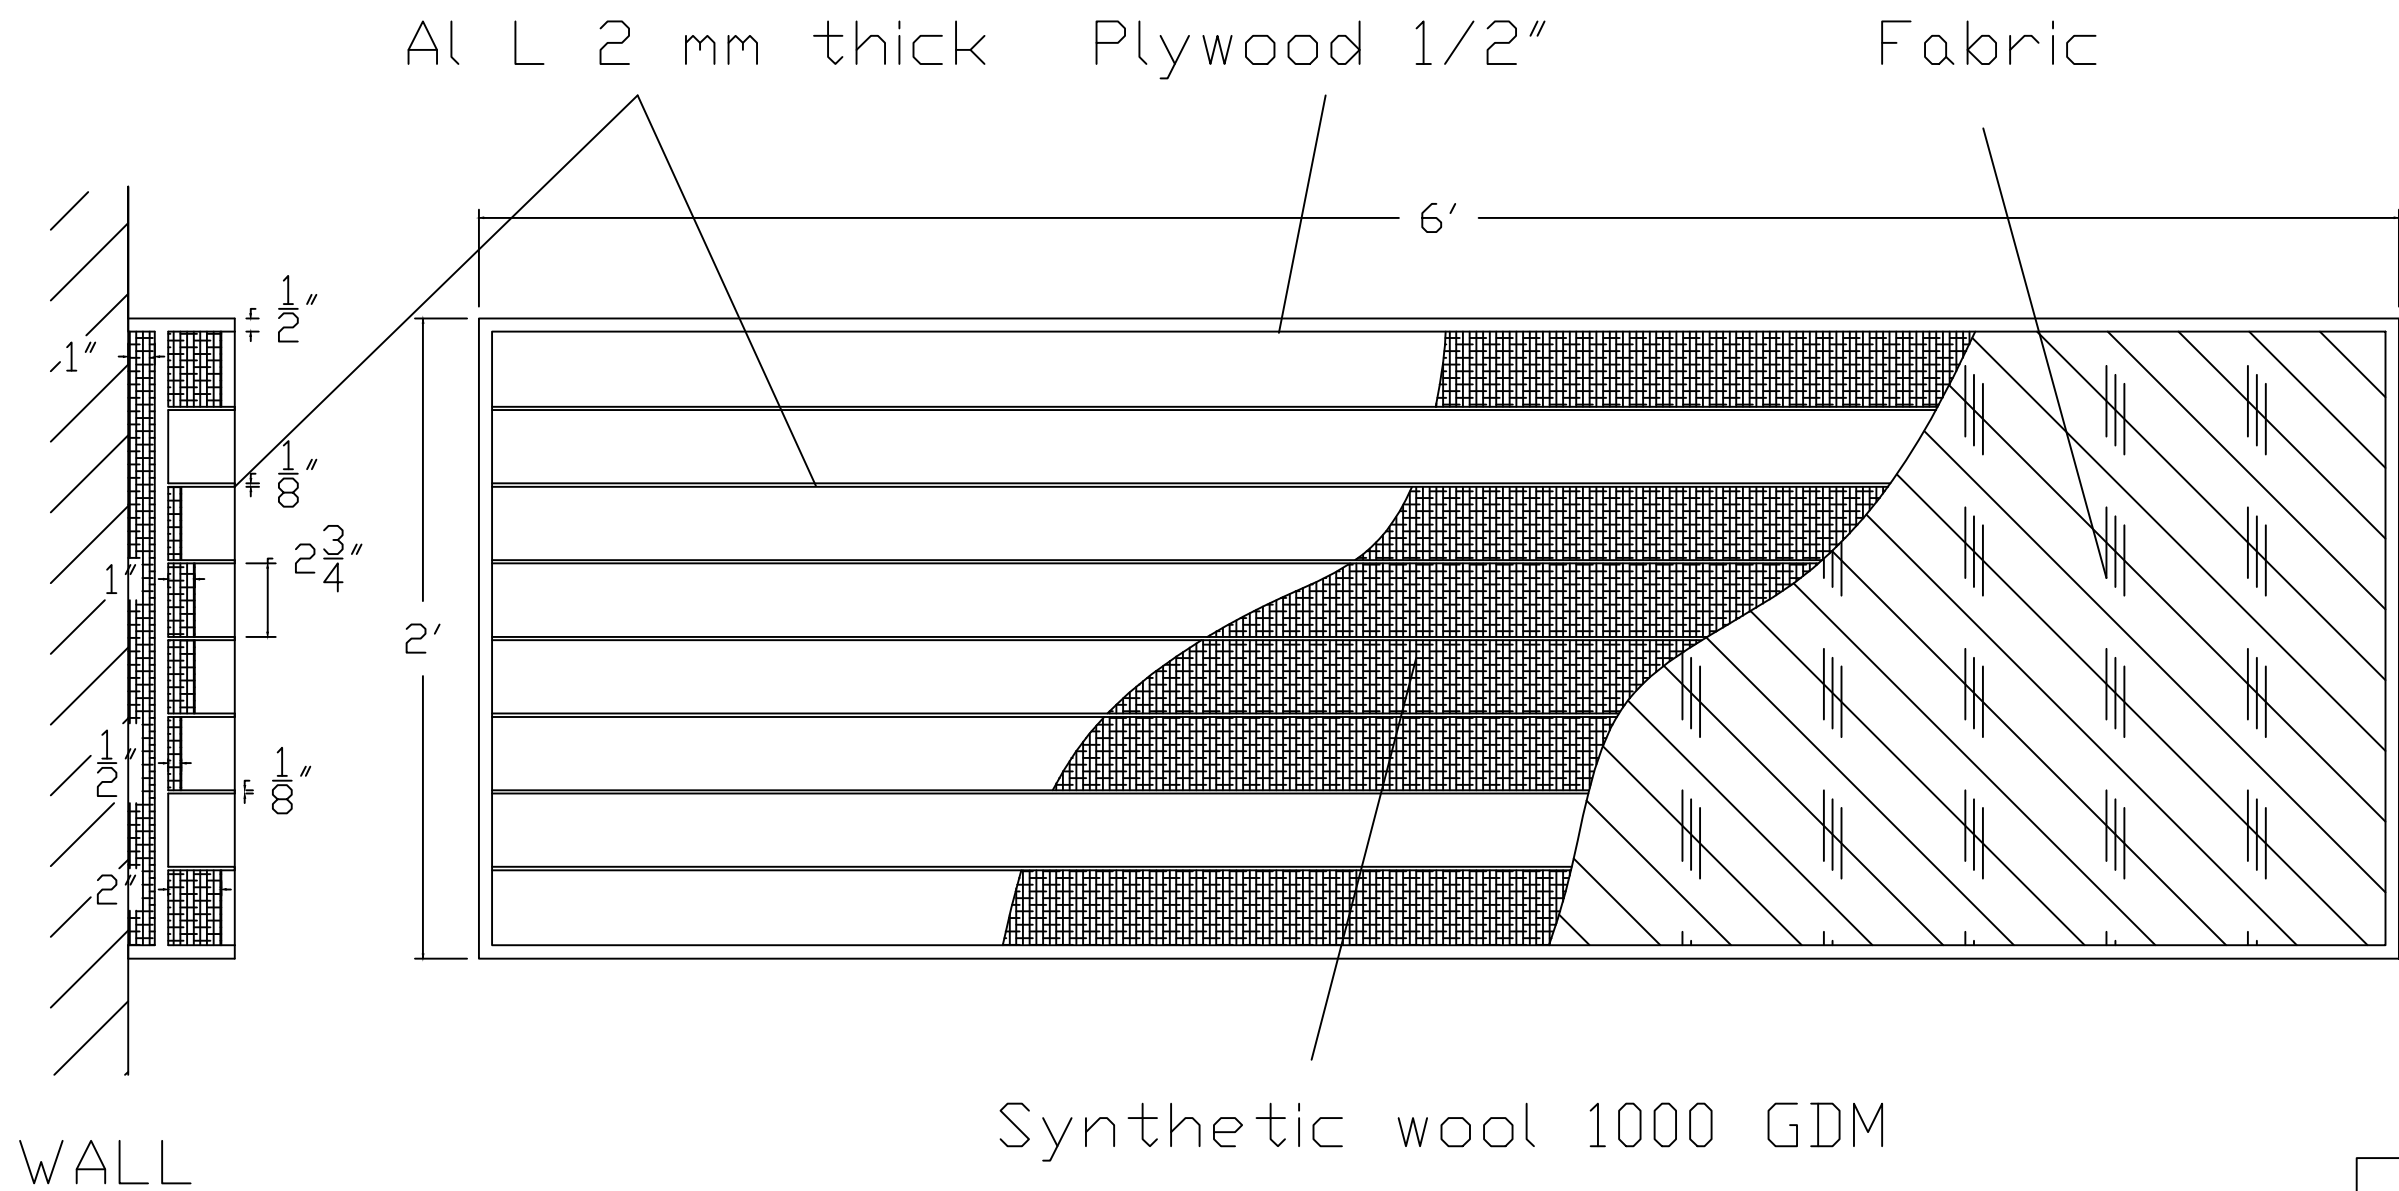


Date: 09-12-2015
Not To Scale


PROPOSED
ACOUSTICAL
DETAILS FOR
TEACHERS
LEARNING
CENTER AT IUCAA
CAMPUS,PUNE

Consultant
V. N. PURANDARE
124, Shaniwar Peth Pune 411030
Cell: 9890922712


ACOUSTICAL
DRAWING

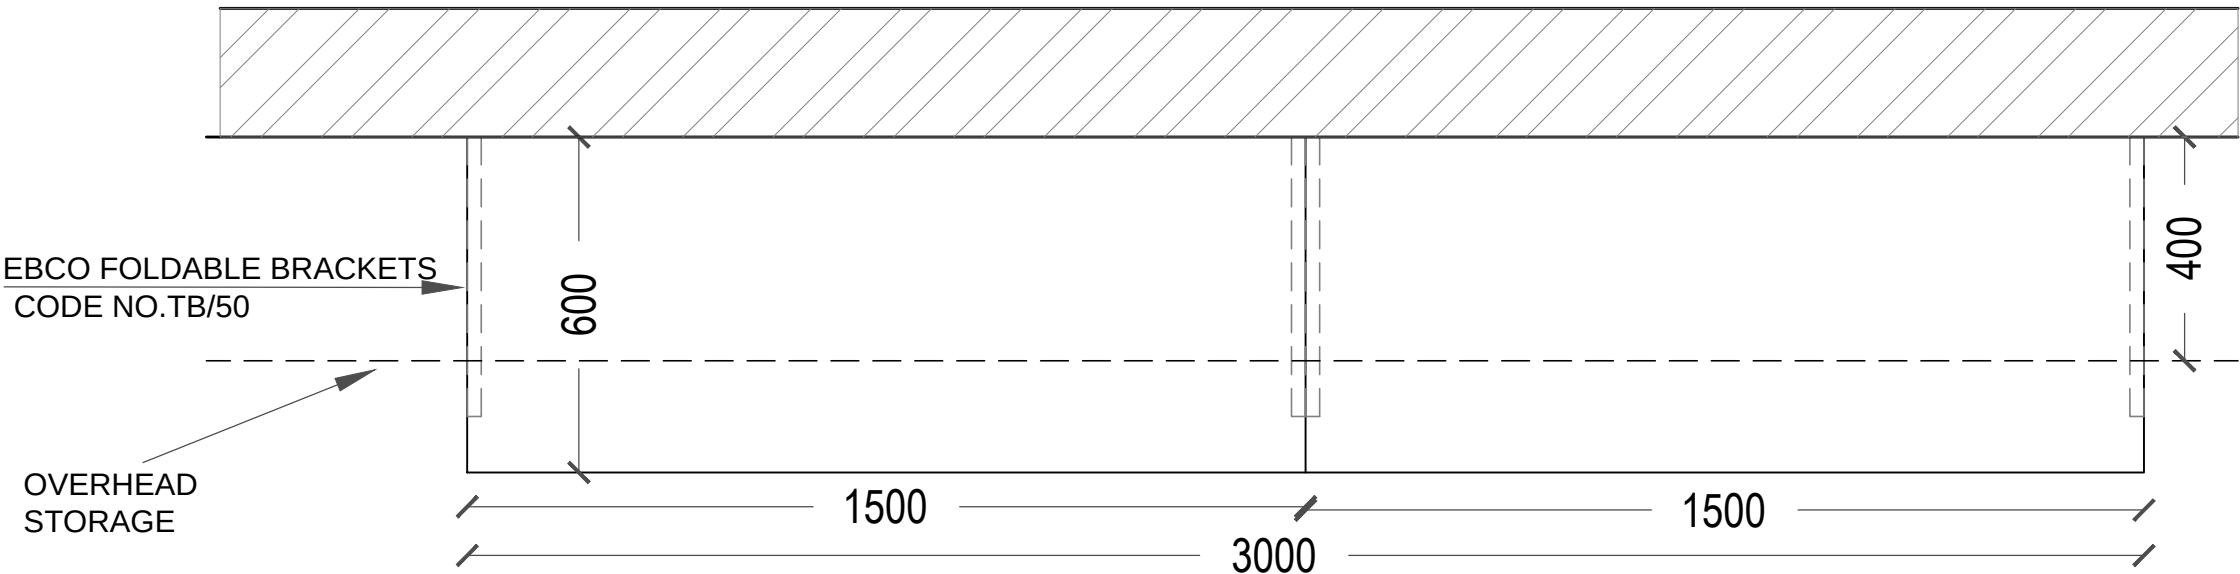

PLAN OF FOLDABLE TABLE

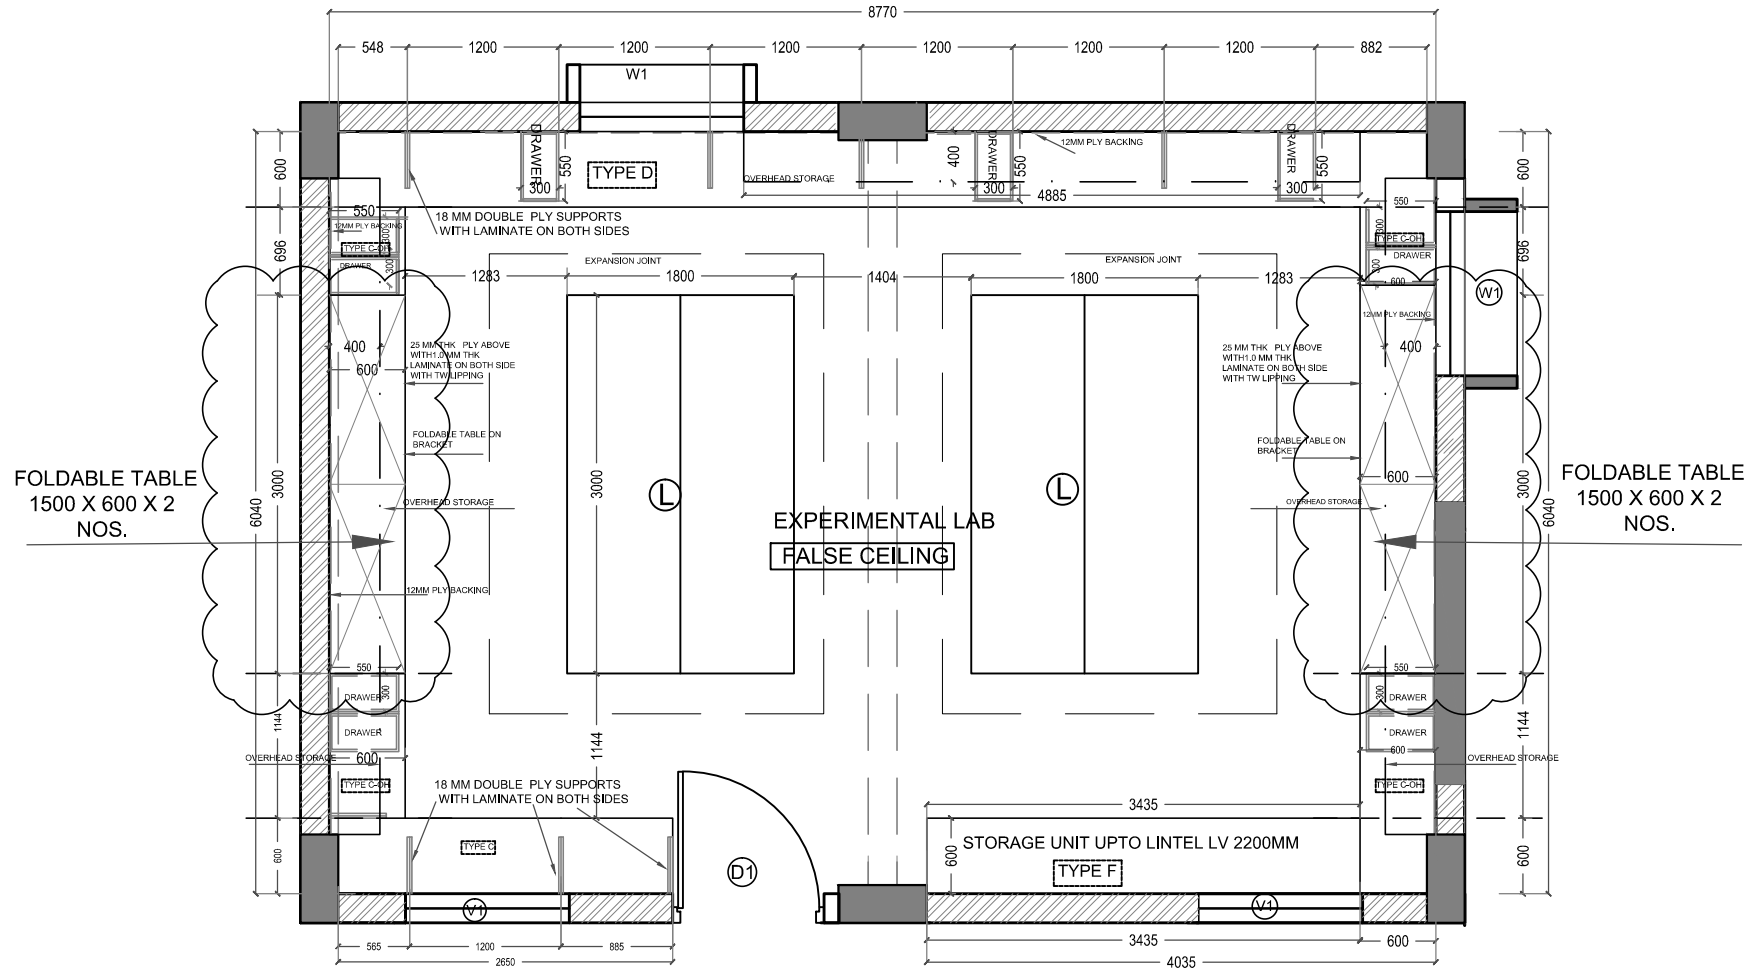


ROOM1- EXPERIMENTAL LAB

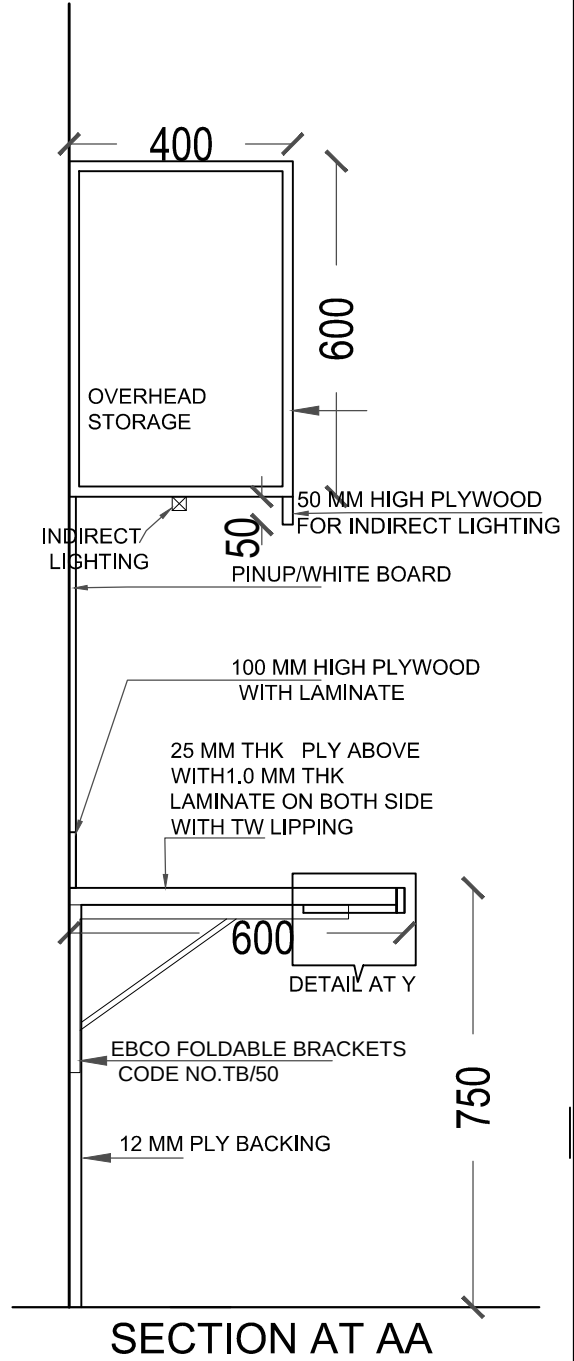


SECTION AT AA


DRG. NO.	IU/TLC/IN/111	
	DATE :	
	6.1.2020	
TITLE : FOLDING TABLE DETAILS	PROJECT : TEACHER'S LEARNING CENTRE AT IUCAA CAMPUS	
	CLIENT : THE DIRECTOR IUCAA	
	SCALE : NTS	
	DATE : 31.08.18 DESIGN : KAVITA	
ARCHITECT	RAJEEV VISHW1ASRAO	
	ARCHITECTS & PLANNERS	
	SANSKRITI 3RD FLOOR PLOT NO. 2, SADASHIV PETH,	
	PUNE - 411 005. TEL. NO. : 020 24350006, 24350008	
NO. REVISIONS		
ALL DIMENSIONS SHALL BE CHECKED & CO-RELATED WITH STRUCTURAL WORKING DRAWINGS & AMBIGUITY SHALL BE IMMEDIATELY BROUGHT TO THE ARCHITECT'S ATTENTION. THIS DRAWING SHOULD NOT BE SCALED & ONLY WRITTEN DIMENSIONS TO BE FOLLOWED. ALL DIMENSIONS ARE IN METER UNLESS OTHERWISE SPECIFIED.		
THIS DRAWING IS THE PROPERTY OF MS RAJEEV VISHW1ASRAO ARCHITECTS (PUNE) & NOT TO BE REPRODUCED OR COPIED WITHOUT THEIR WRITTEN PERMISSION.		

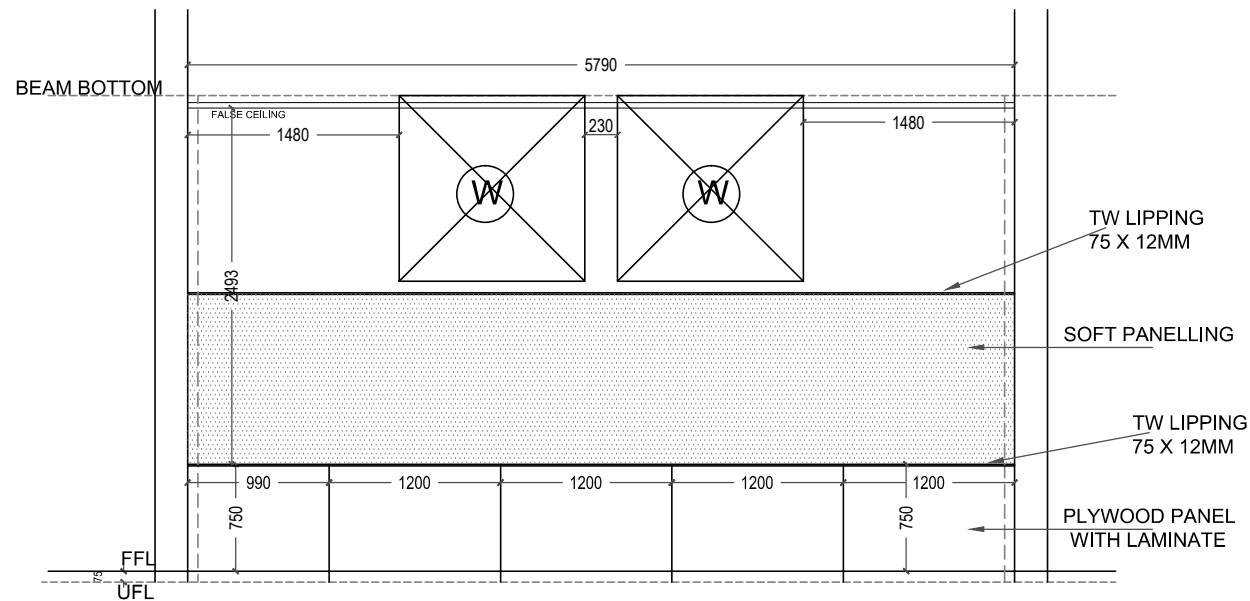


ELEVATION A

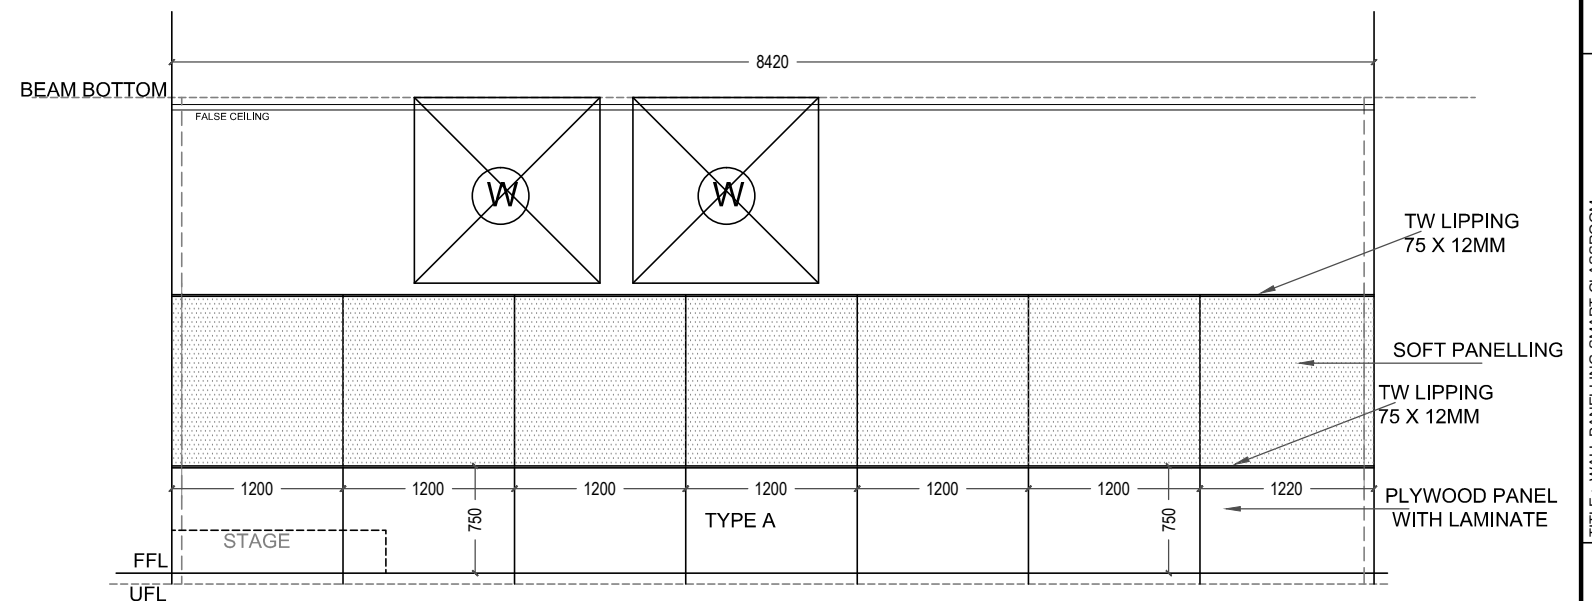



ELEVATION B

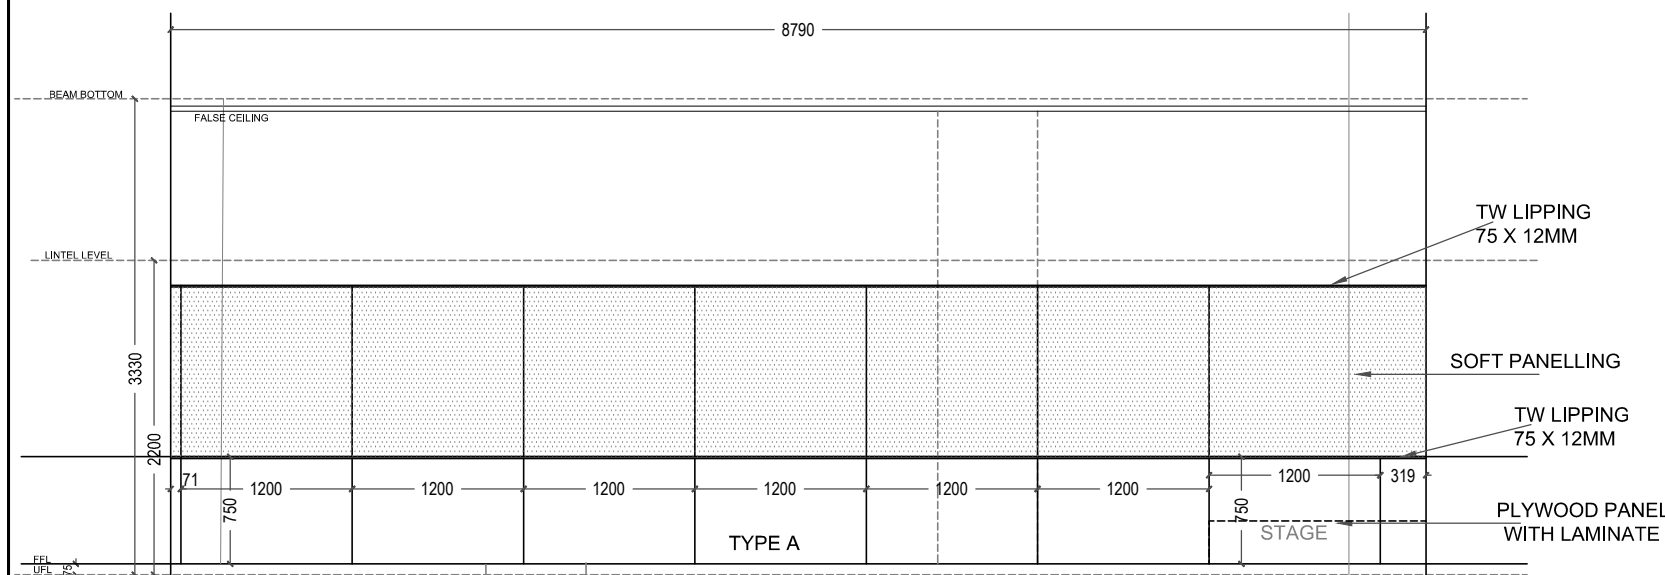

ELEVATION C

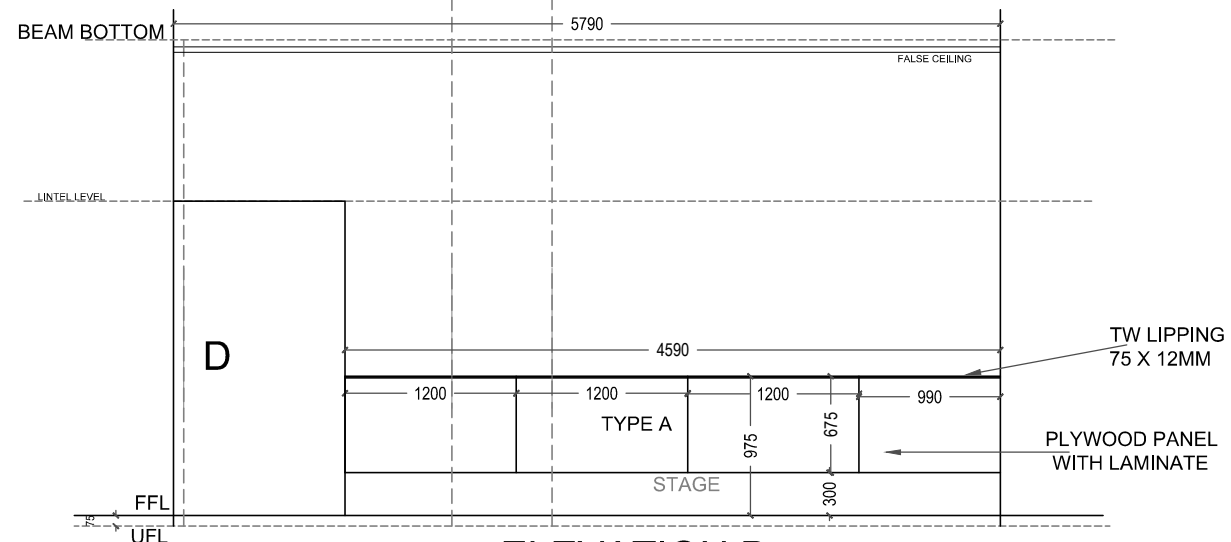

ELEVATION D

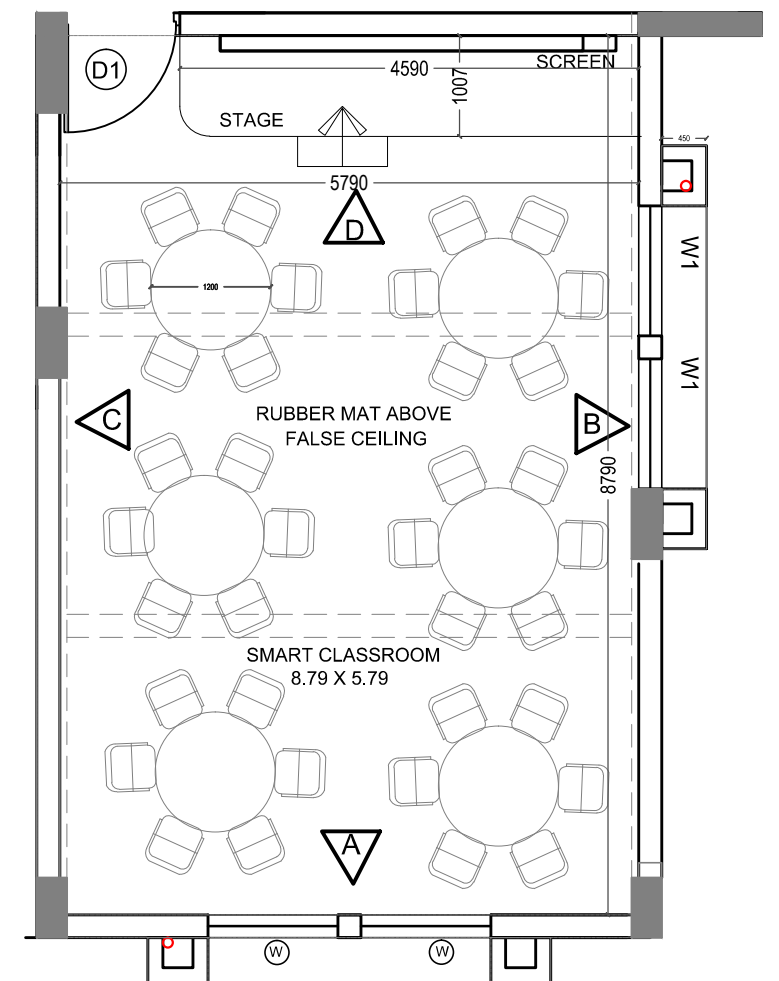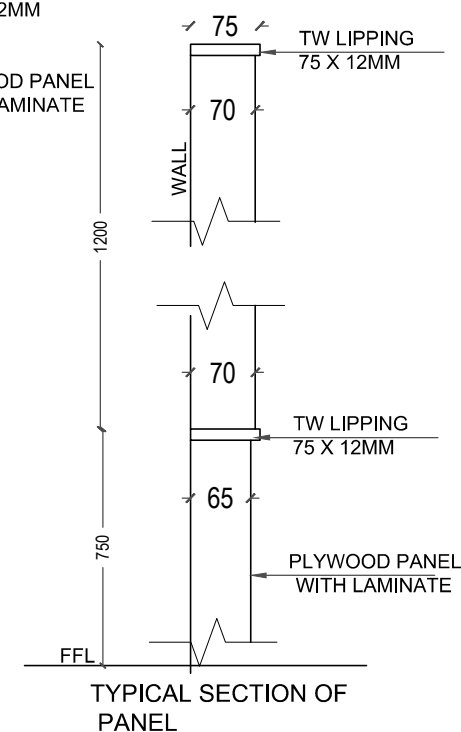

PLAN SMART CLASSROOM WALL PANELLING DETAILS

DRG. NO.	IU/TLC/IN/234	
	DATE : 17.12.19	
TITLE : WALL PANELLING-SMART CLASSROOM	PROJECT : TEACHER'S LEARNING CENTRE AT IUCAA CAMPUS	
	CLIENT : THE DIRECTOR IUCAA	
	SCALE : NTS	
ARCHITECT	DATE : 31.08.18	
	DESIGN : KAVITA	
ARCHITECT	ARCHITECT : RAJEEV VISHWASRAO	
	ARCHITECTS & PLANNERS	
	SANSKRITI 3RD FLOOR PLOT NO. 2, SADASHIV PETH, PUNE - 411 006. TEL. NO. : 020 24530006, 24530208	
NO REVISIONS		
ALL DIMENSIONS SHALL BE CHECKED & CO-RELATED WITH STRUCTURAL / WORKING DRAWINGS & AMBIGUITY SHALL BE IMMEDIATELY BROUGHT TO THE ATTENTION OF THE ARCHITECT. THIS DRAWING SHOULD NOT BE SCALED & ONLY WRITTEN DIMENSIONS TO BE FOLLOWED.		
THIS DRAWING IS THE PROPERTY OF MS RAJEEV VISHWASRAO ARCHITECTS (PUNE) & NOT TO BE REPRODUCED OR COPIED WITHOUT THEIR WRITTEN PERMISSION.		
C:\Users\PC\Downloads\IUCAA TLC WALL PANEL 20.12.2019.dwg		

